


LIST OF ARCHITECTURAL WORKING DRAWINGS

PAGE NO	DRAWING NO	DRAWING TITLE
01	AR-00	COVER SHEET
02	AR-01	LIST OF DRAWINGS
03	AR-02	3D VIEW - 01
04	AR-03	MASTER PLAN
05	AR-04	KEY PLAN
06	AR-05	SITE PLAN
07	AR-06	F.F.E LAYOUT PLAN (GROUND FLOOR)
08	AR-07	F.F.E LAYOUT PLAN (TOP ROOF)
09	AR-08	WORKING LAYOUT PLAN (GROUND FLOOR)
10	AR-09	WORKING LAYOUT PLAN (TOP ROOF)
11	AR-10	FRONT ELEVATION E-1
12	AR-11	SECTION AT A-A
13	AR-12	SECTION AT B-B
14	AR-13	DOORS & WINDOWS LAYOUT PLAN (GROUND FLOOR)
15	AR-14	DOOR & WINDOW ELEVATIONS & SCHEDULE
16	AR-15	TAGGING LAYOUT PLAN (GROUND FLOOR)
17	AR-16	TAGGING LAYOUT PLAN (TOP ROOF)
18	AR-17	BATH DETAIL - 02 & 03 (GROUND FLOOR)




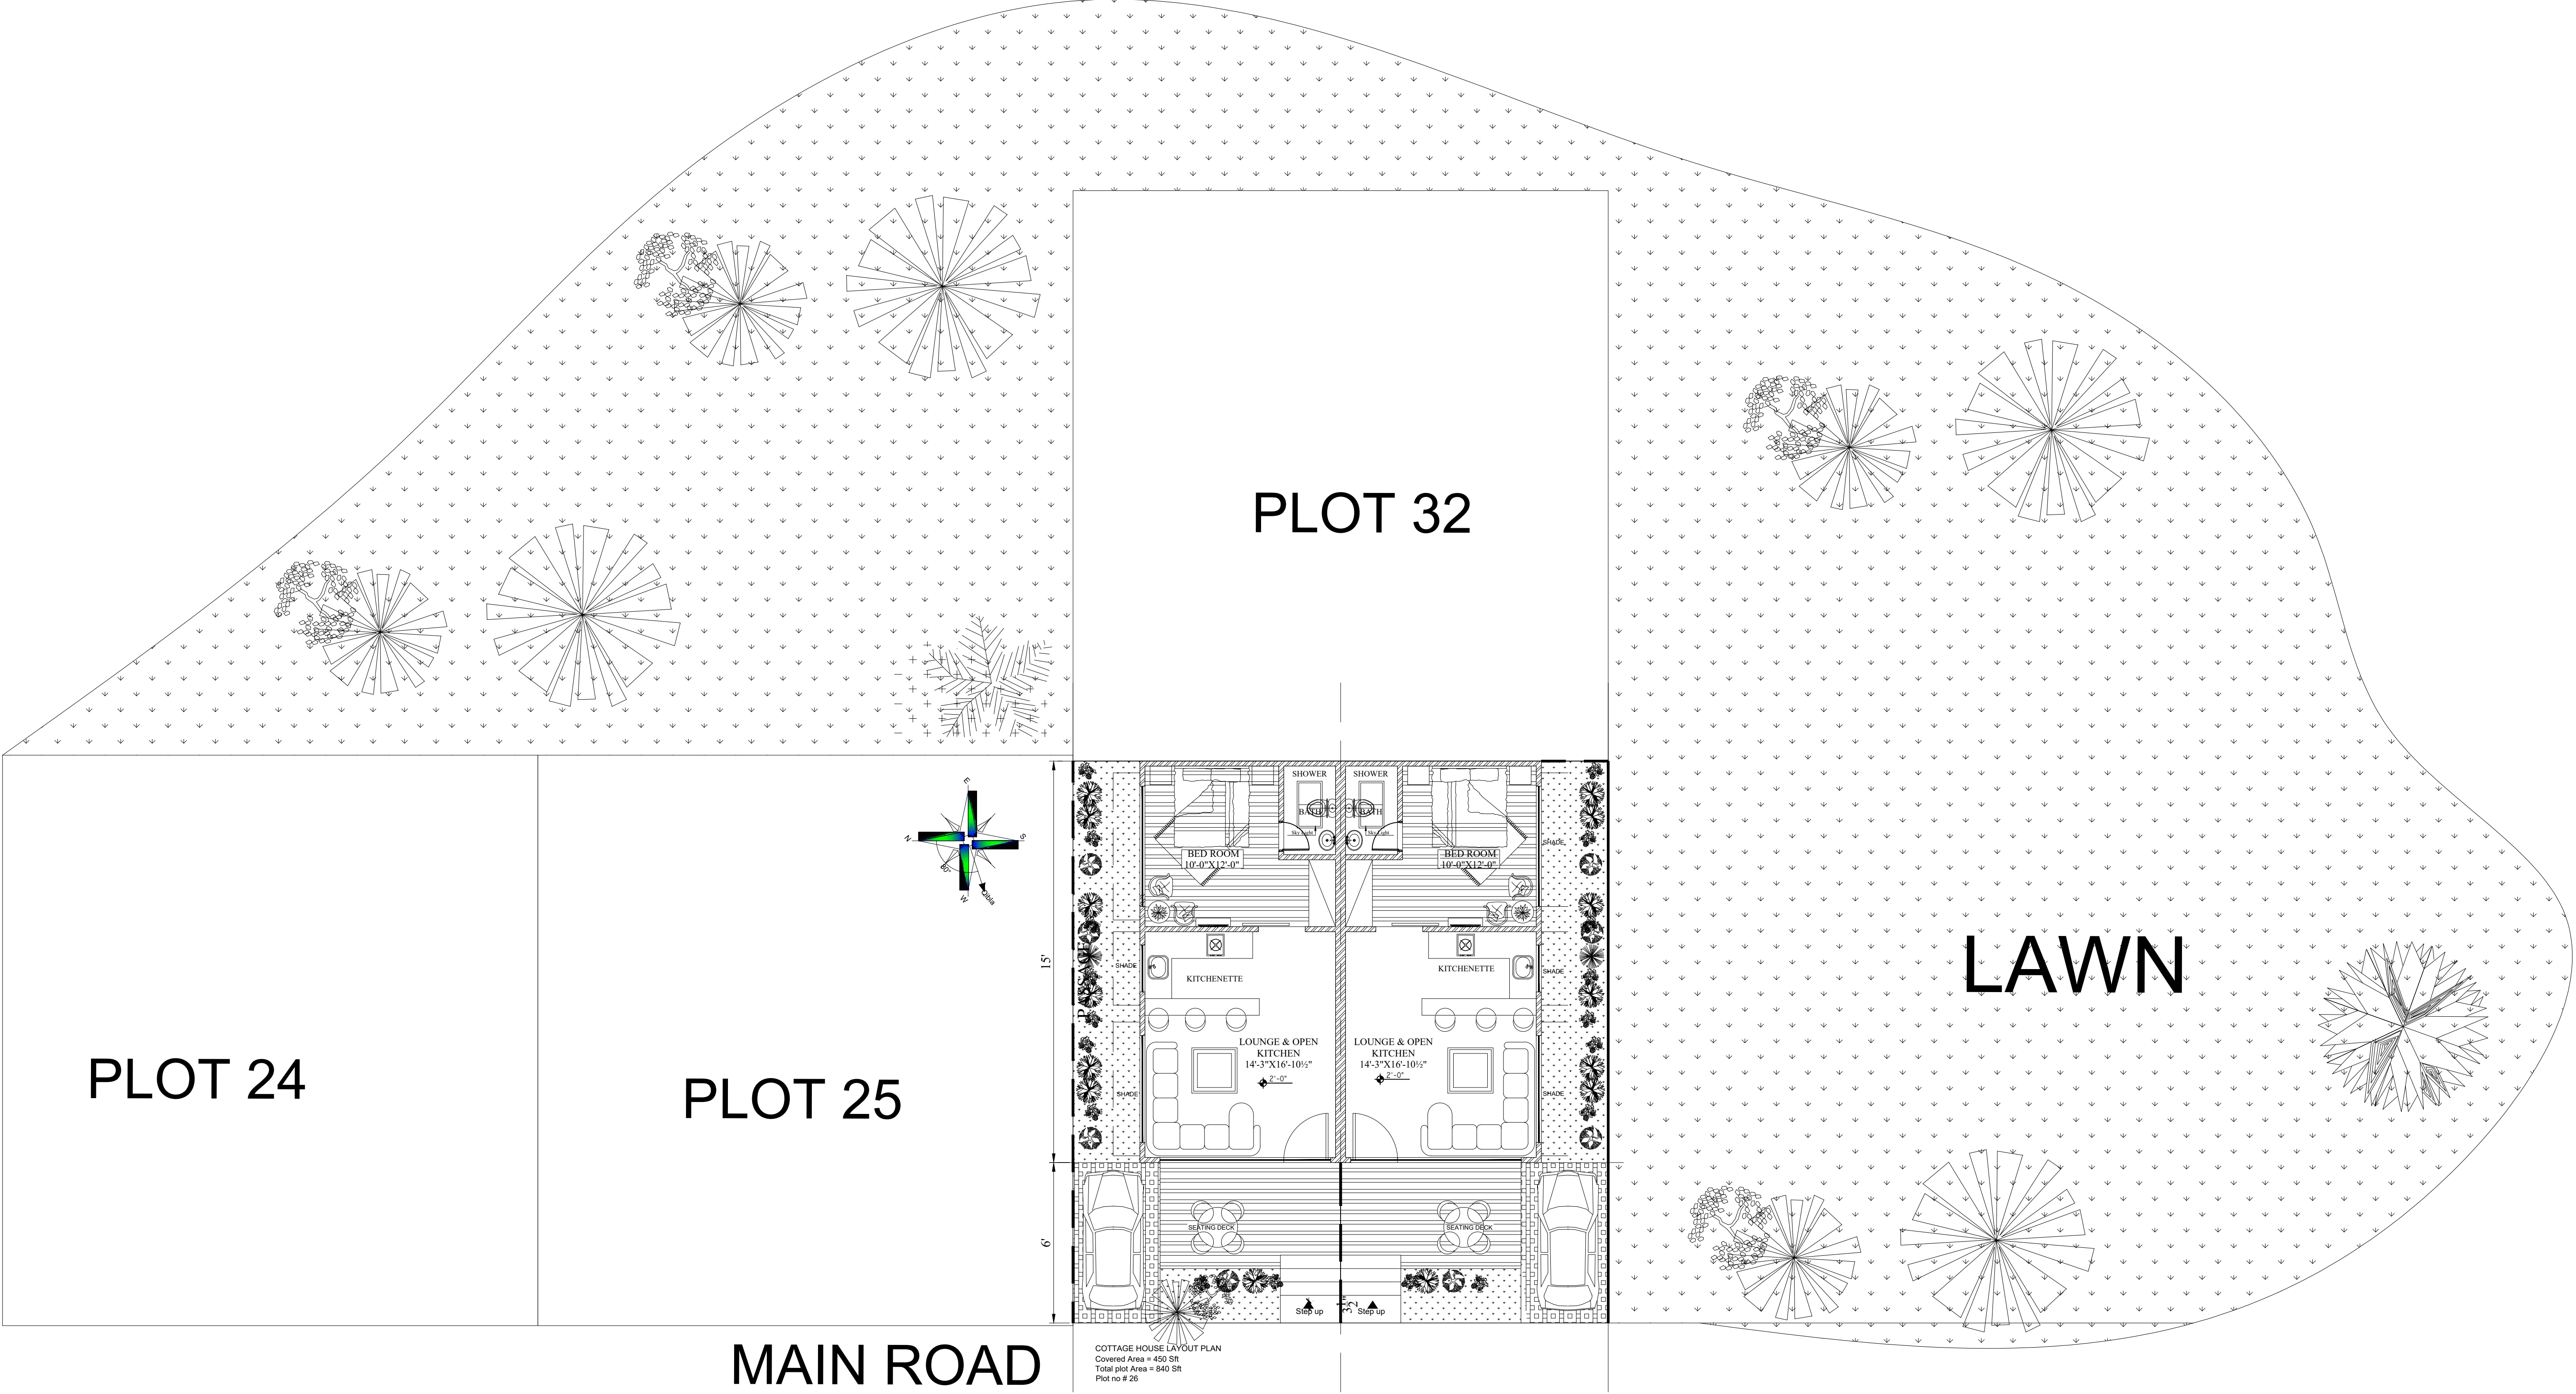


MASTER PLAN

SCALE = N.T.S


 PROPOSAL DRAWINGS	MASTER PLAN	PAGE NO.	04	DRAWING NO.	AR-03	DESIGN BY:	Aqib ali
		CLIENT:	_____	PROJECT :	MURREE COTTAGE HOUSE	DRAWN BY:	Eshan
						DATE:	23.08.2024

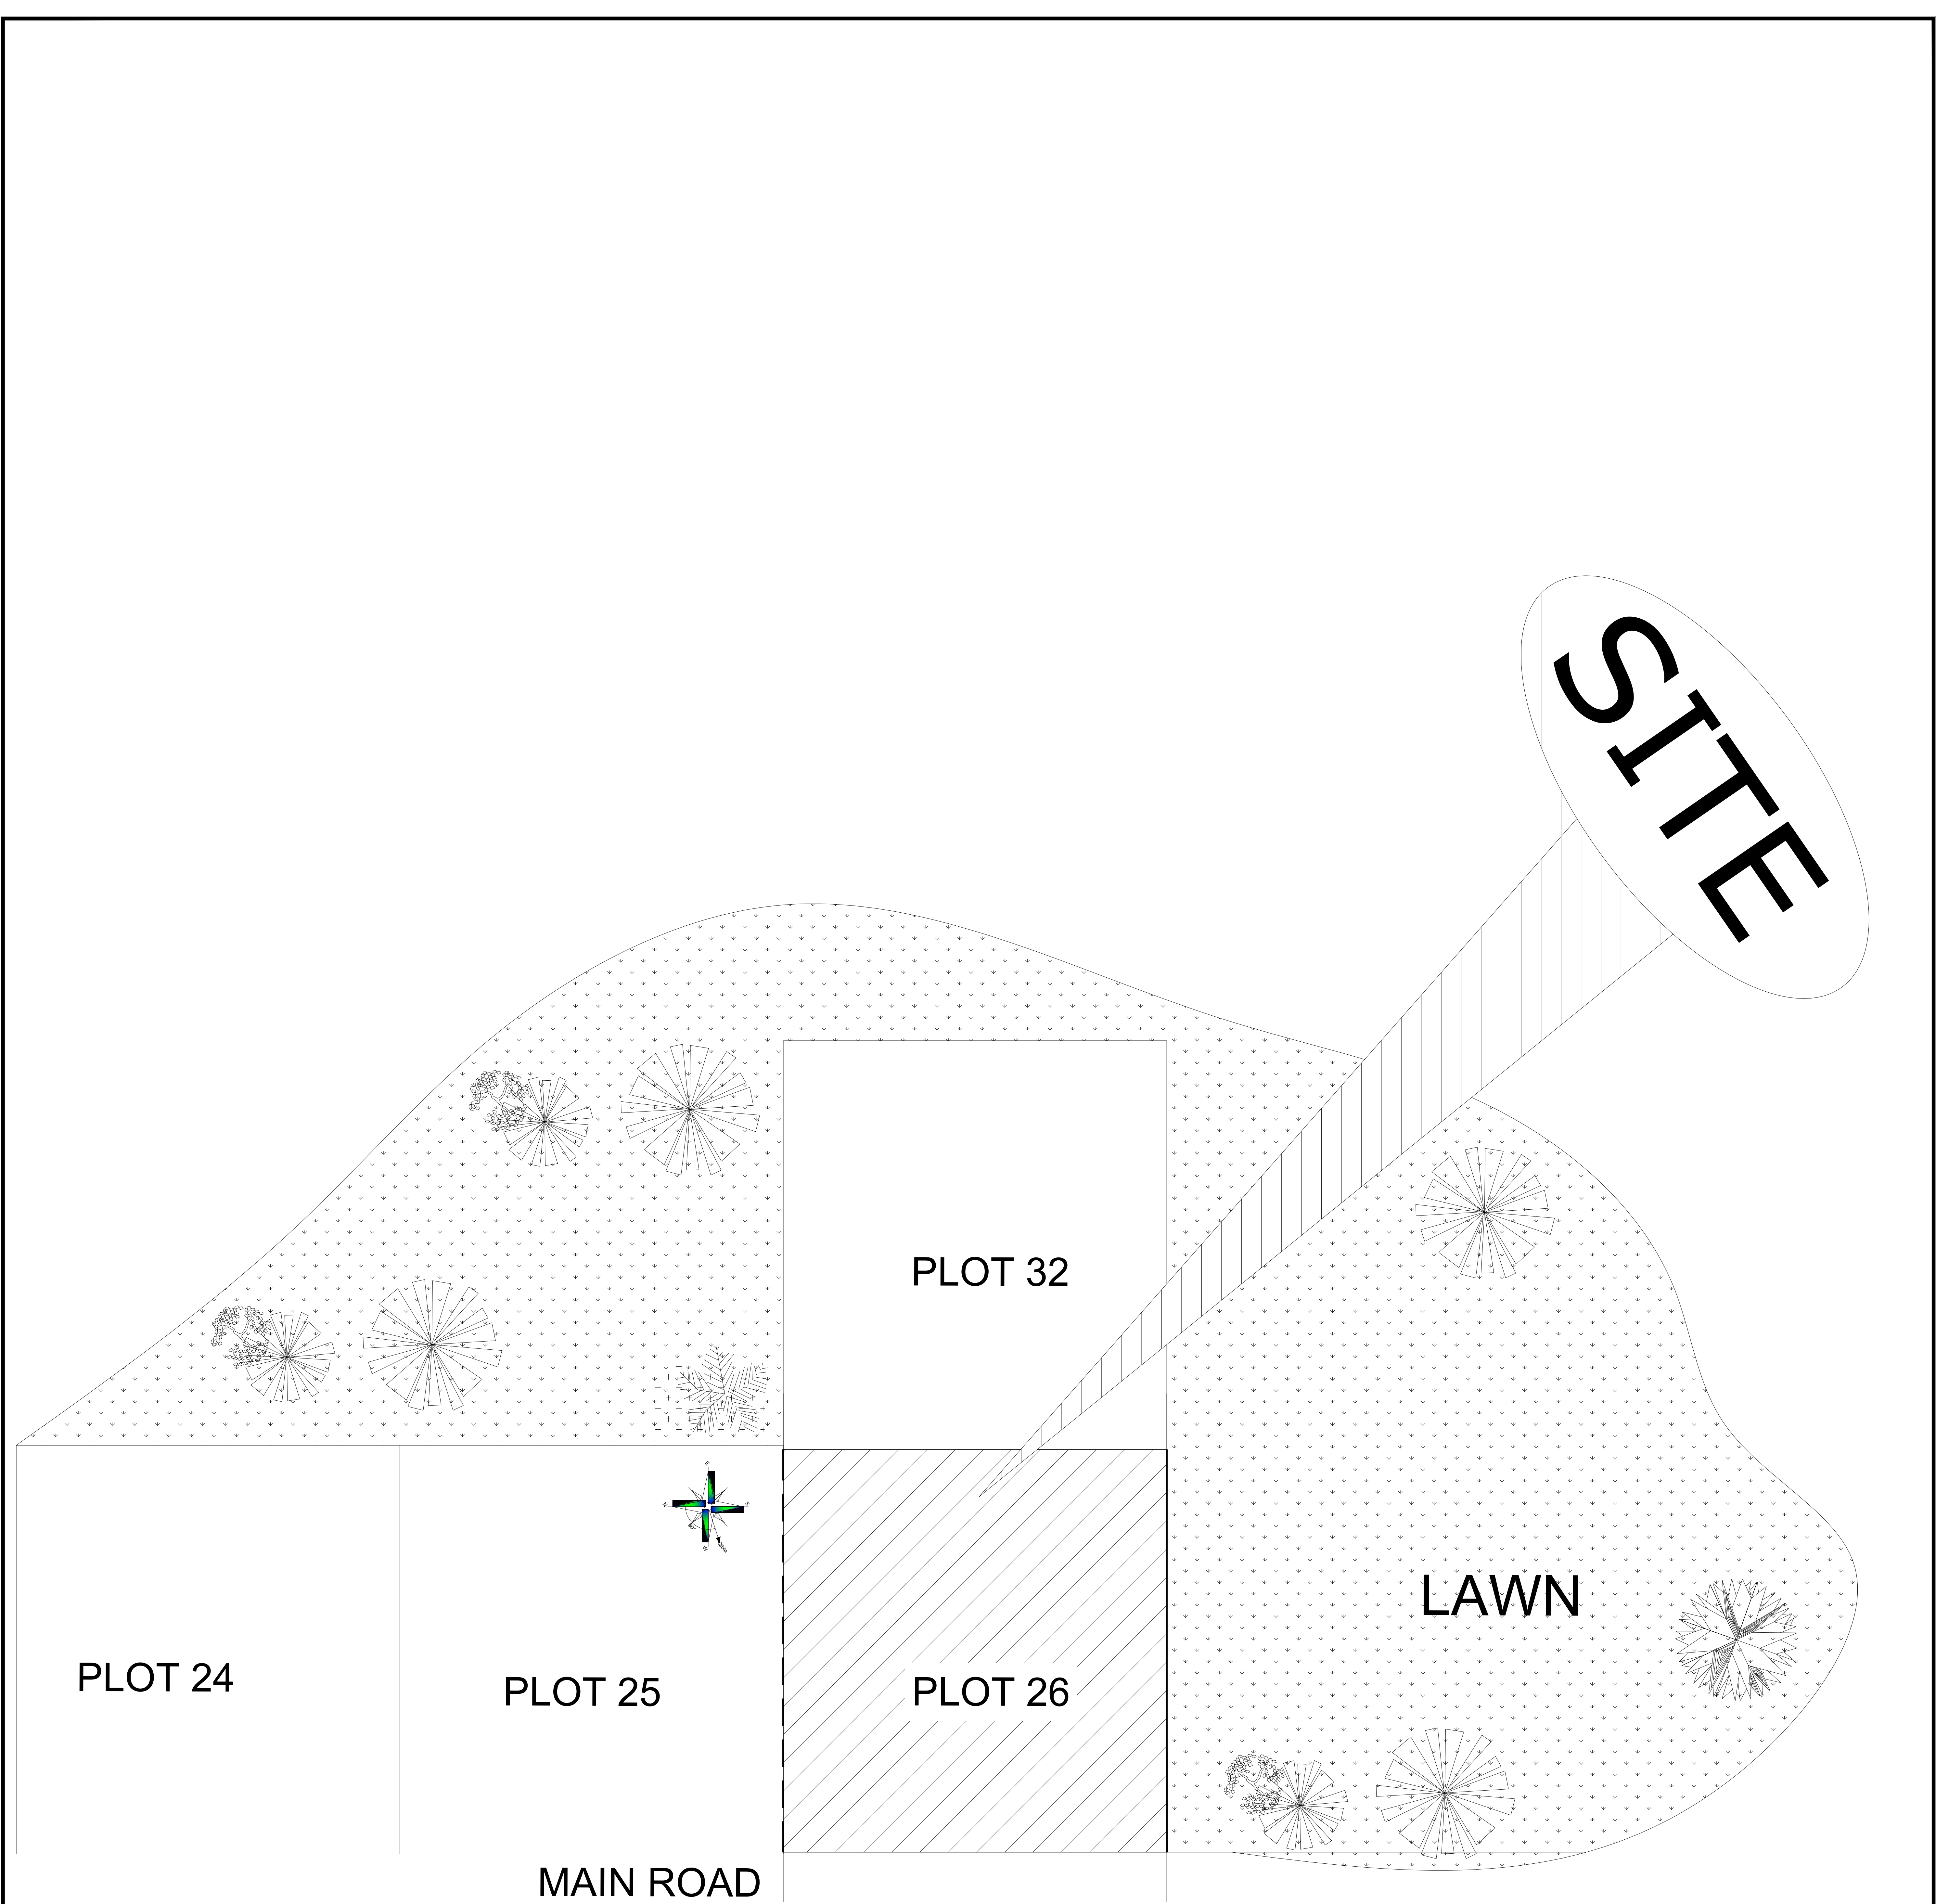

KEY PLAN
SCALE = N.T.S

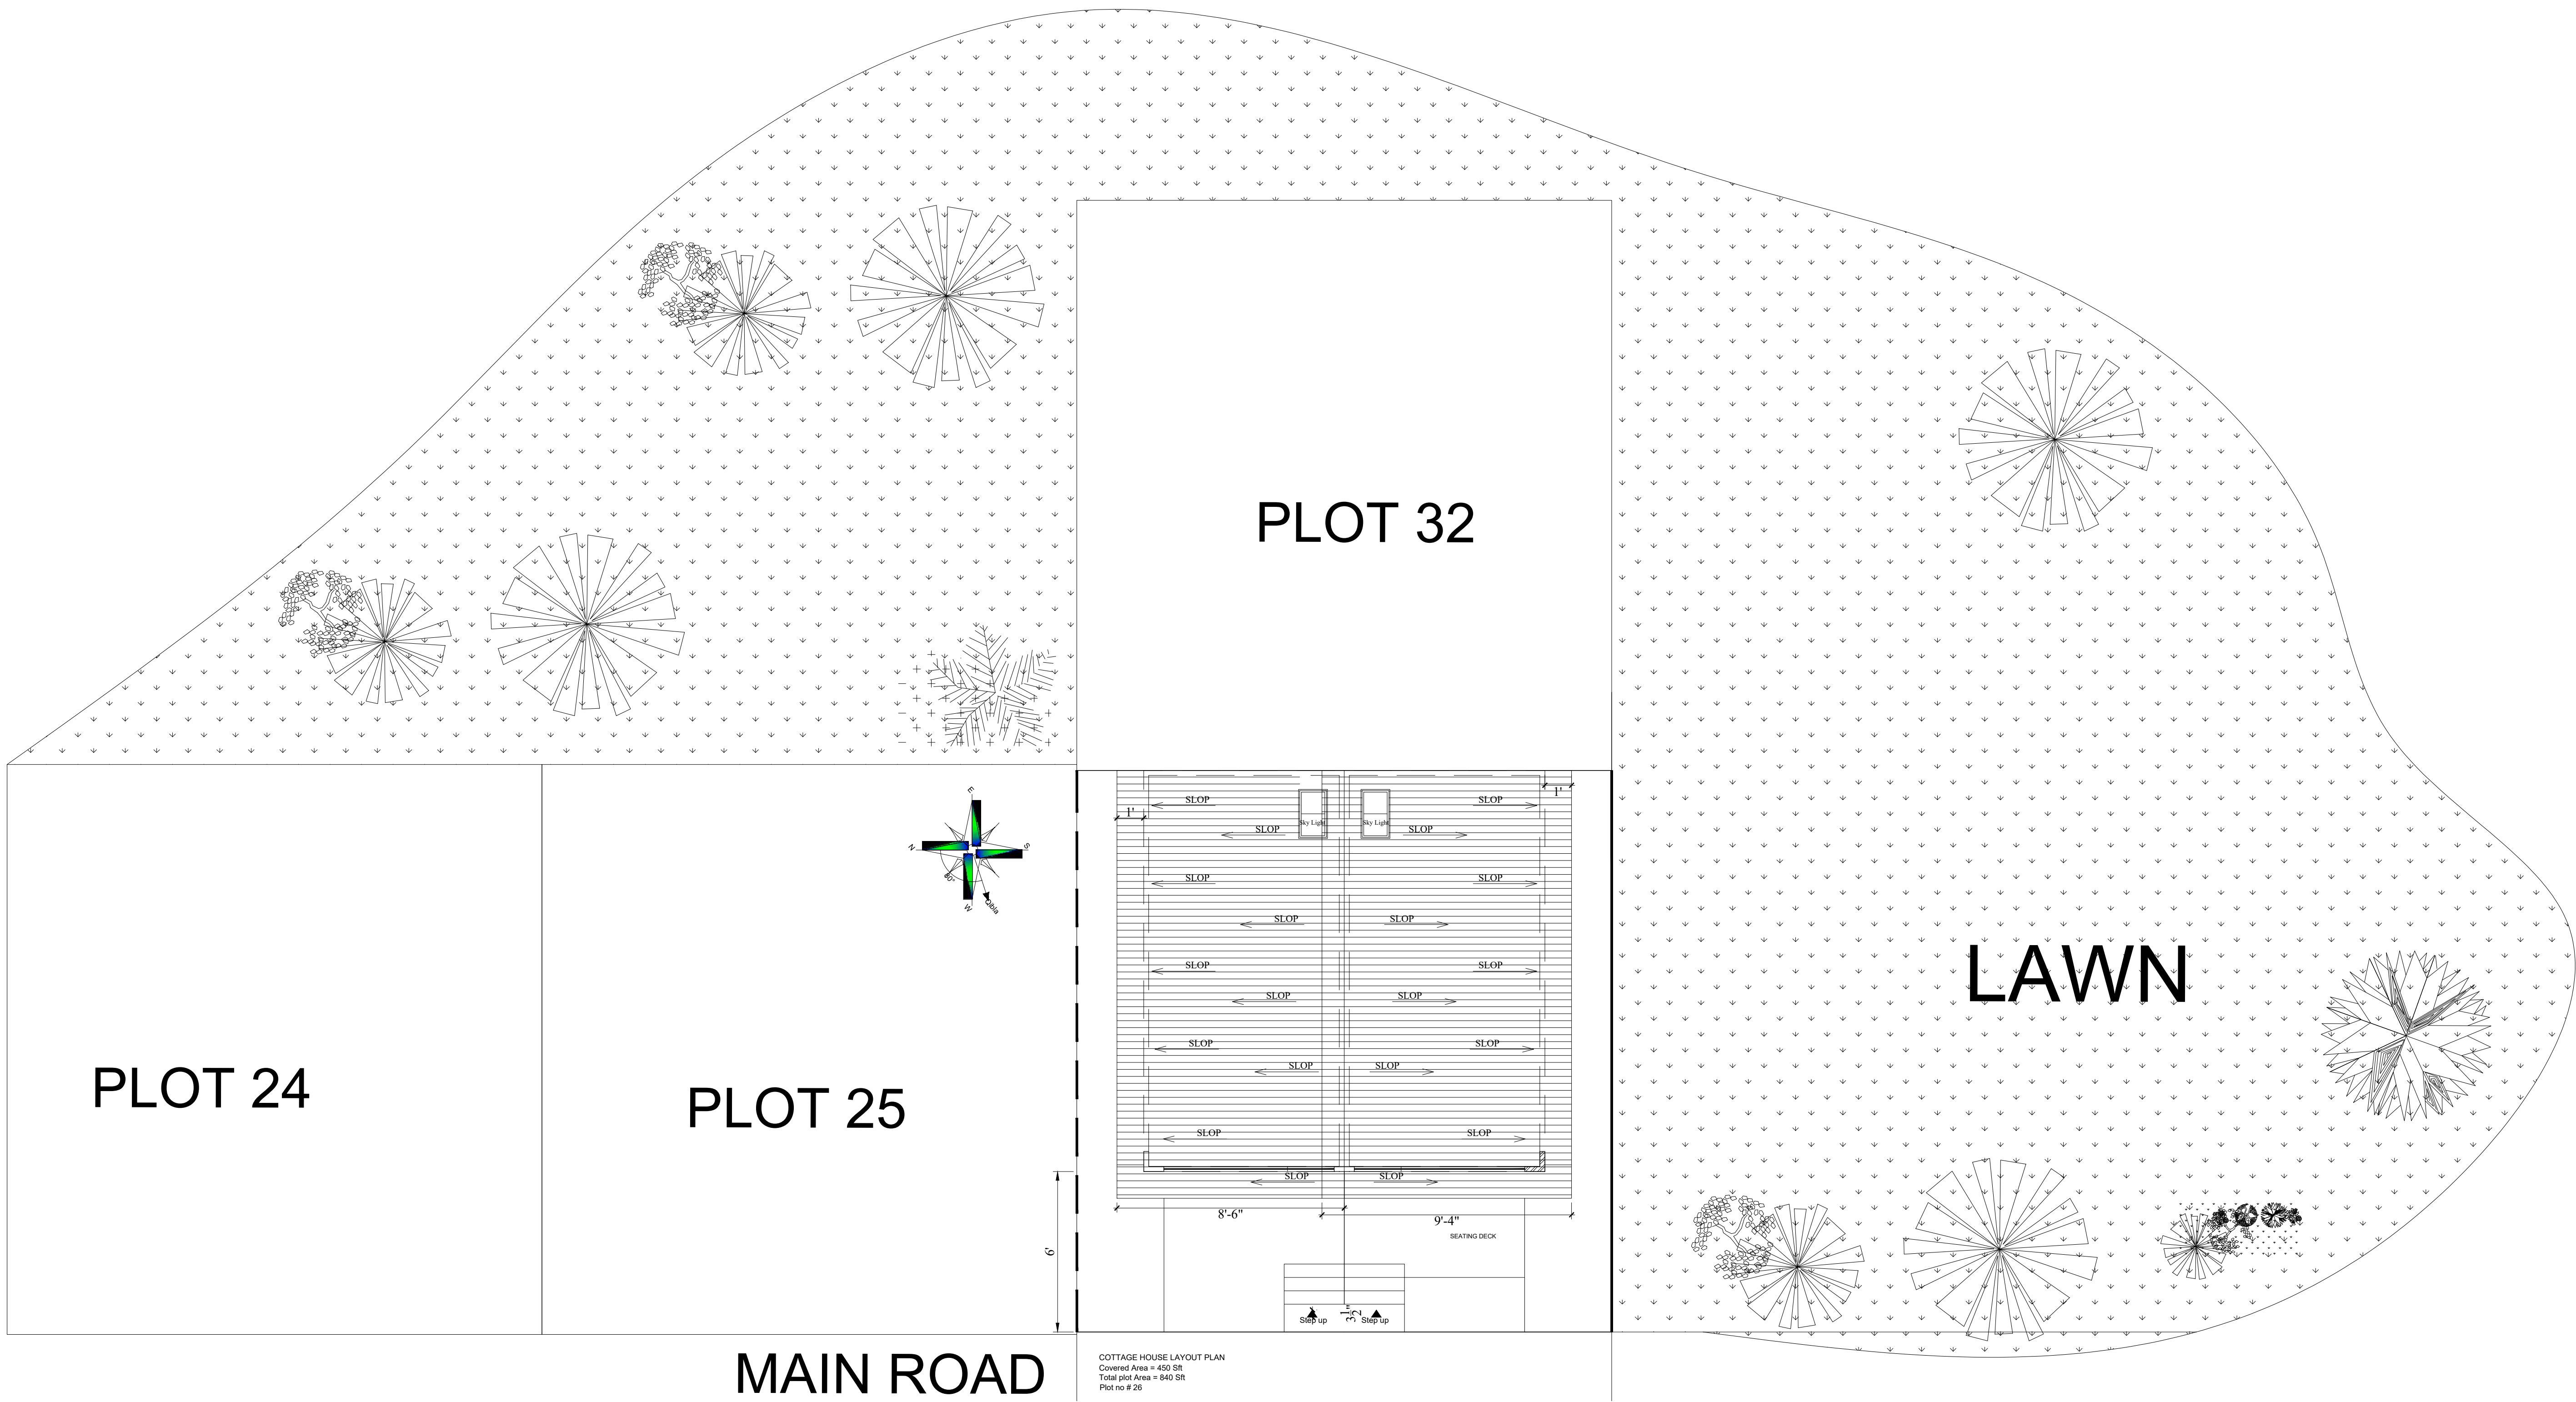

SITE PLAN
SCALE = N.T.S

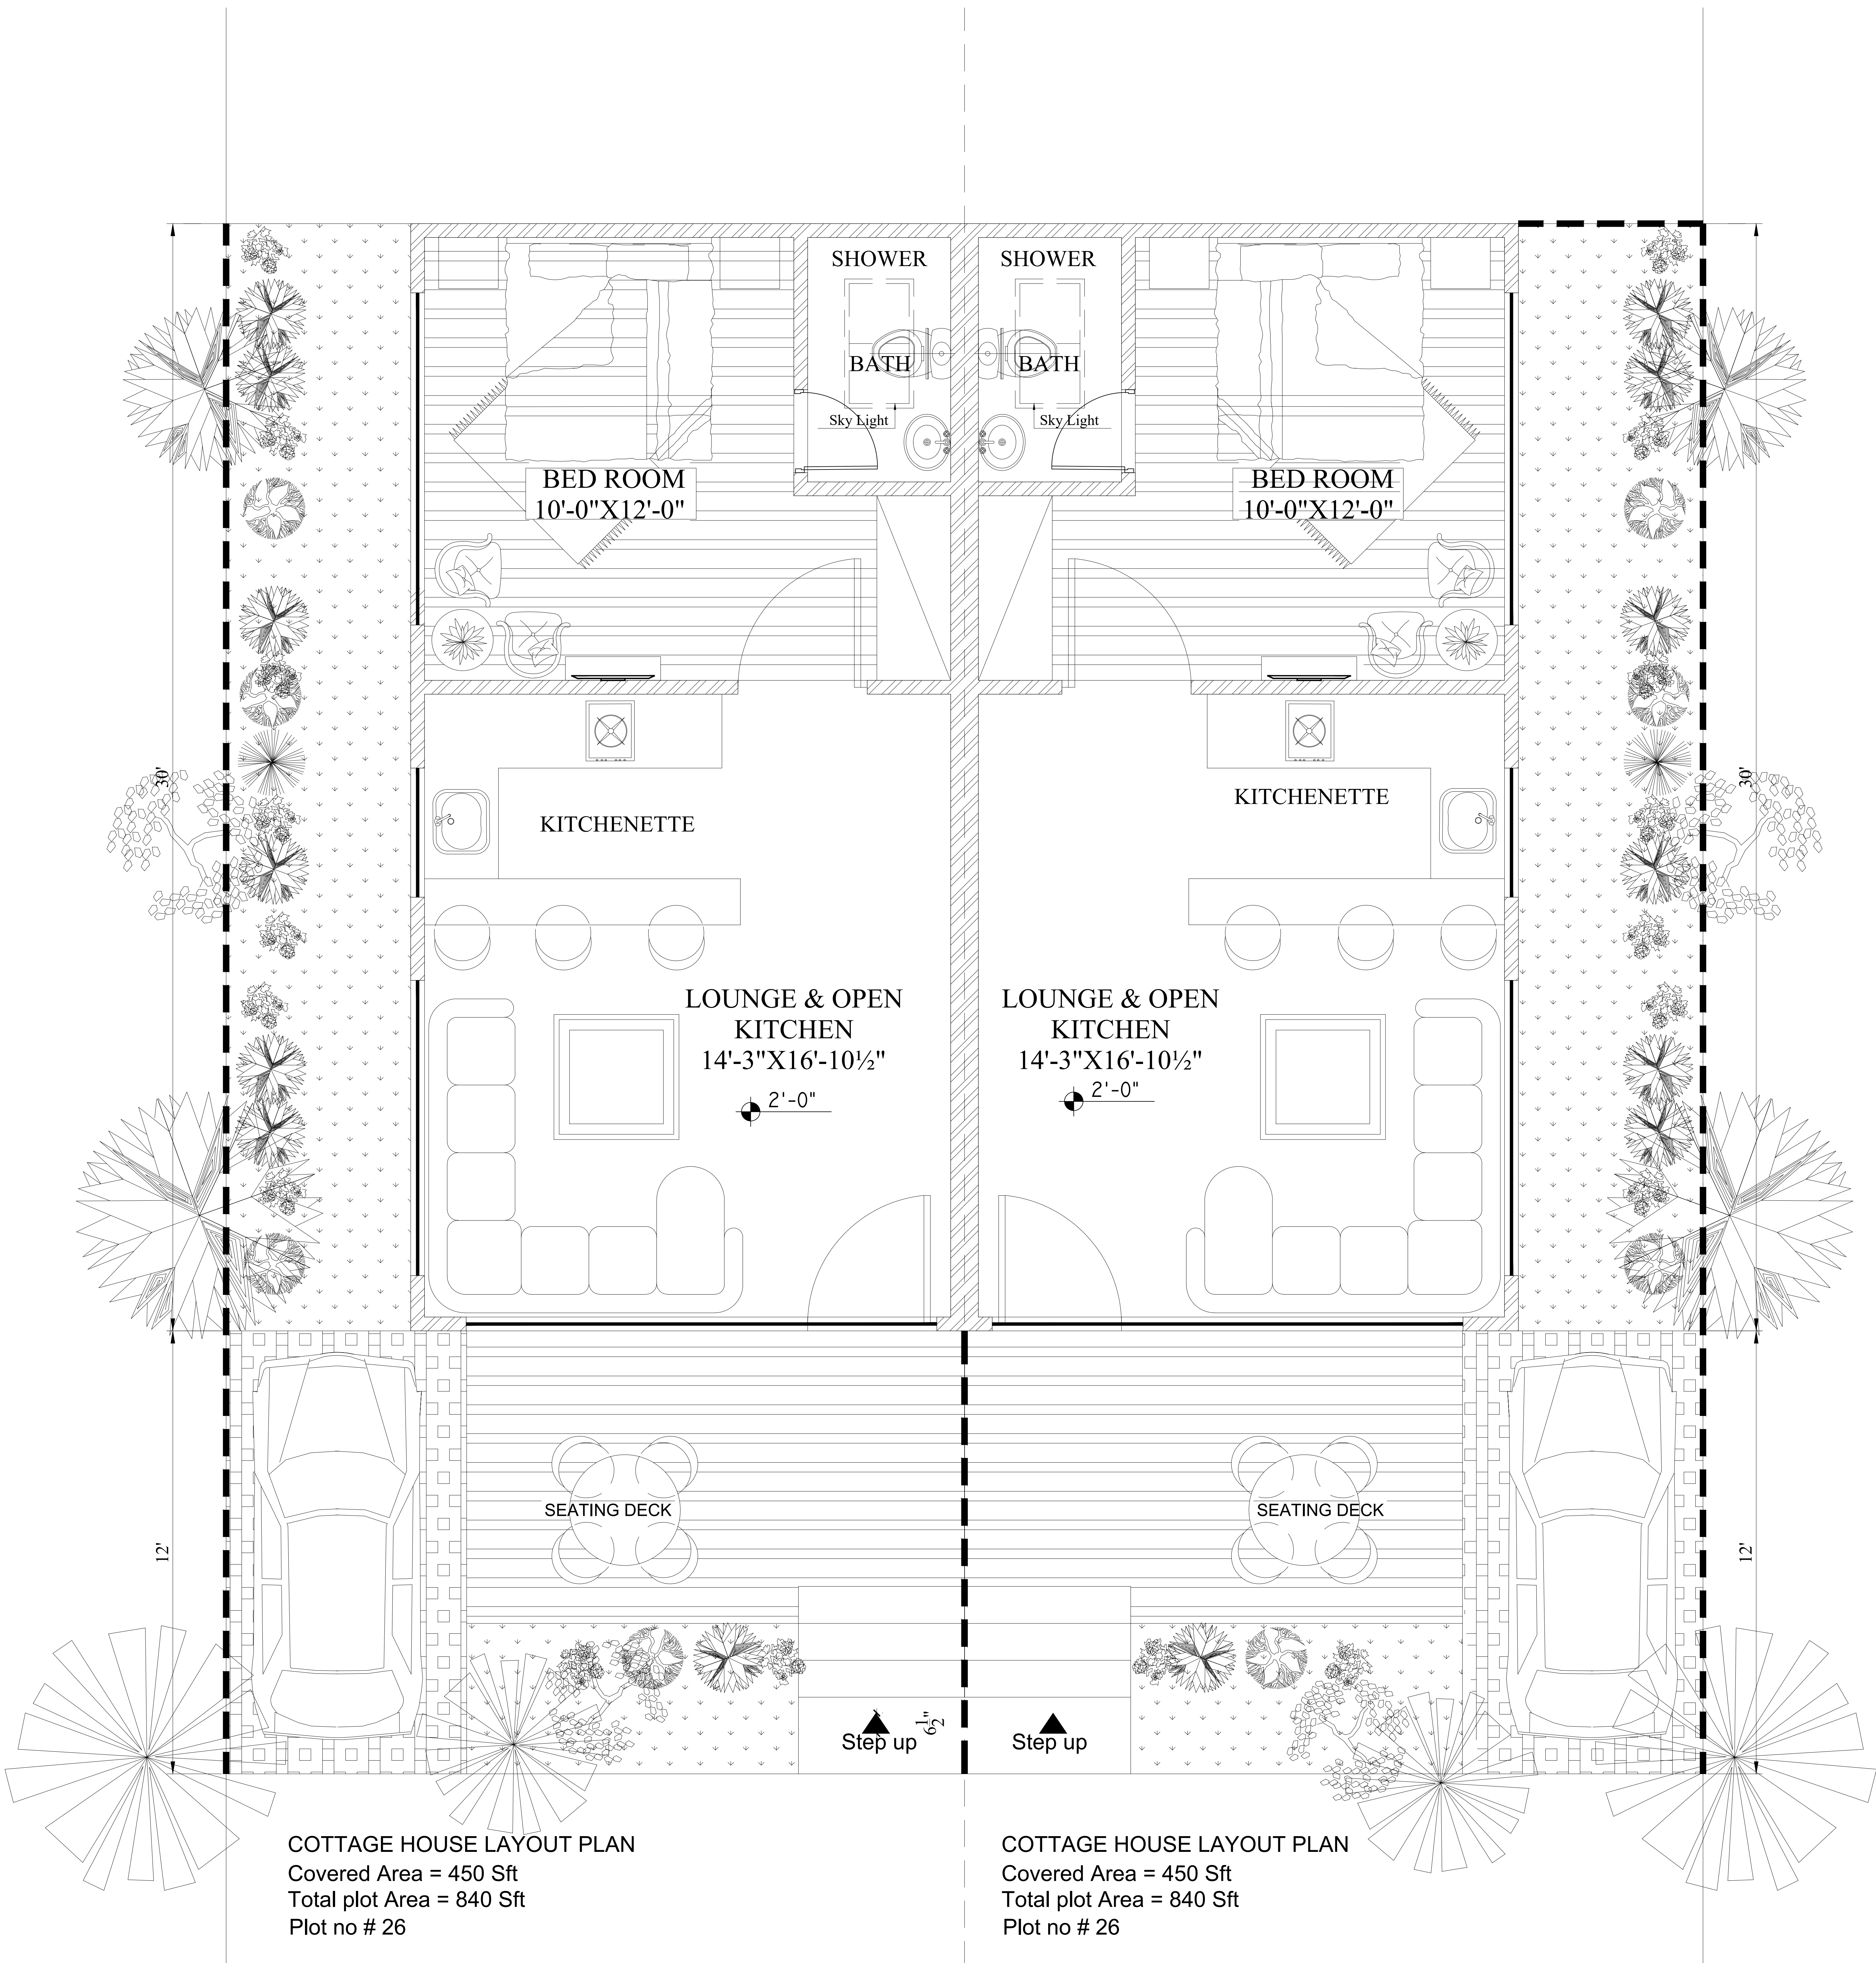

PROPOSAL DRAWINGS

F.F.E LAYOUT PLAN
GROUND FLOOR

PAGE NO.

07

DRAWING NO.

AR-06

DESIGN BY:

Aqib ali

CLIENT:

PROJECT :


MURREE COTTAGE HOUSE

DRAWN BY:


Eshan

DATE:


23.08.2024

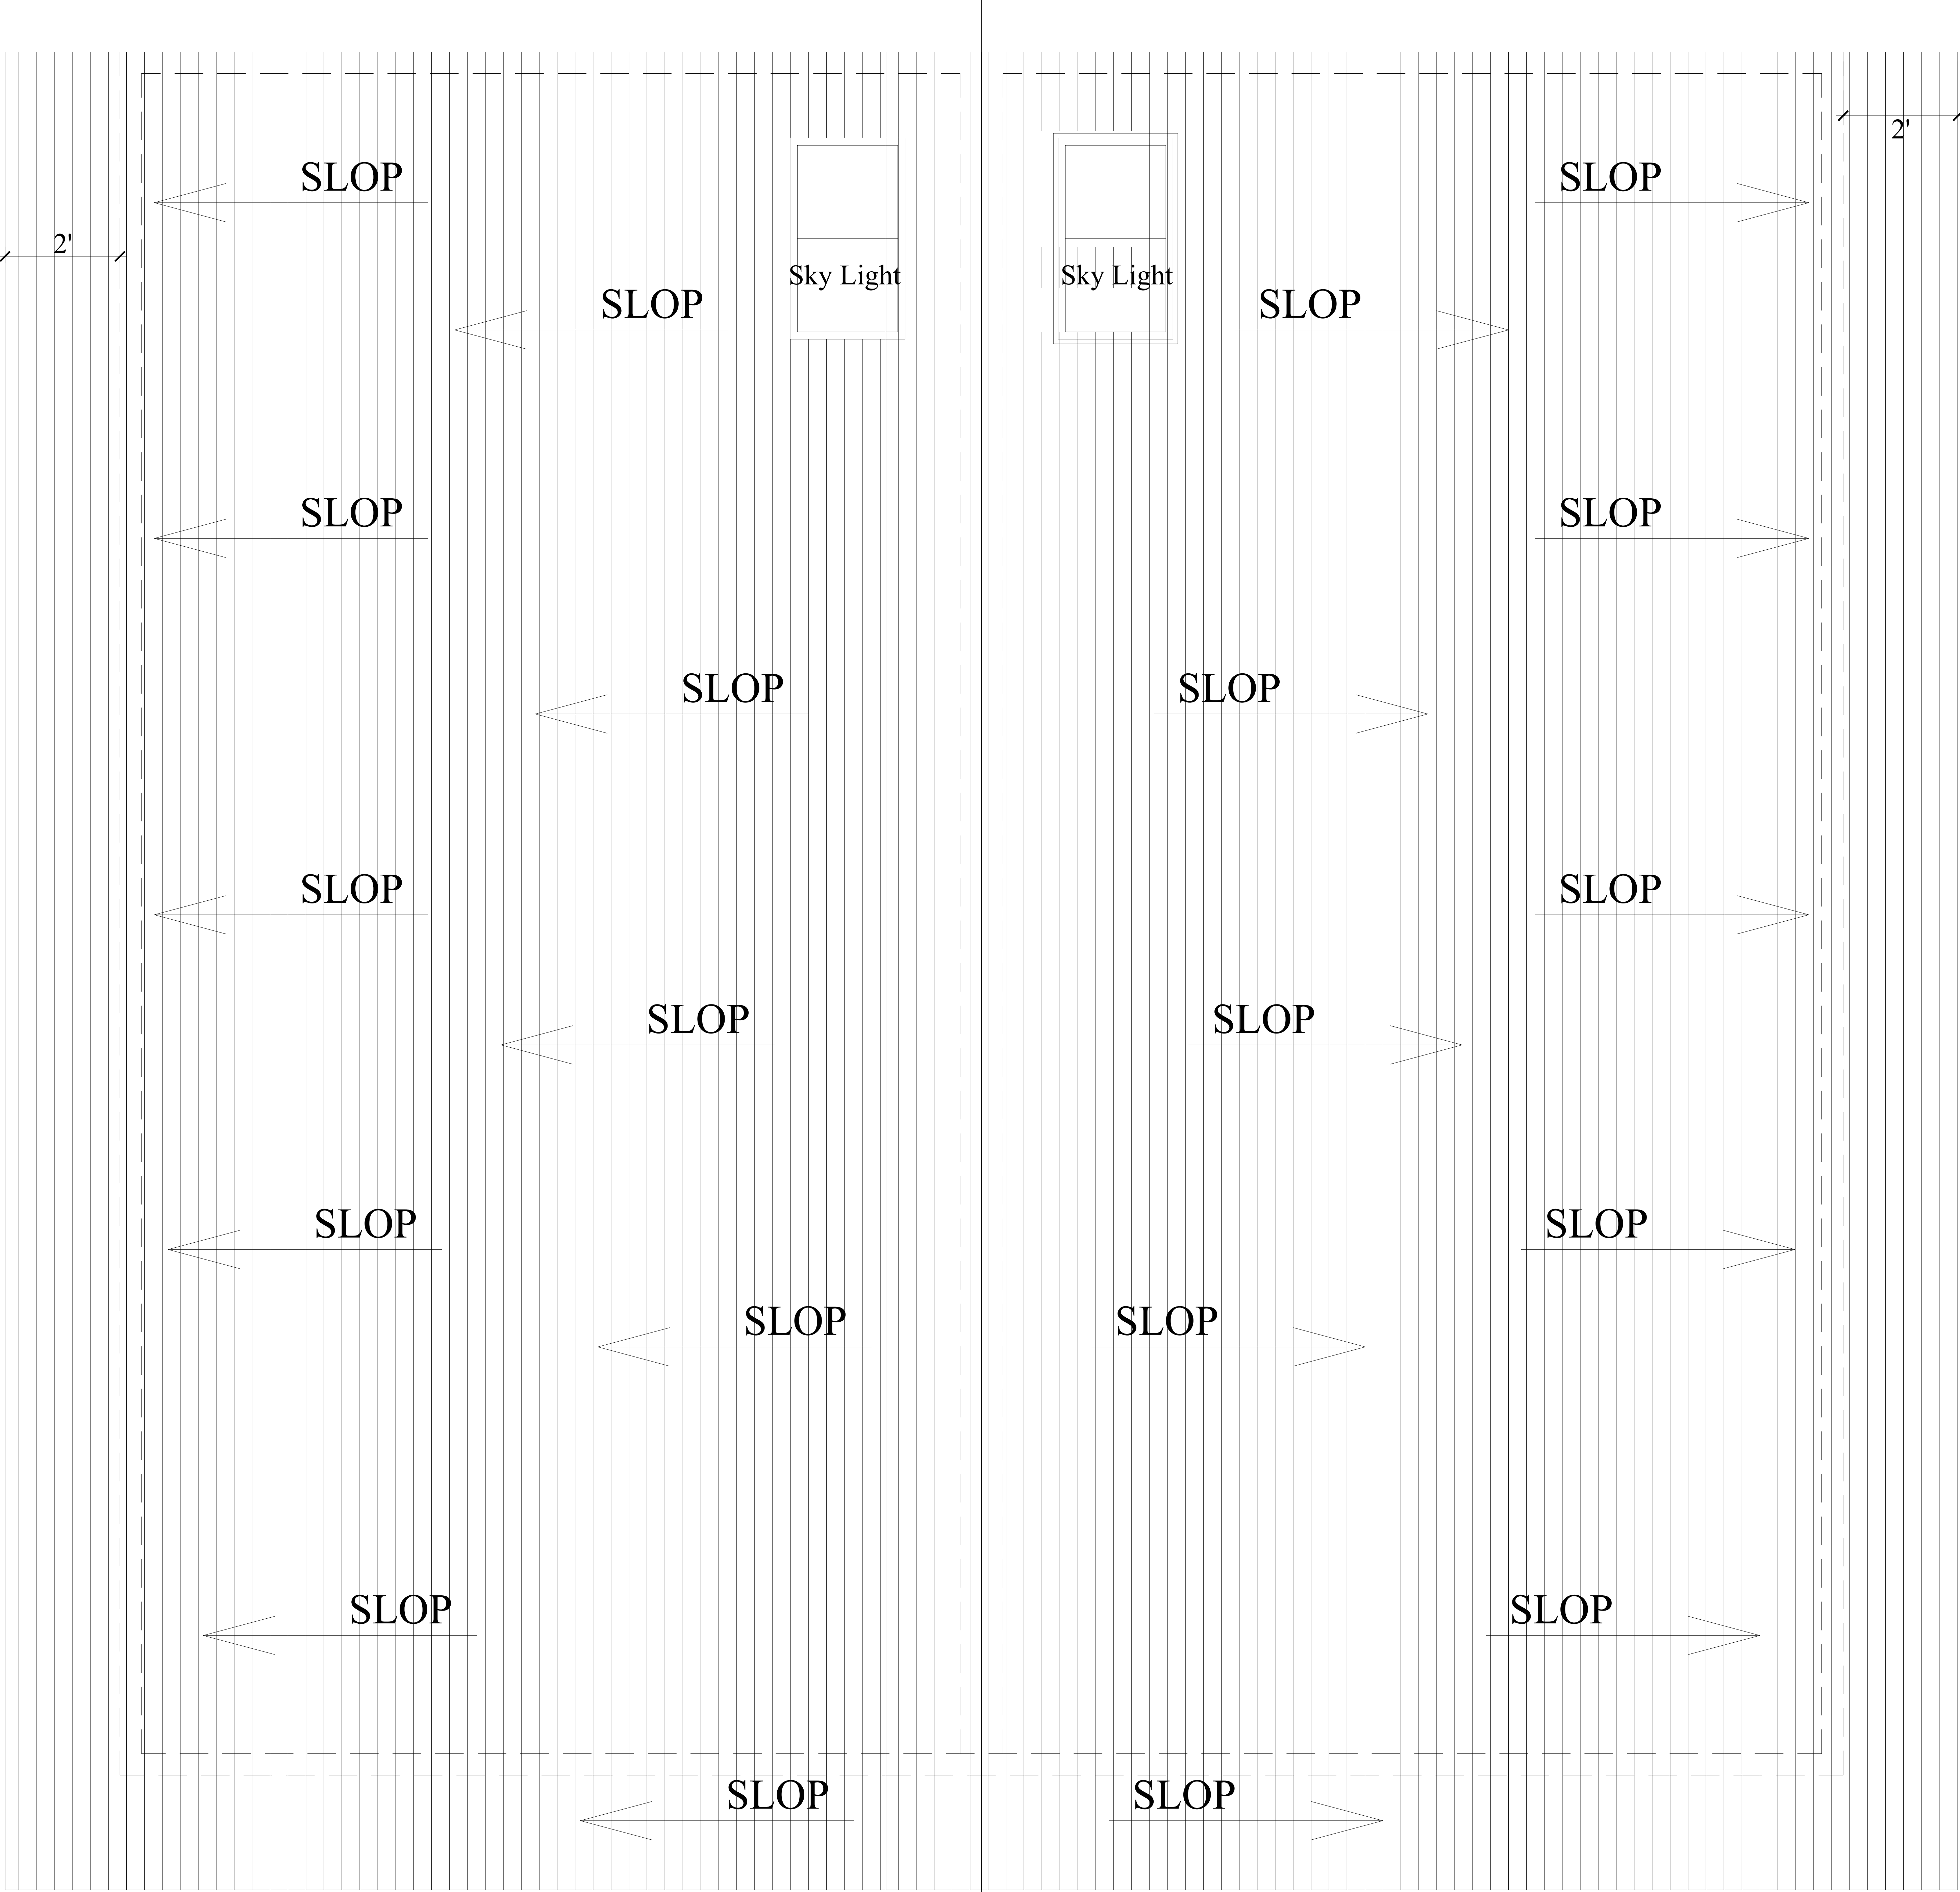


TOP ROOF PLAN

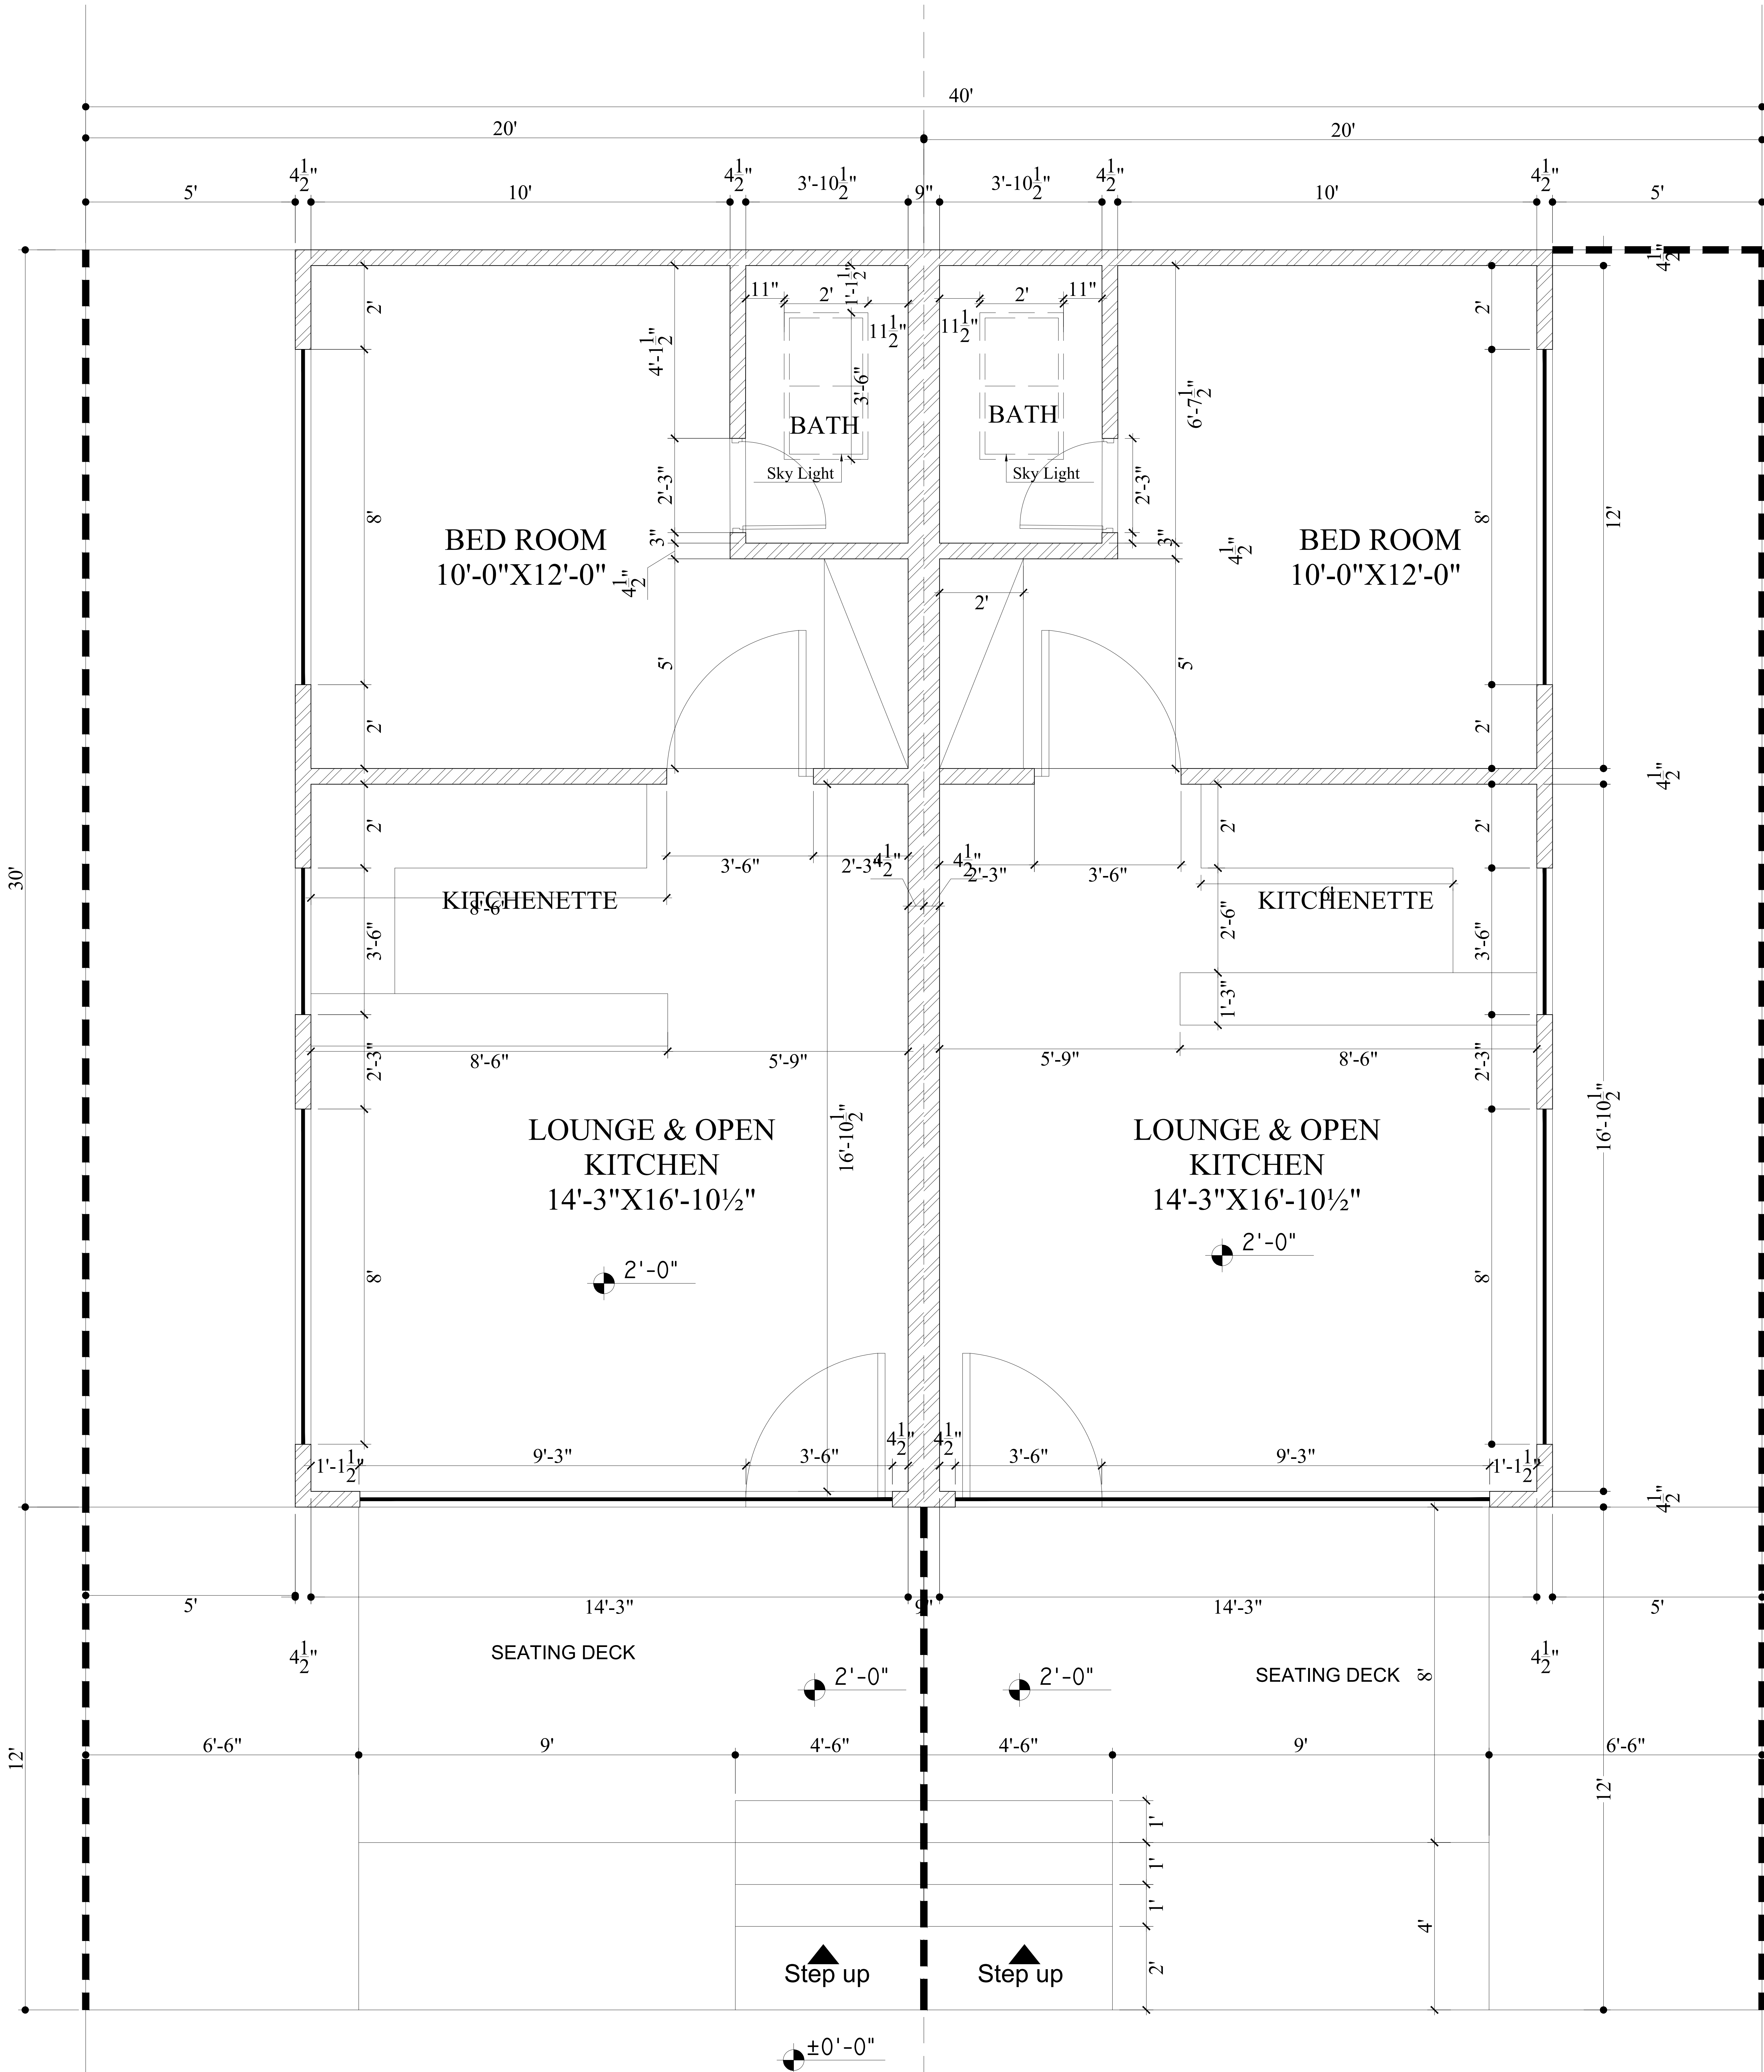


COTTAGE HOUSE LAYOUT PLAN
Covered Area = 450 Sft
Total plot Area = 840 Sft
Plot no # 26

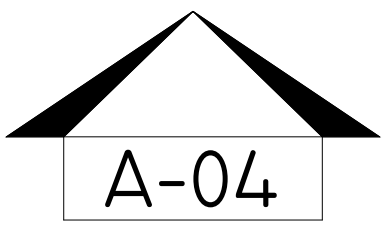

COTTAGE HOUSE LAYOUT PLAN
Covered Area = 450 Sft
Total plot Area = 840 Sft
Plot no # 26

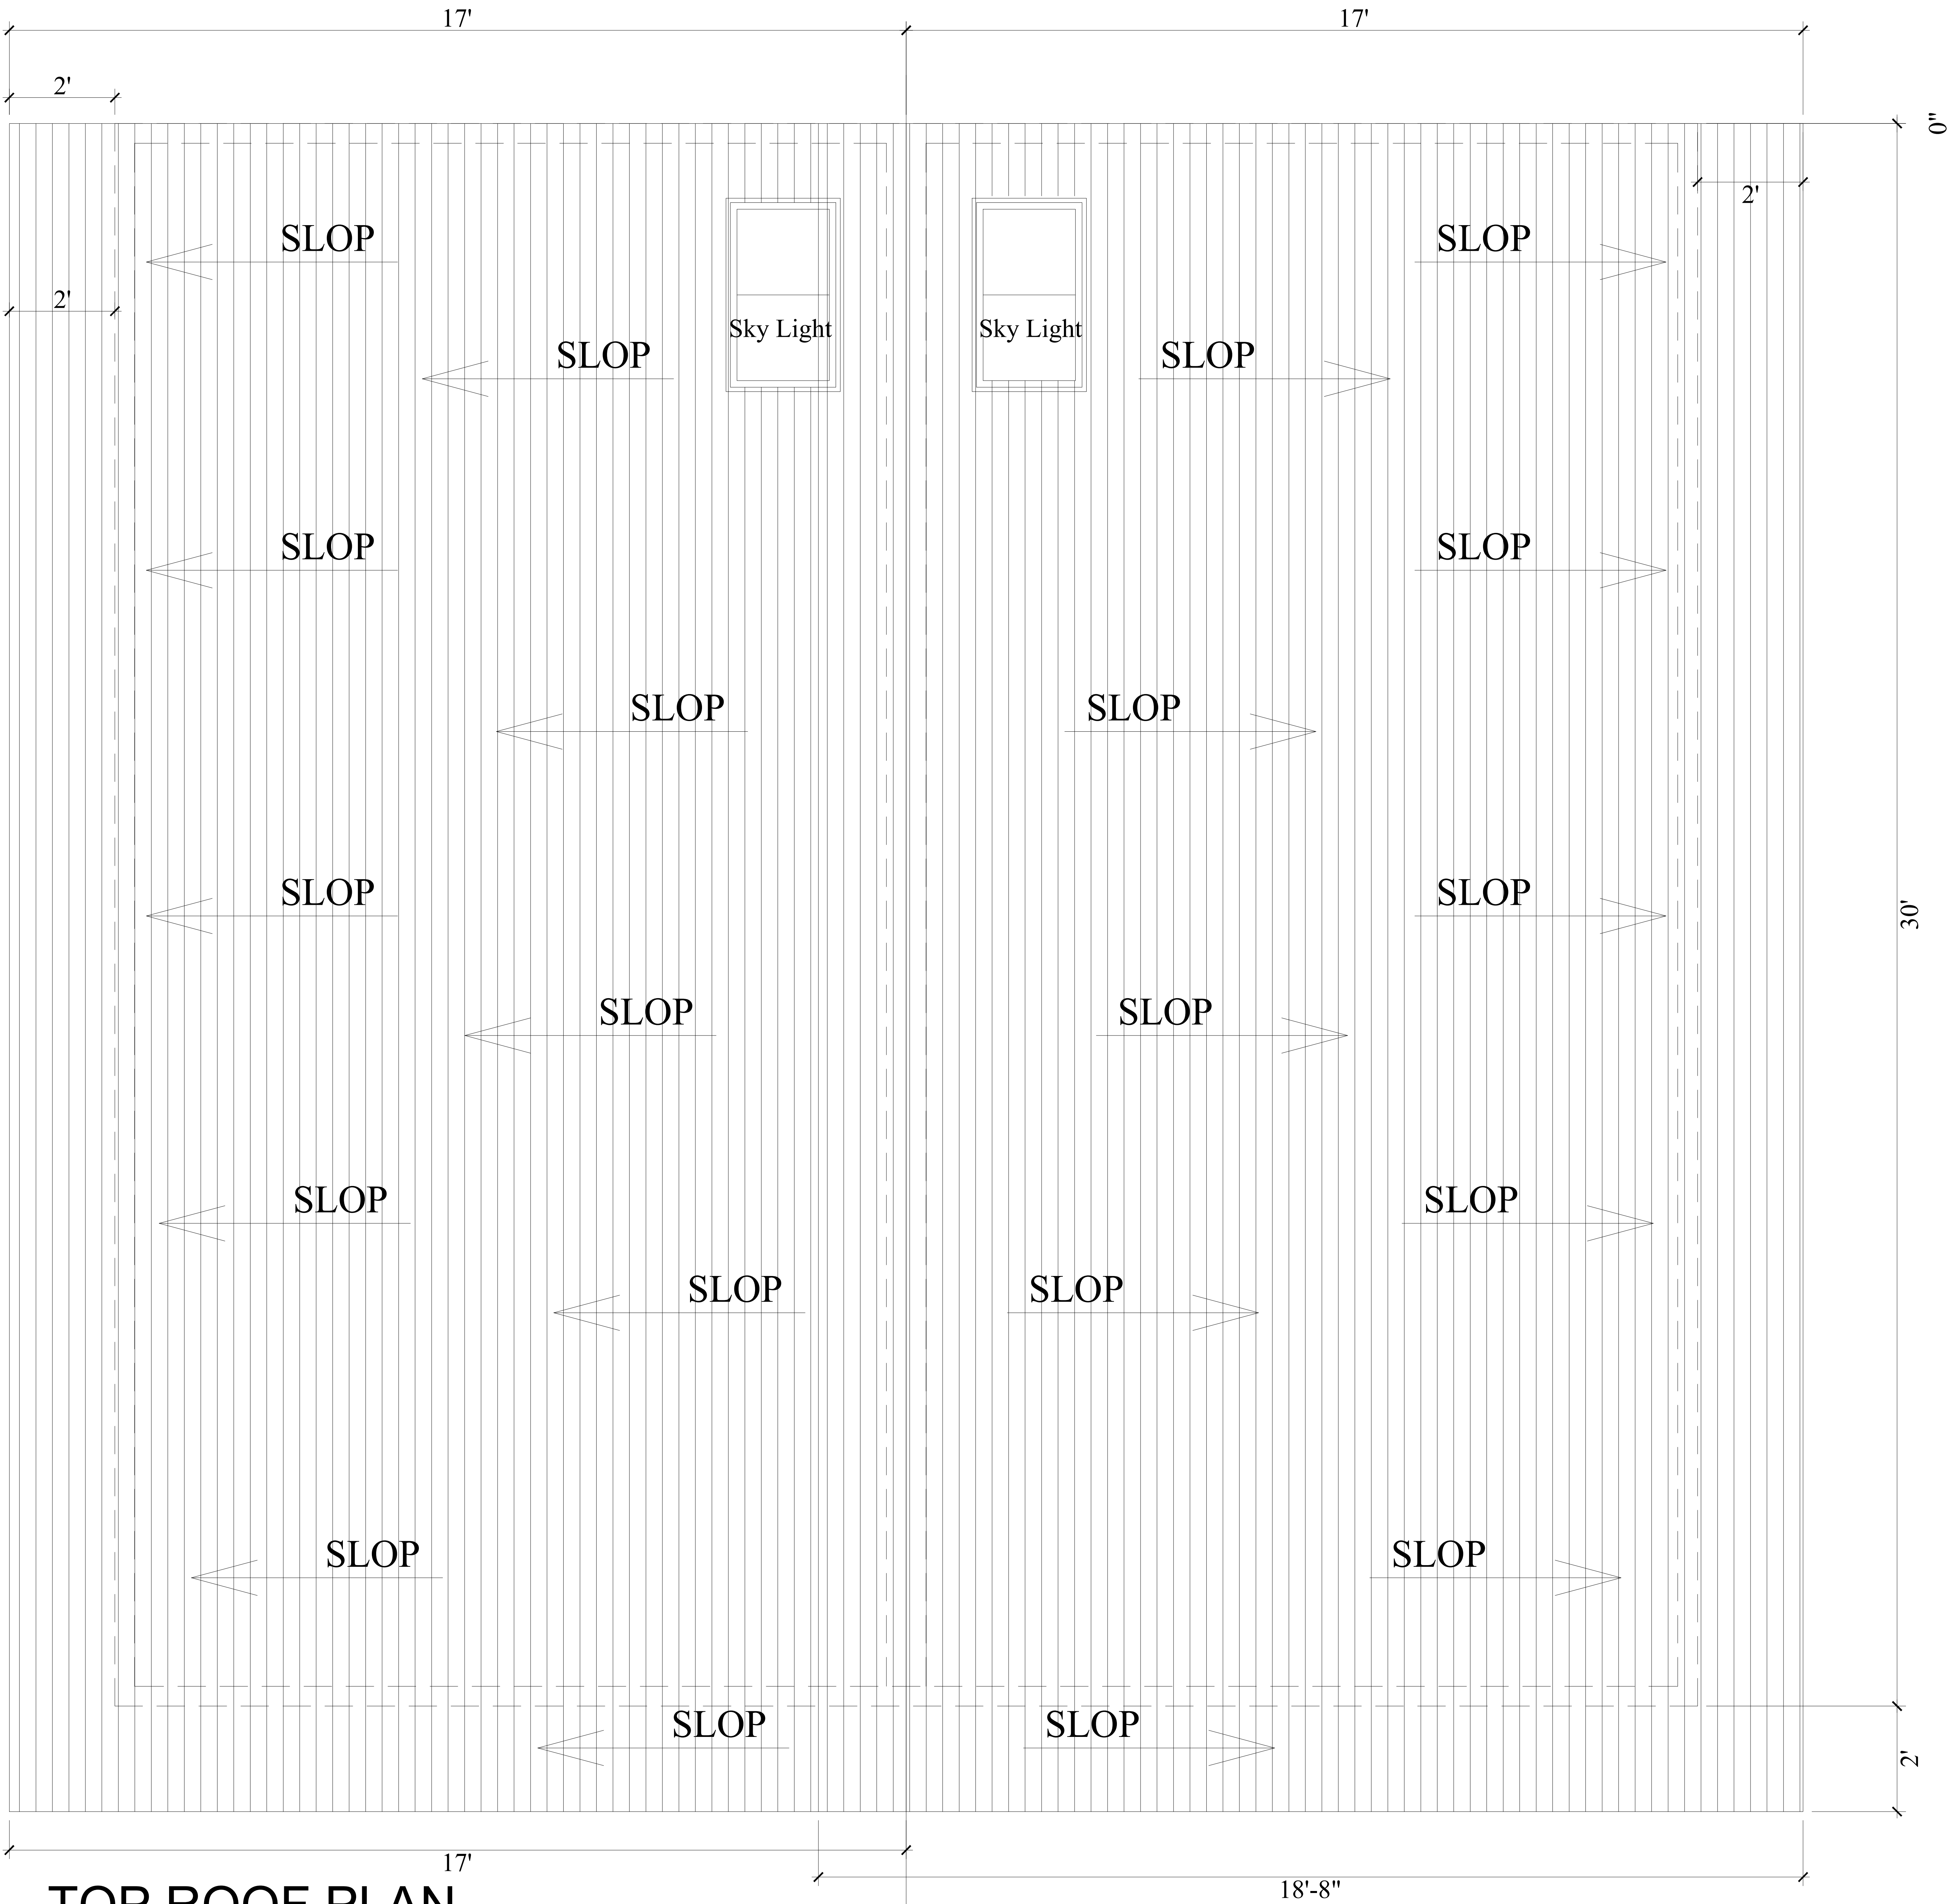


TOP ROOF PLAN

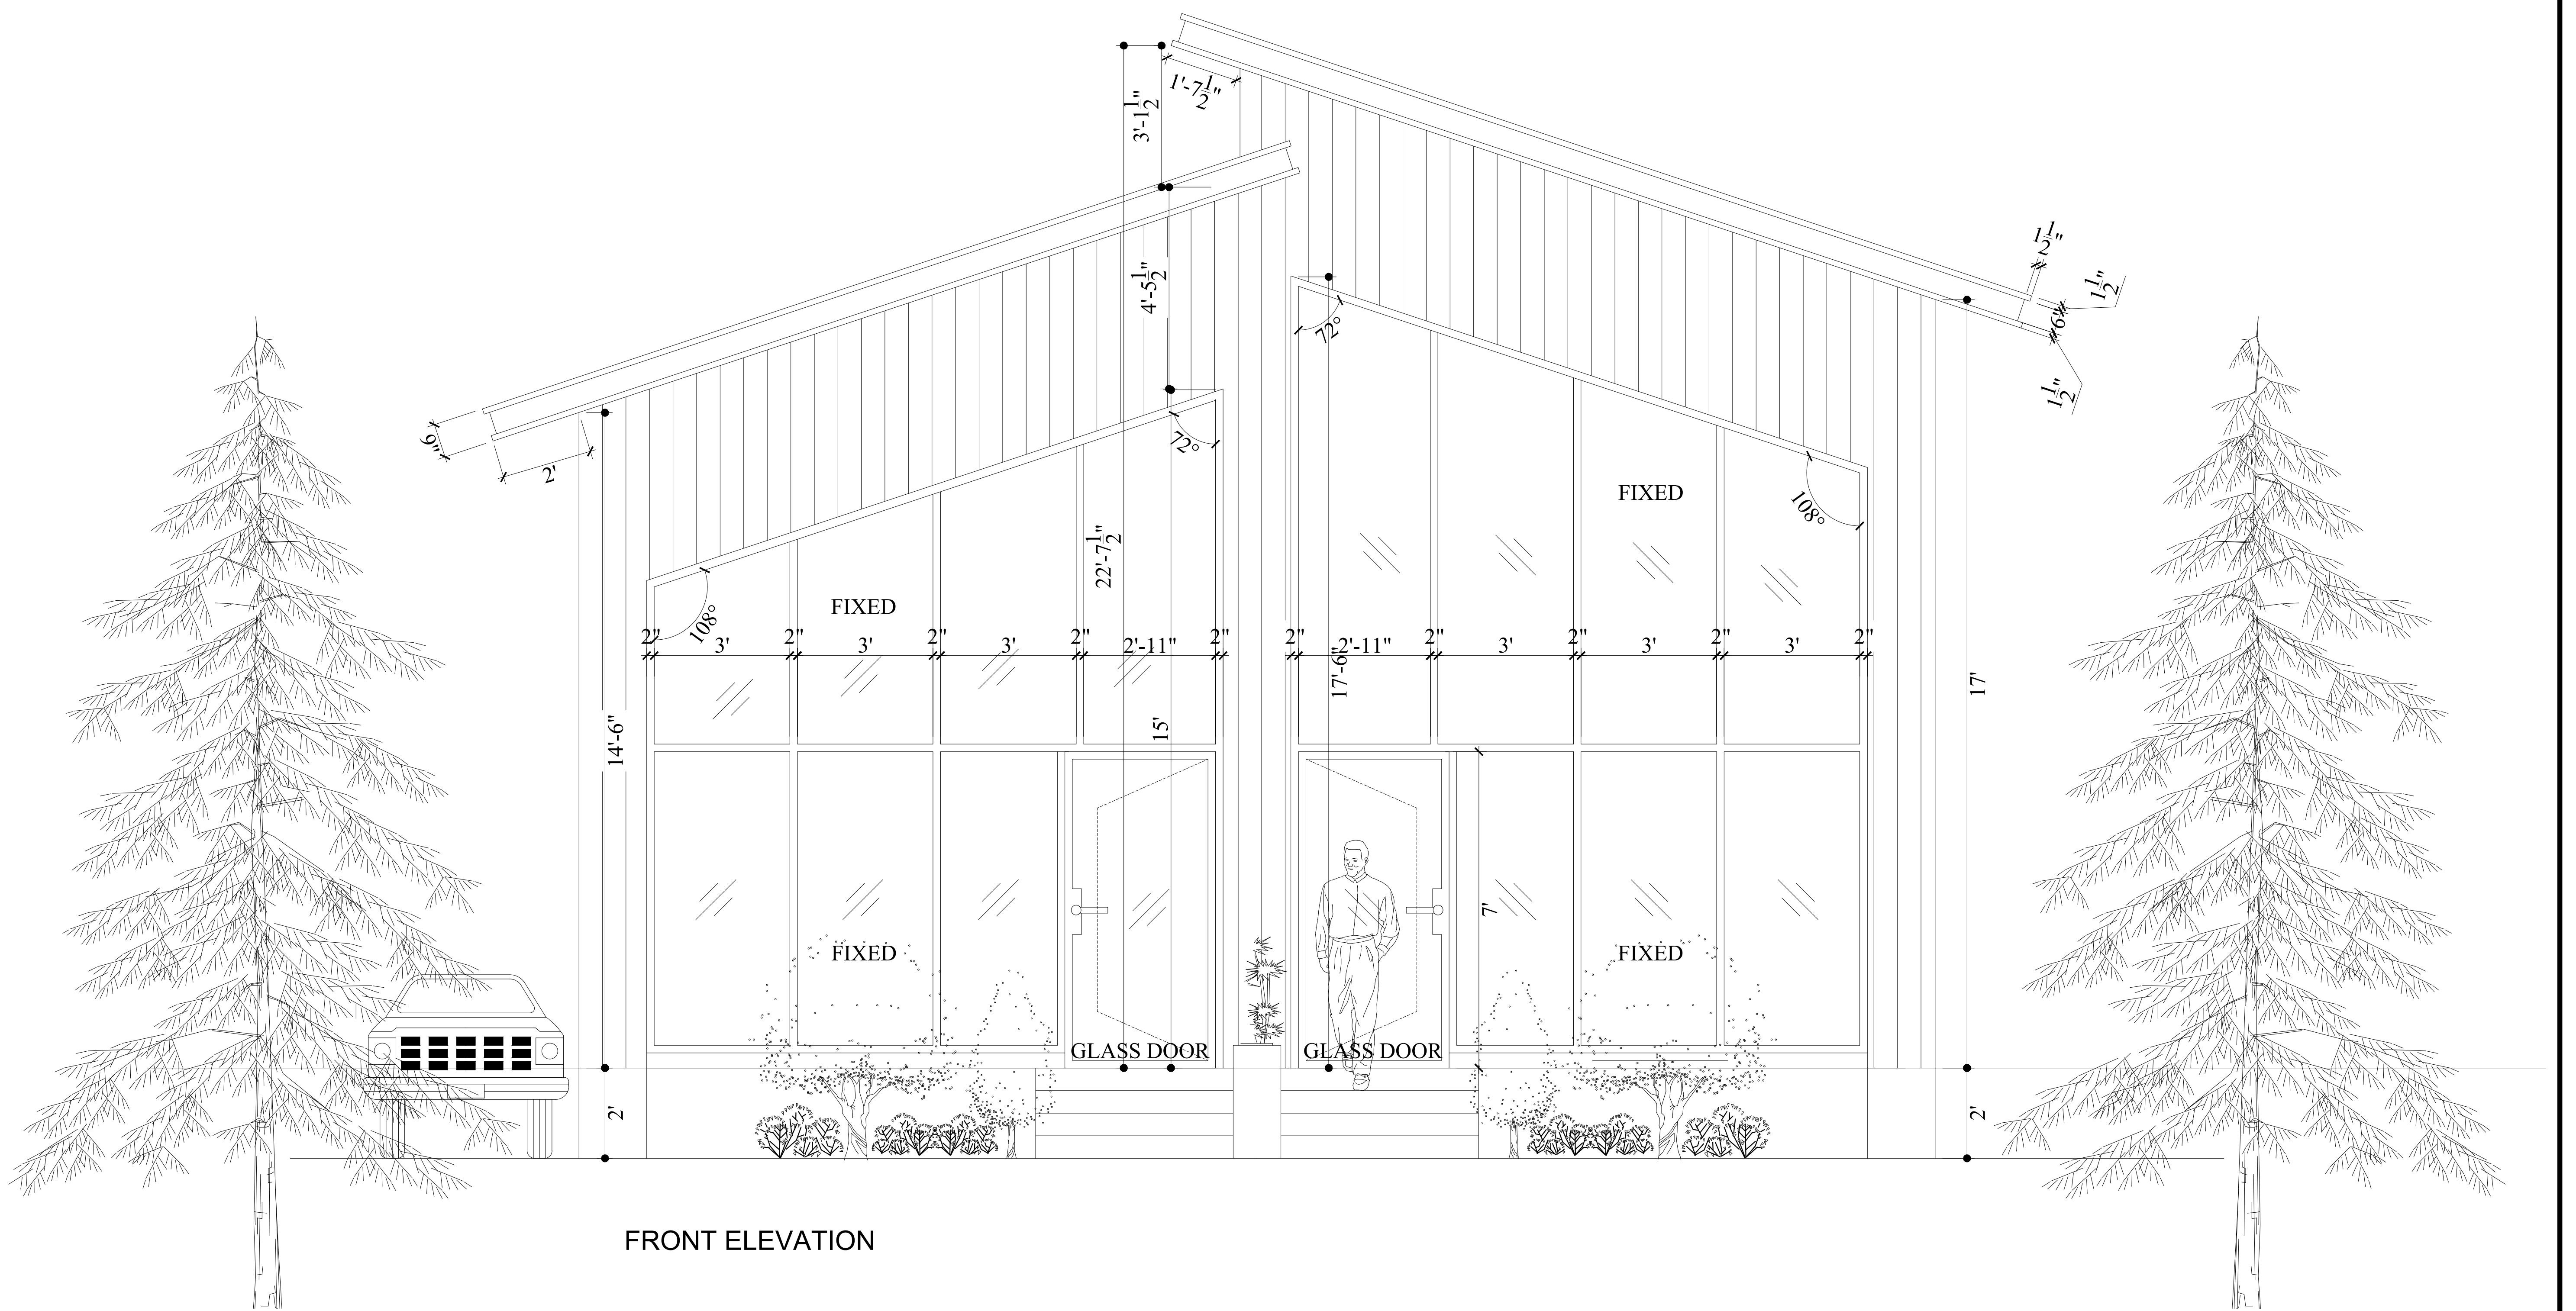


NOTE: Brick Will be used in all Construction Villas.
And for top roof structure we will use m.s corrugated sheet +Wooden beam.

PROPOSAL DRAWINGS FRONT ELEVATION	PAGE NO.	11	DRAWING NO.	AR-10	DESIGN BY:	Aqib ali
	CLIENT:	_____	PROJECT :	MURREE COTTAGE HOUSE	DRAWN BY:	Eshan
					DATE:	23.08.2024

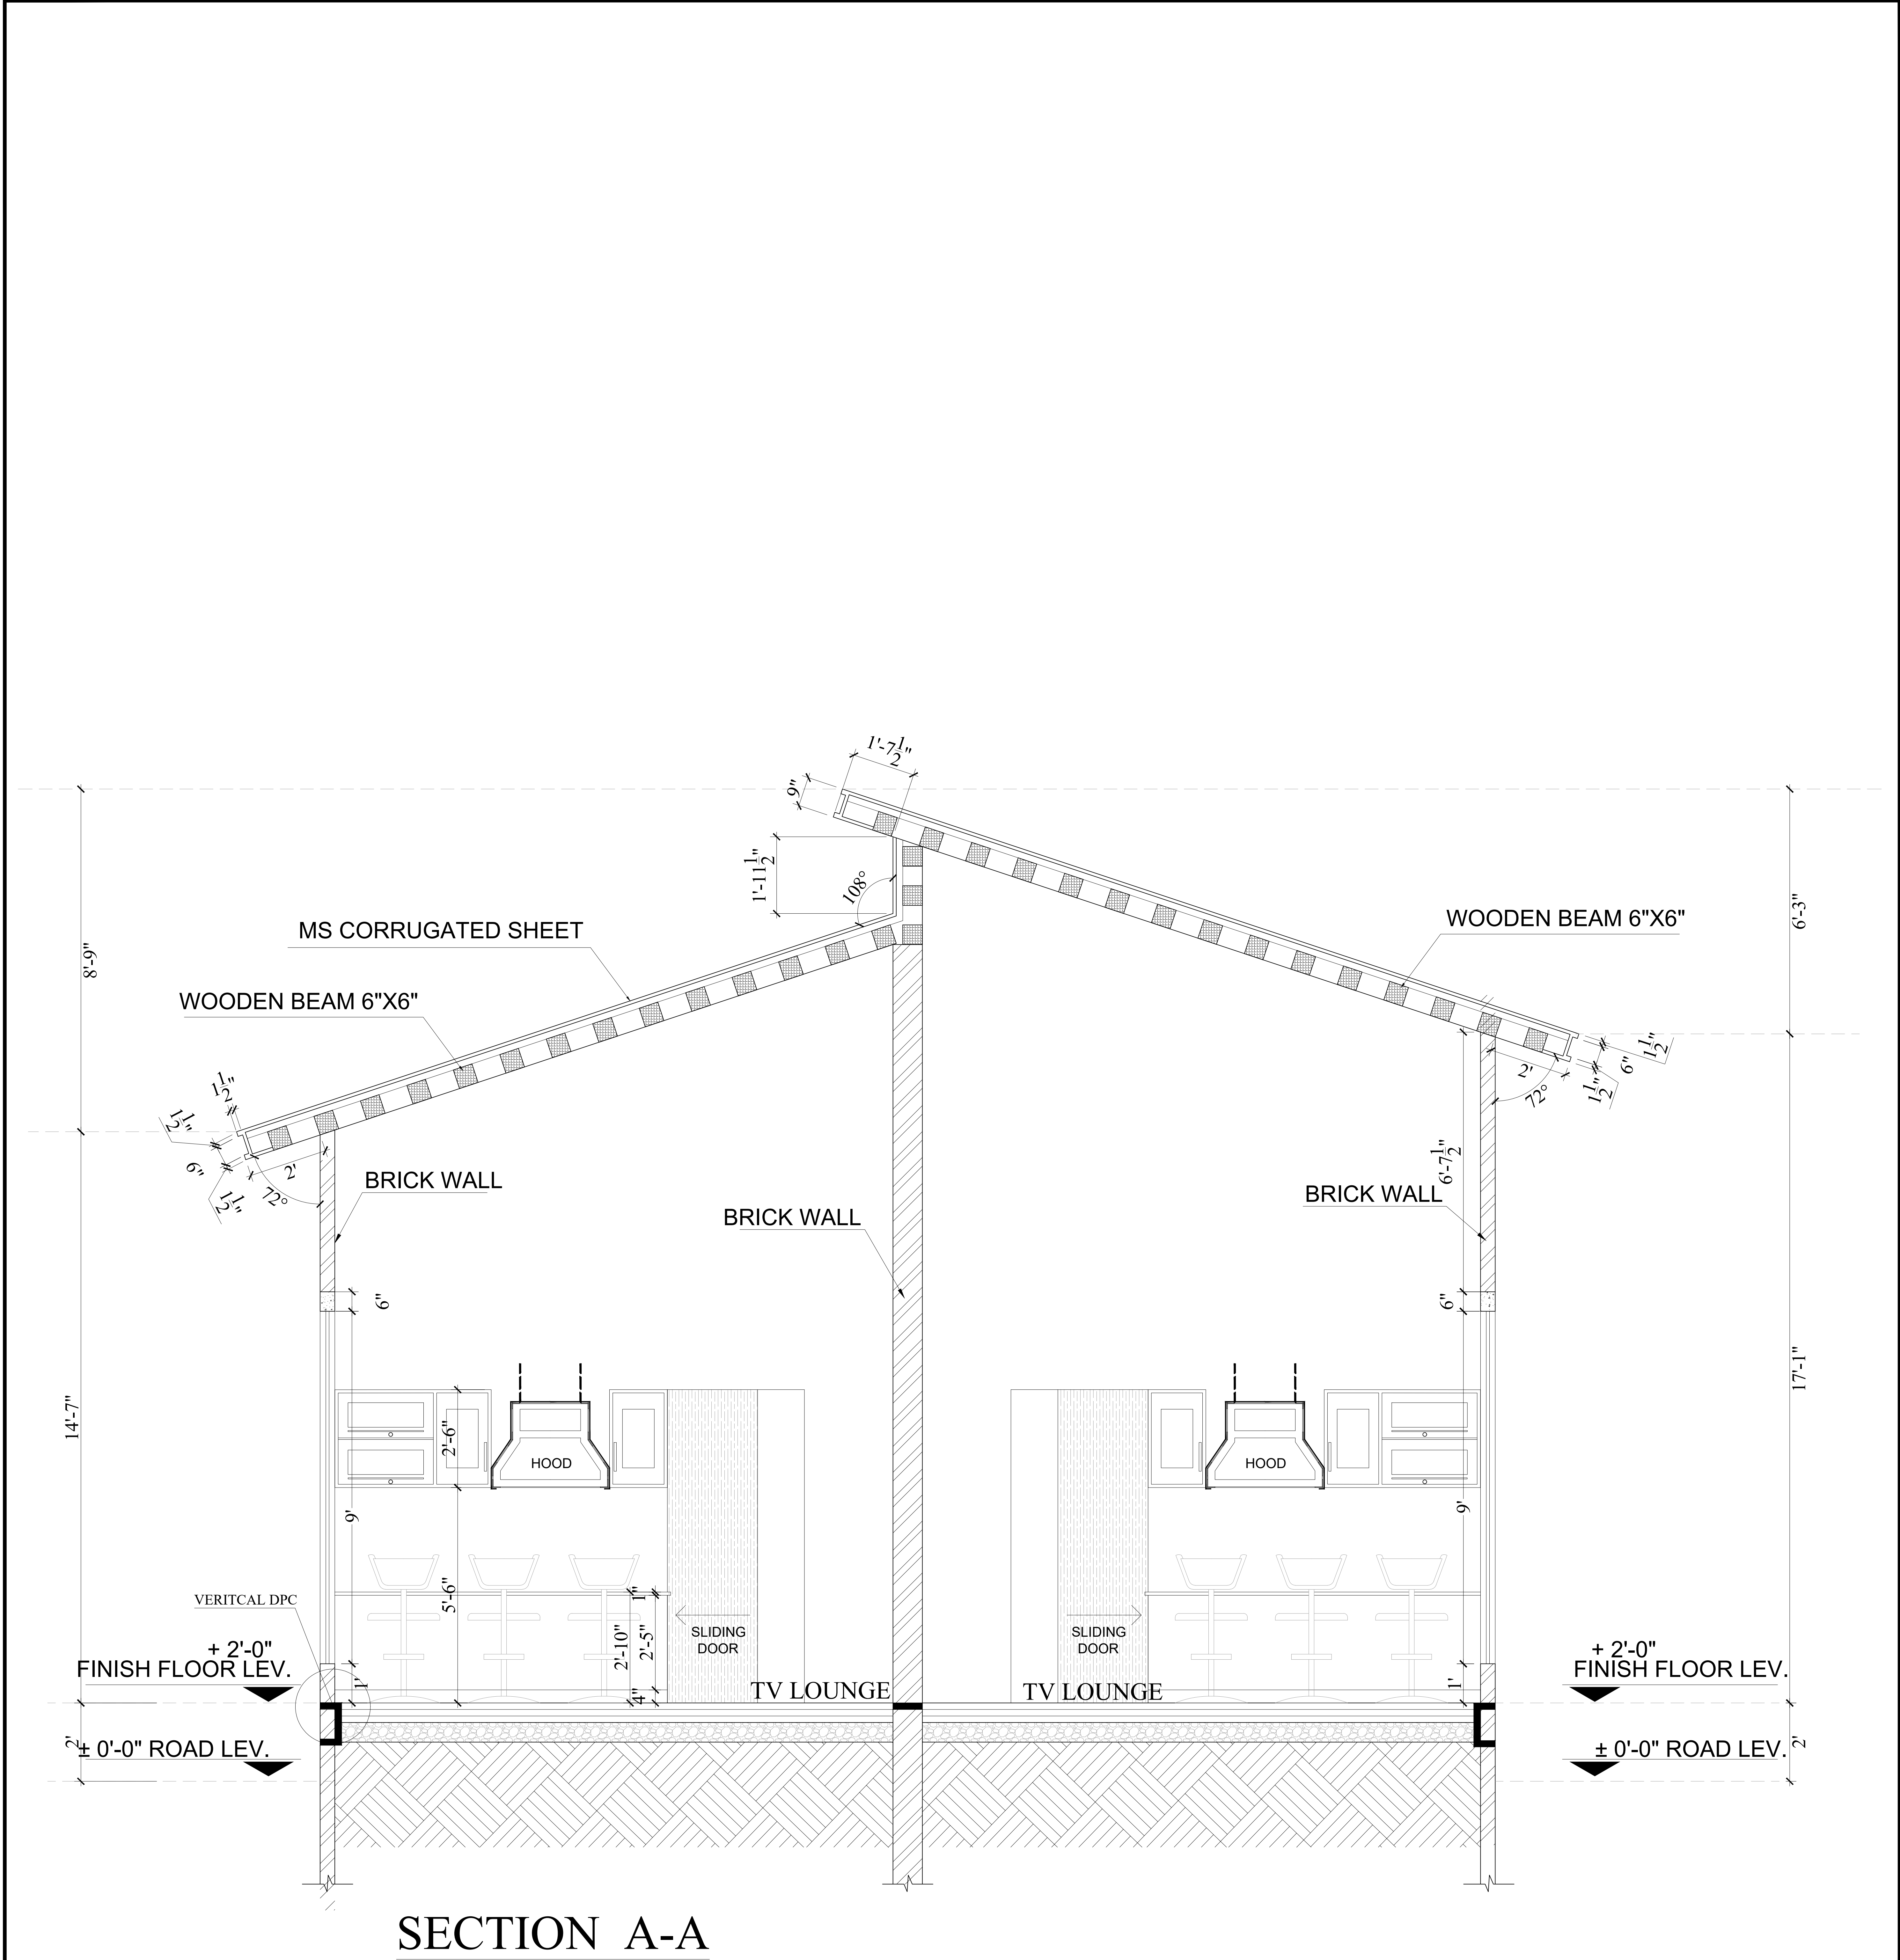


NOTE: Brick Will be used in all Construction Villas.
And for top roof structure we will use m.s corrugated sheet + Wooden beam.

PROPOSAL DRAWINGS SECTION A-A	PAGE NO. 12	DRAWING NO. AR-11	DESIGN BY: Aqib ali
	CLIENT: _____	PROJECT : MURREE COTTAGE HOUSE	DRAWN BY: Eshan
			DATE: 23.08.2024

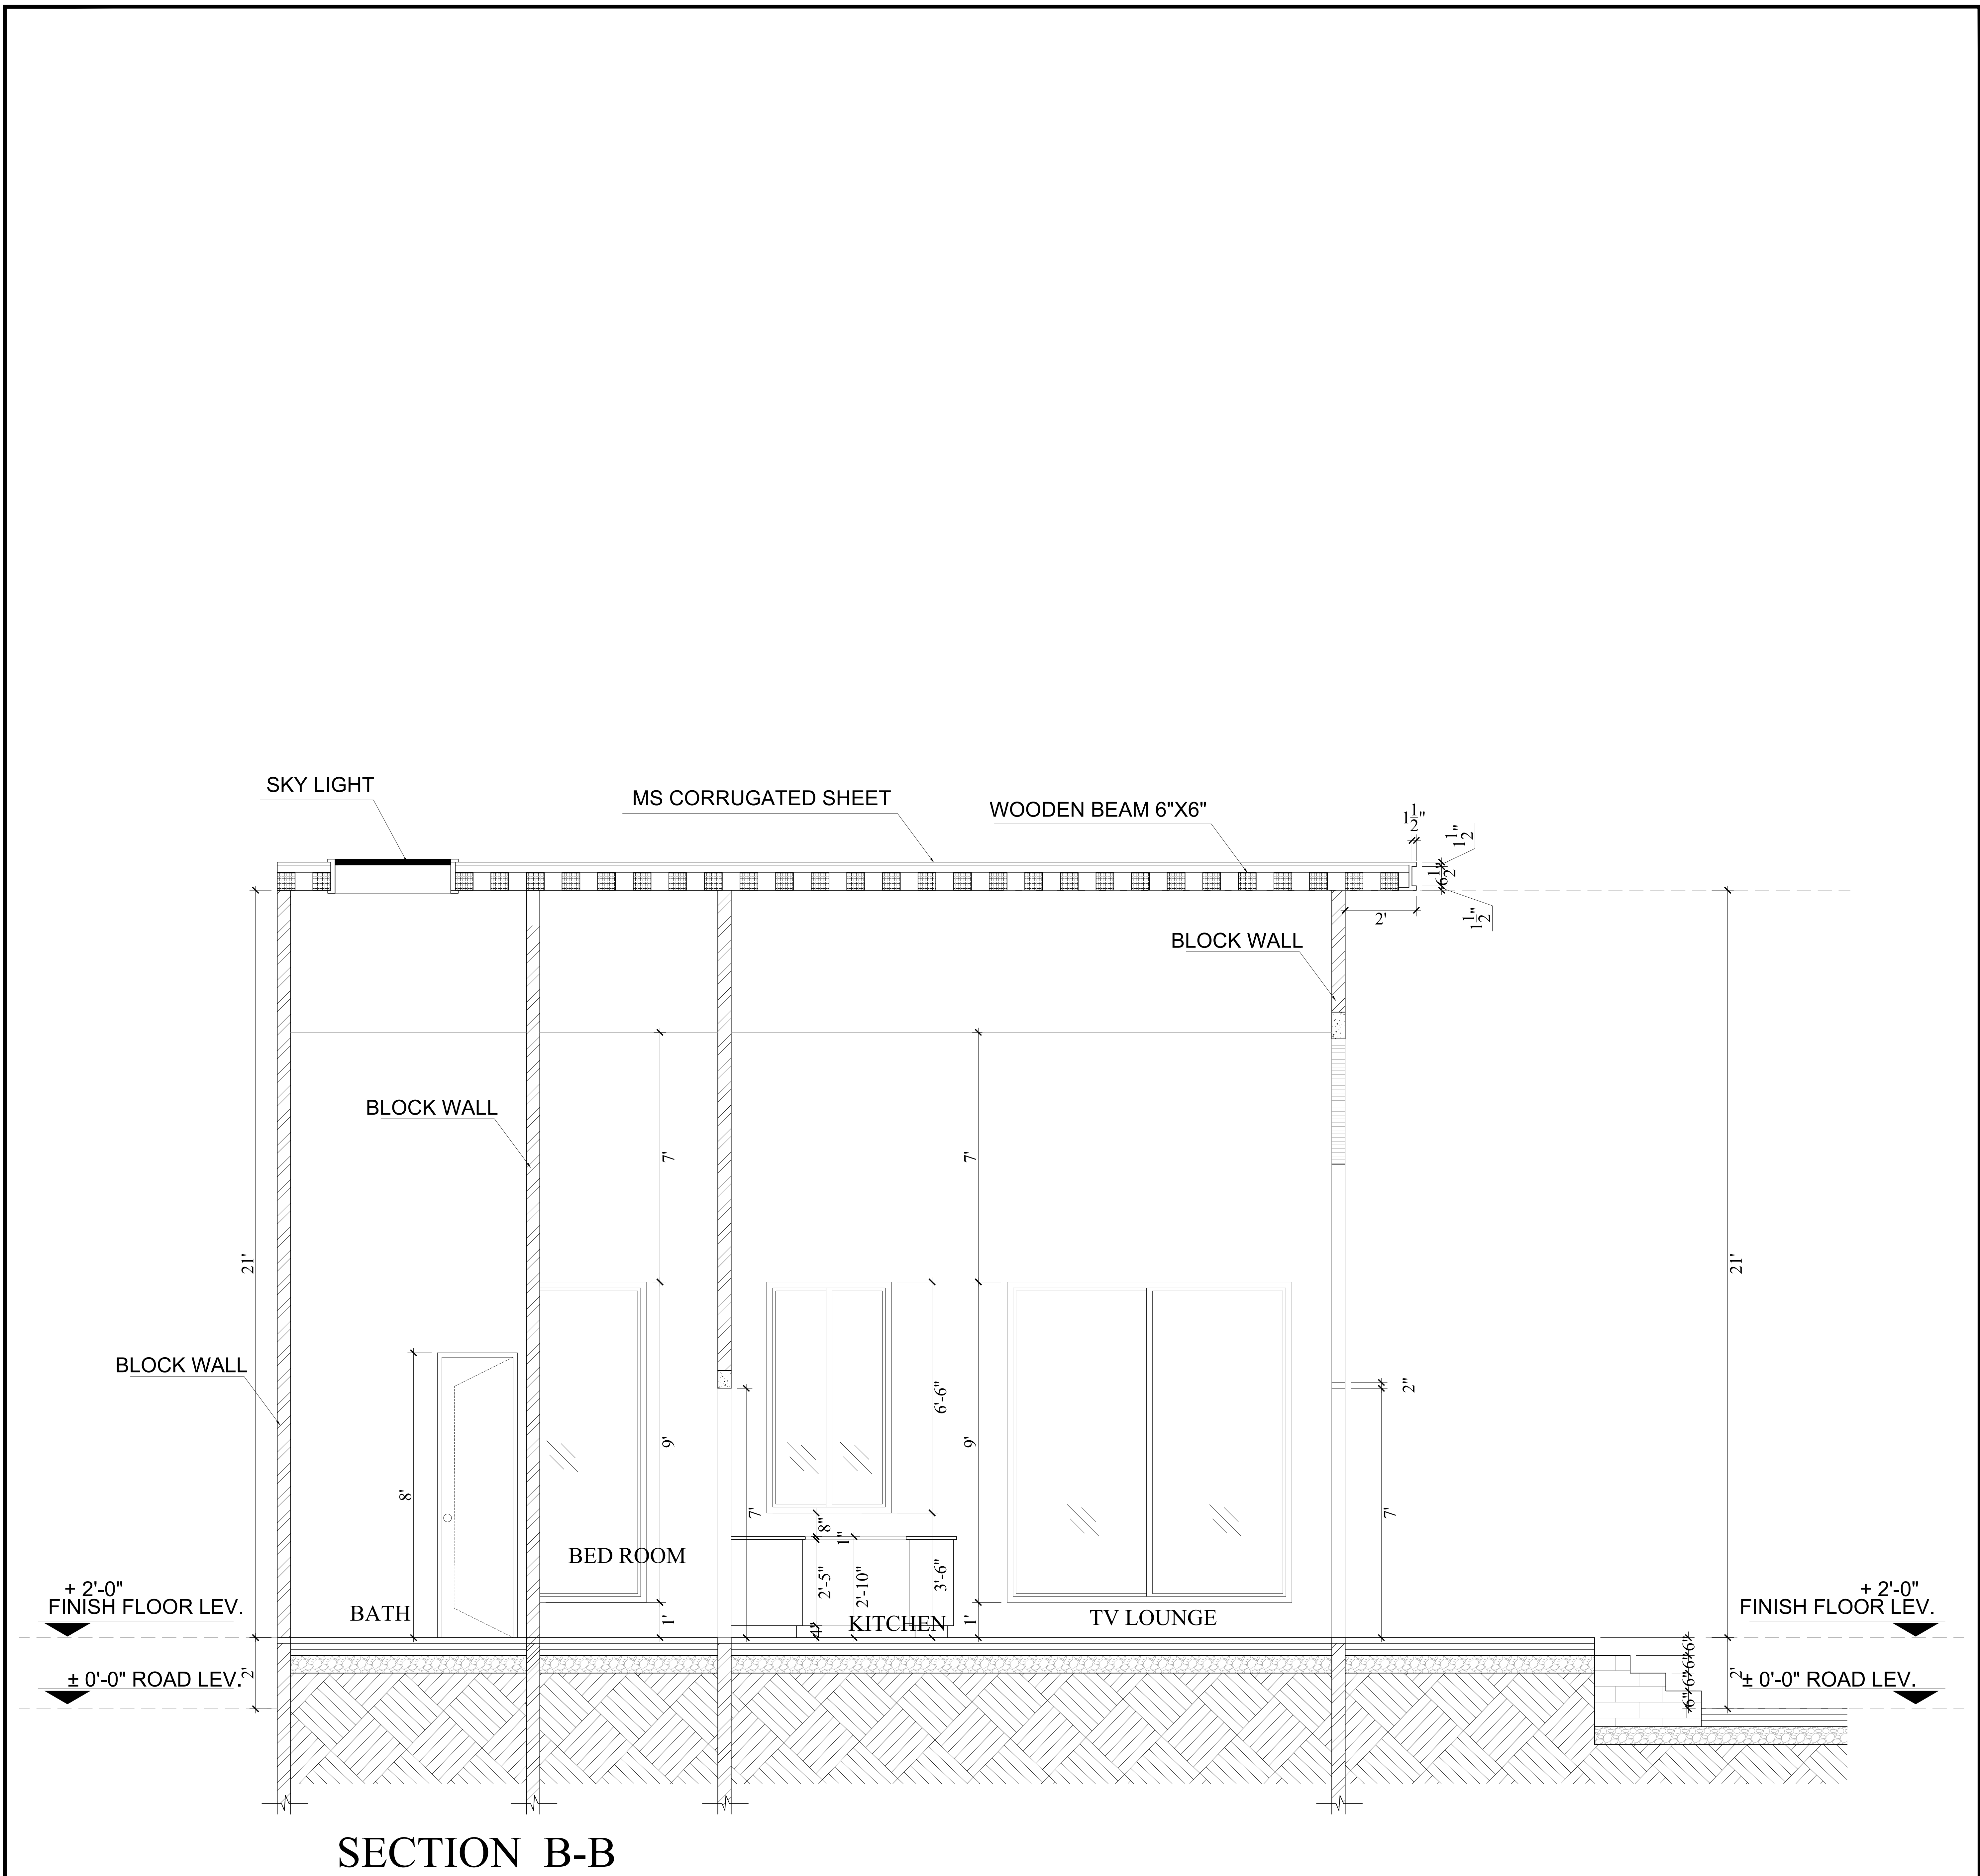


NOTE: Brick Will be used in all Construction Villas.
And for top roof structure we will use m.s corrugated sheet + Wooden beam.











α PROPOSAL DRAWINGS SECTION B-B	PAGE NO.	13	DRAWING NO.	AR-12	DESIGN BY:	Aqib ali
	CLIENT:		PROJECT :	MURREE COTTAGE HOUSE	DRAWN BY:	Eshan
					DATE:	23.08.2024

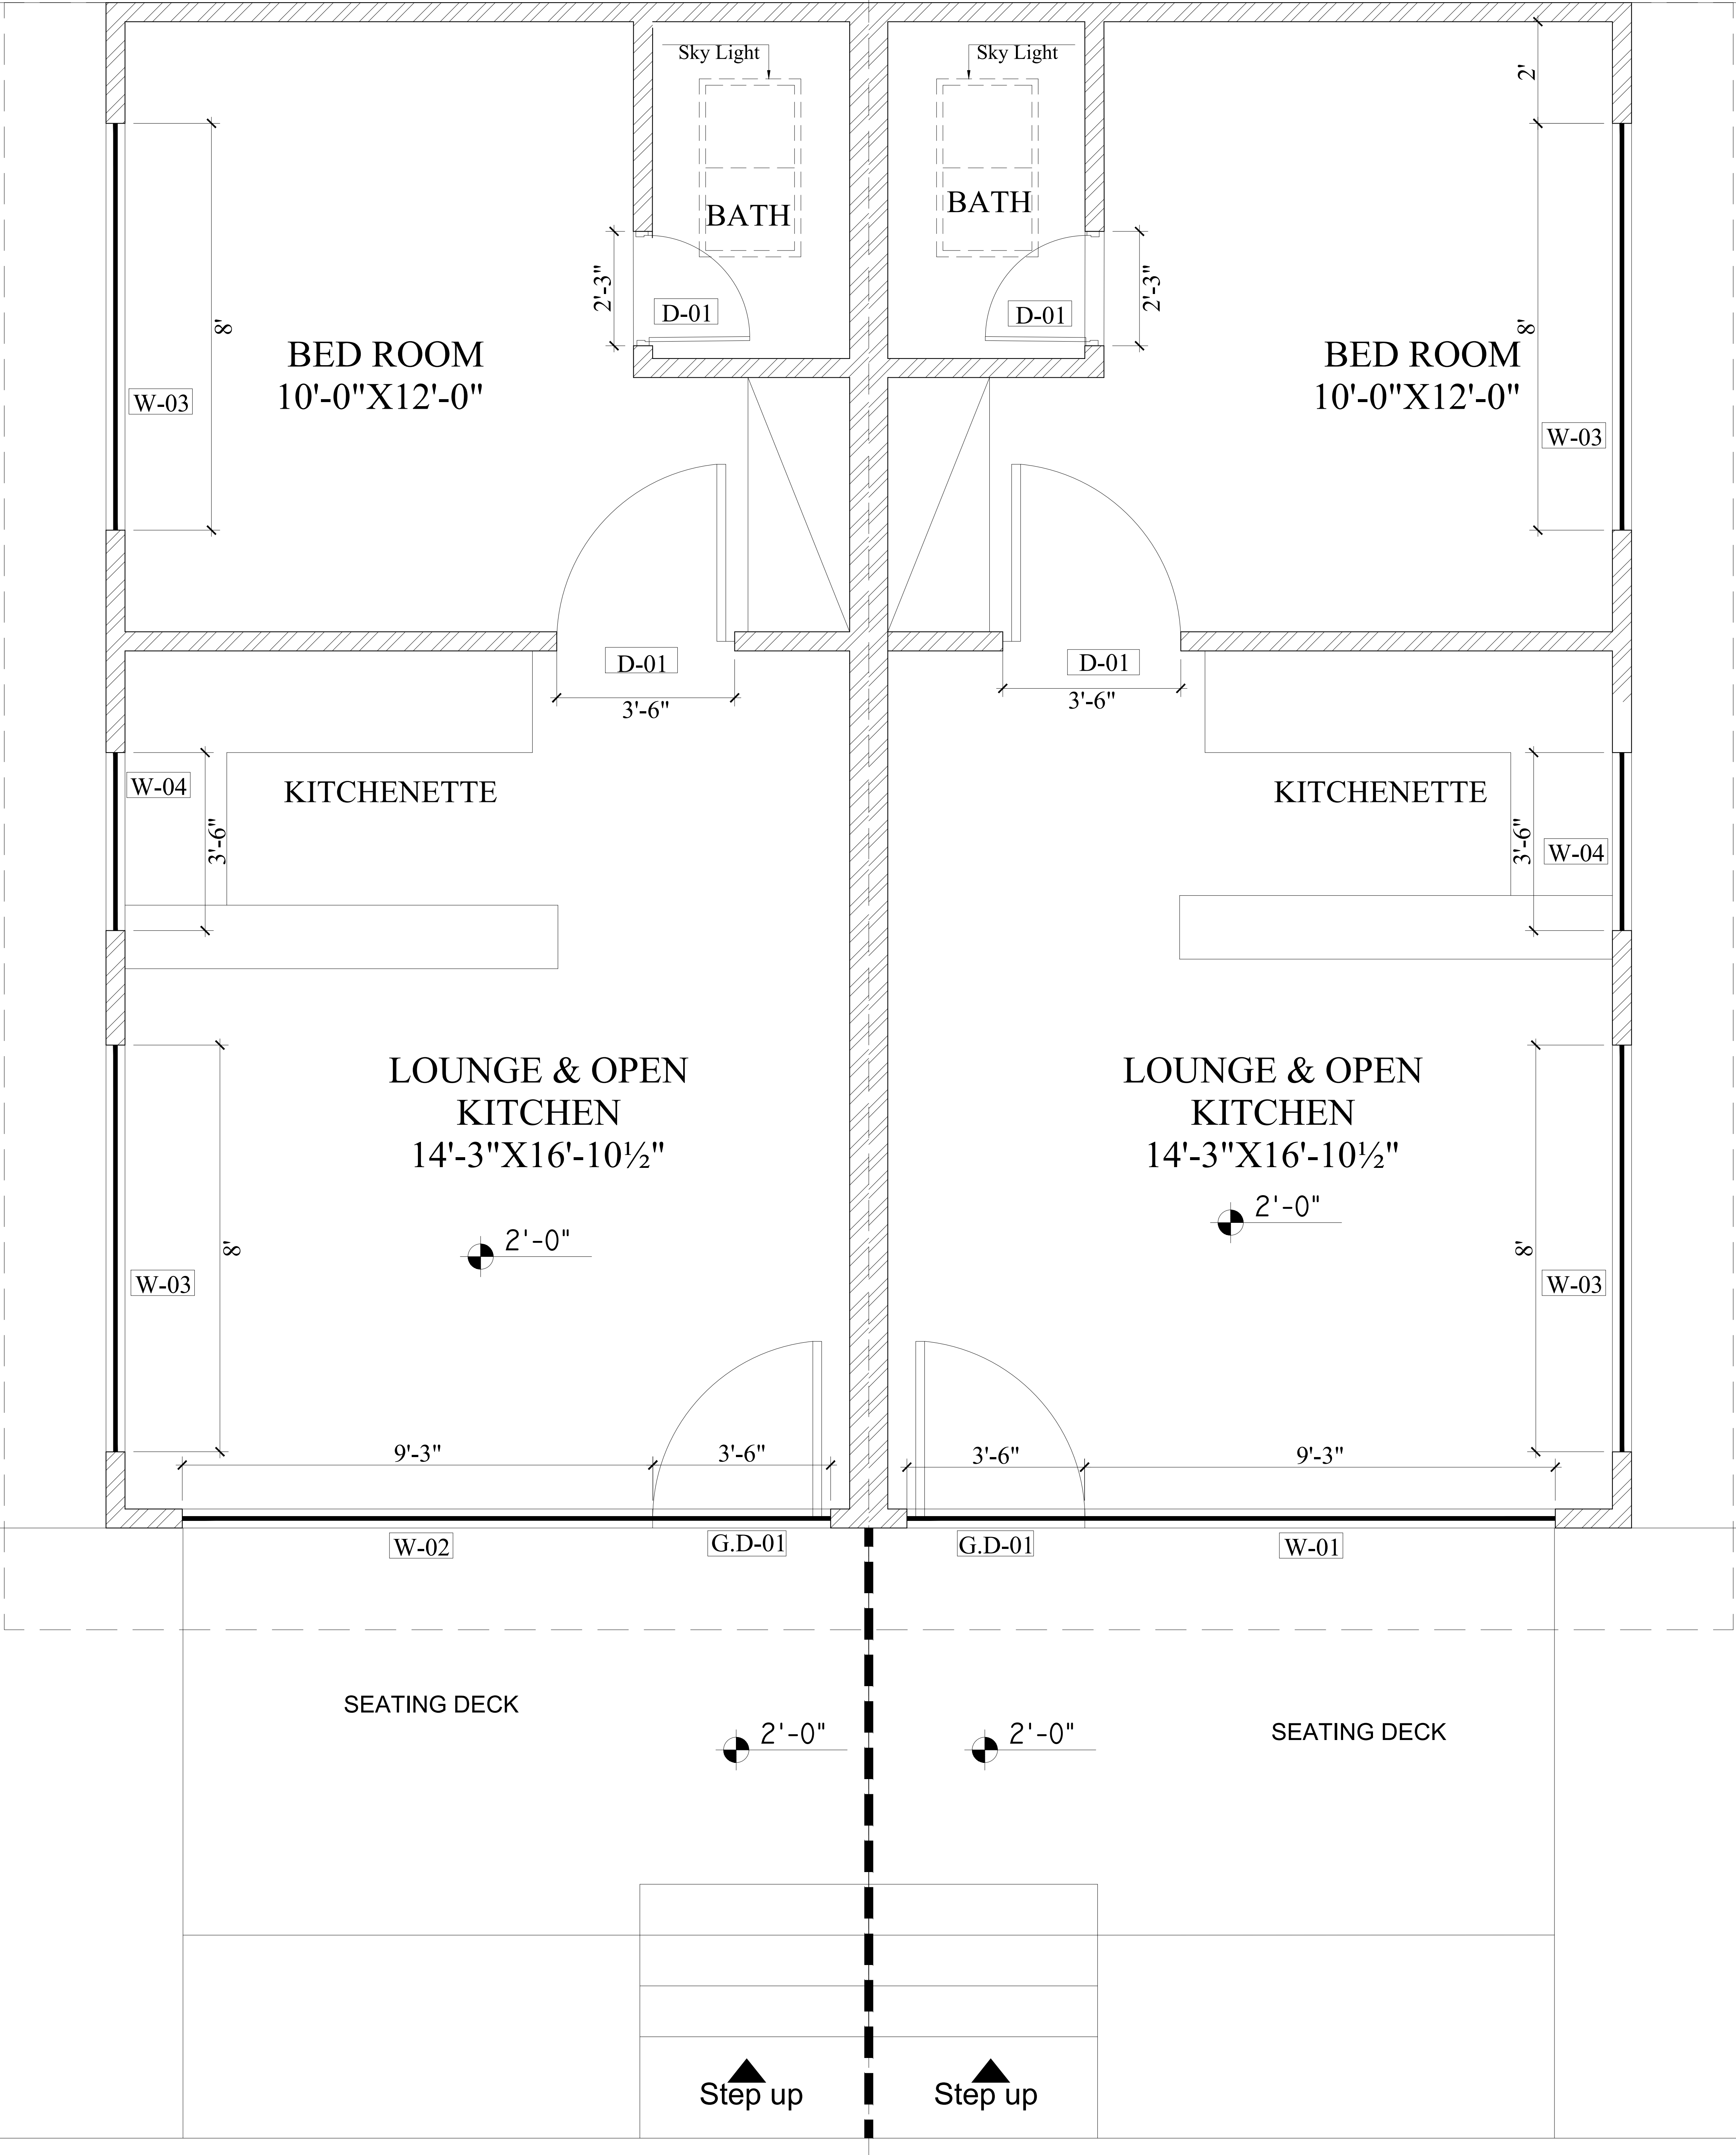

COTTAGE HOUSE LAYOUT PLAN
Covered Area = 450 Sft
Total plot Area = 840 Sft
Plot no # 26

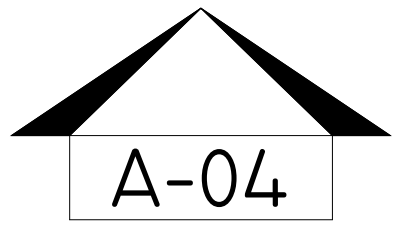

COTTAGE HOUSE LAYOUT PLAN
Covered Area = 450 Sft
Total plot Area = 840 Sft
Plot no # 26

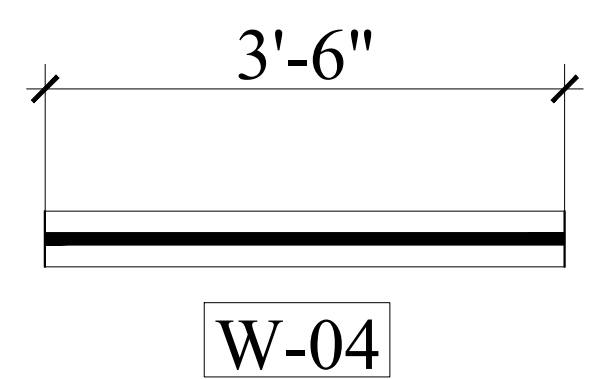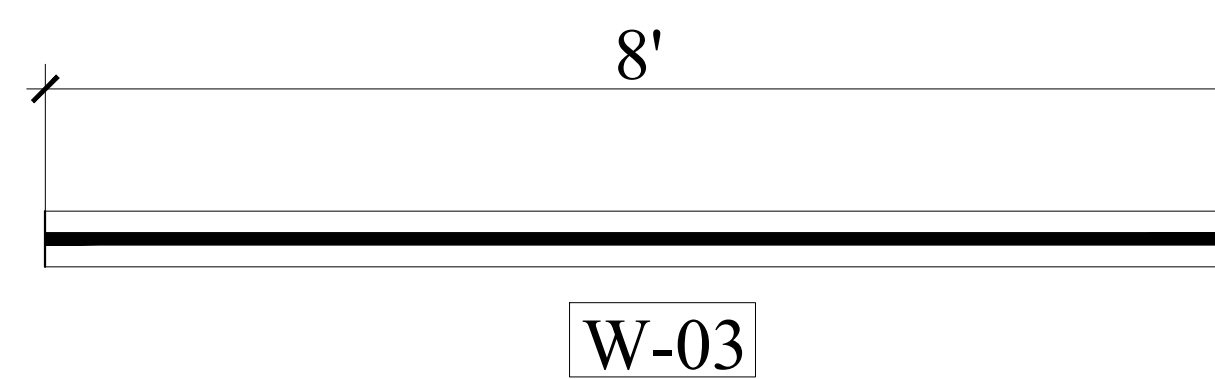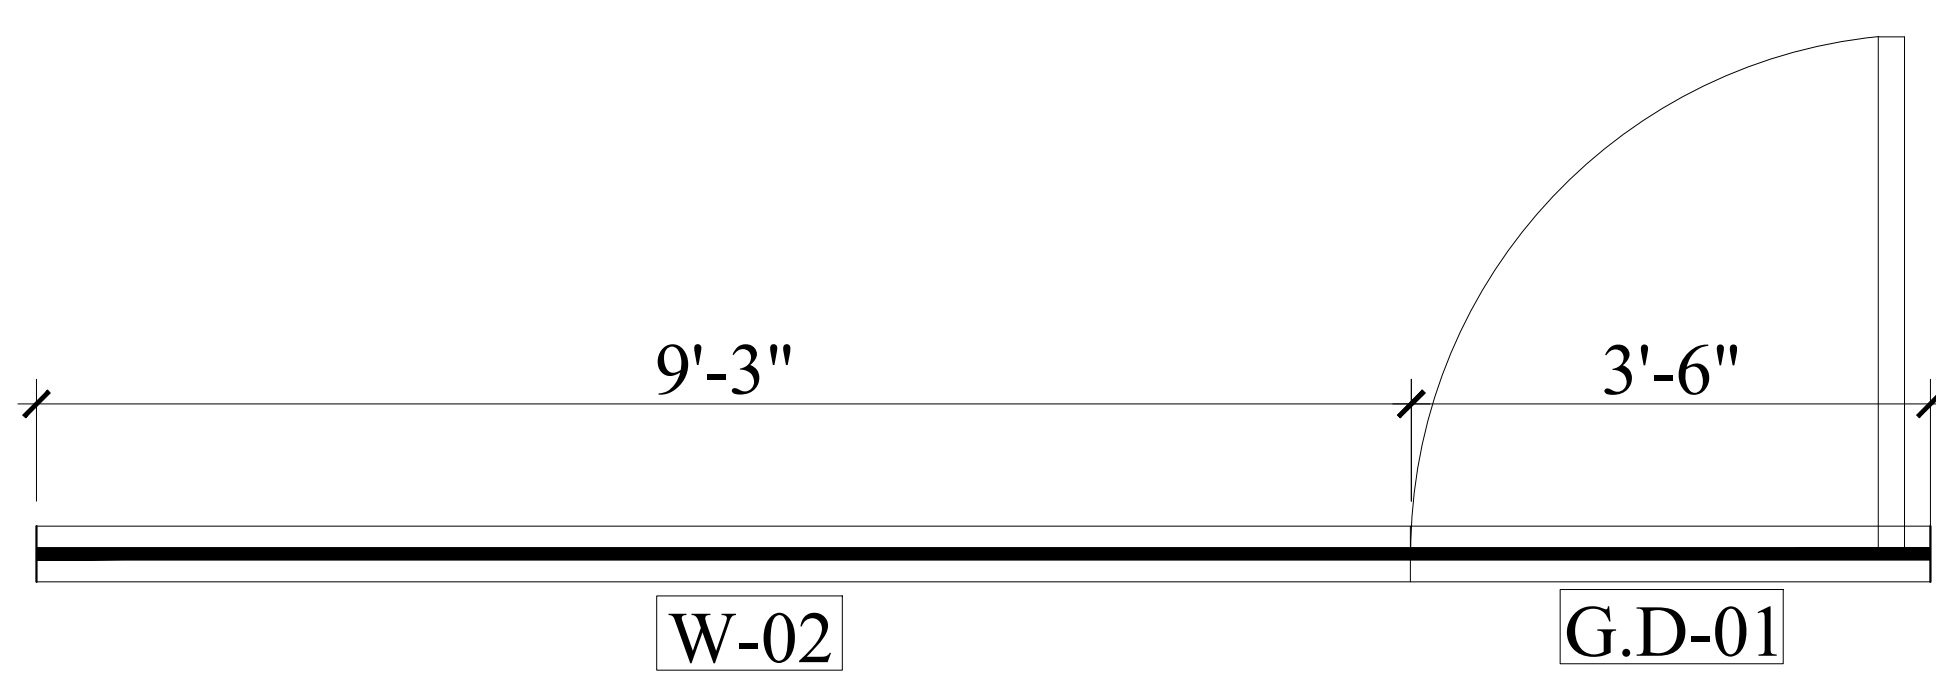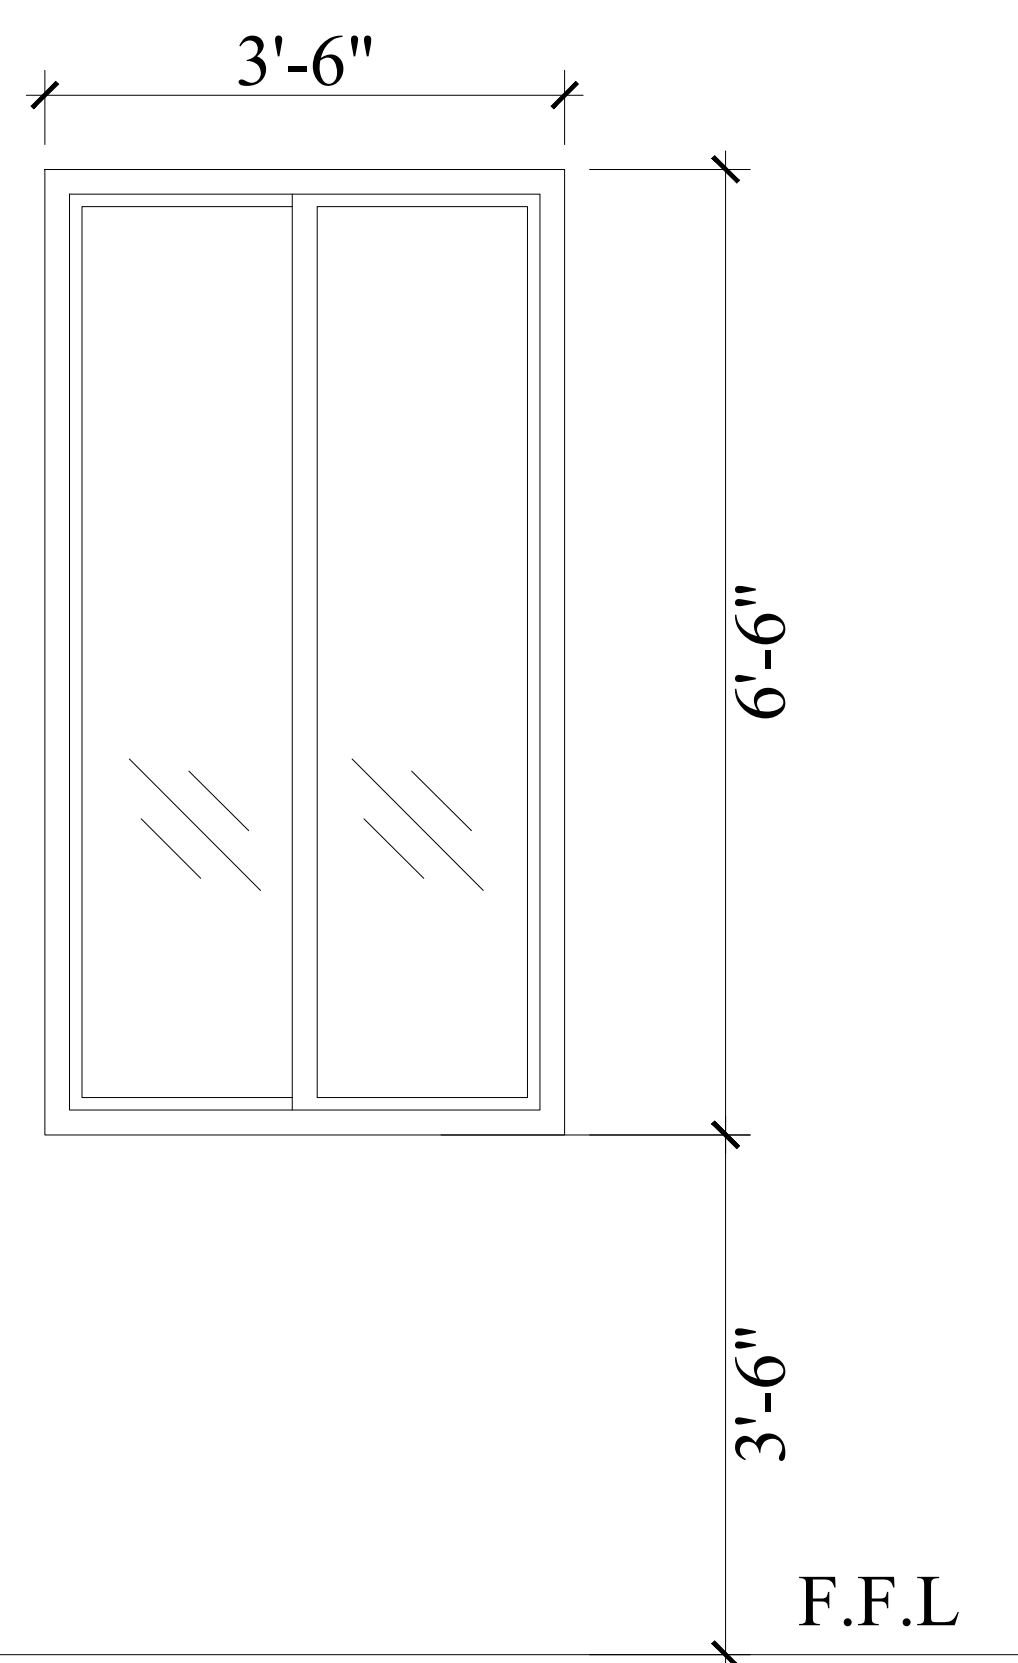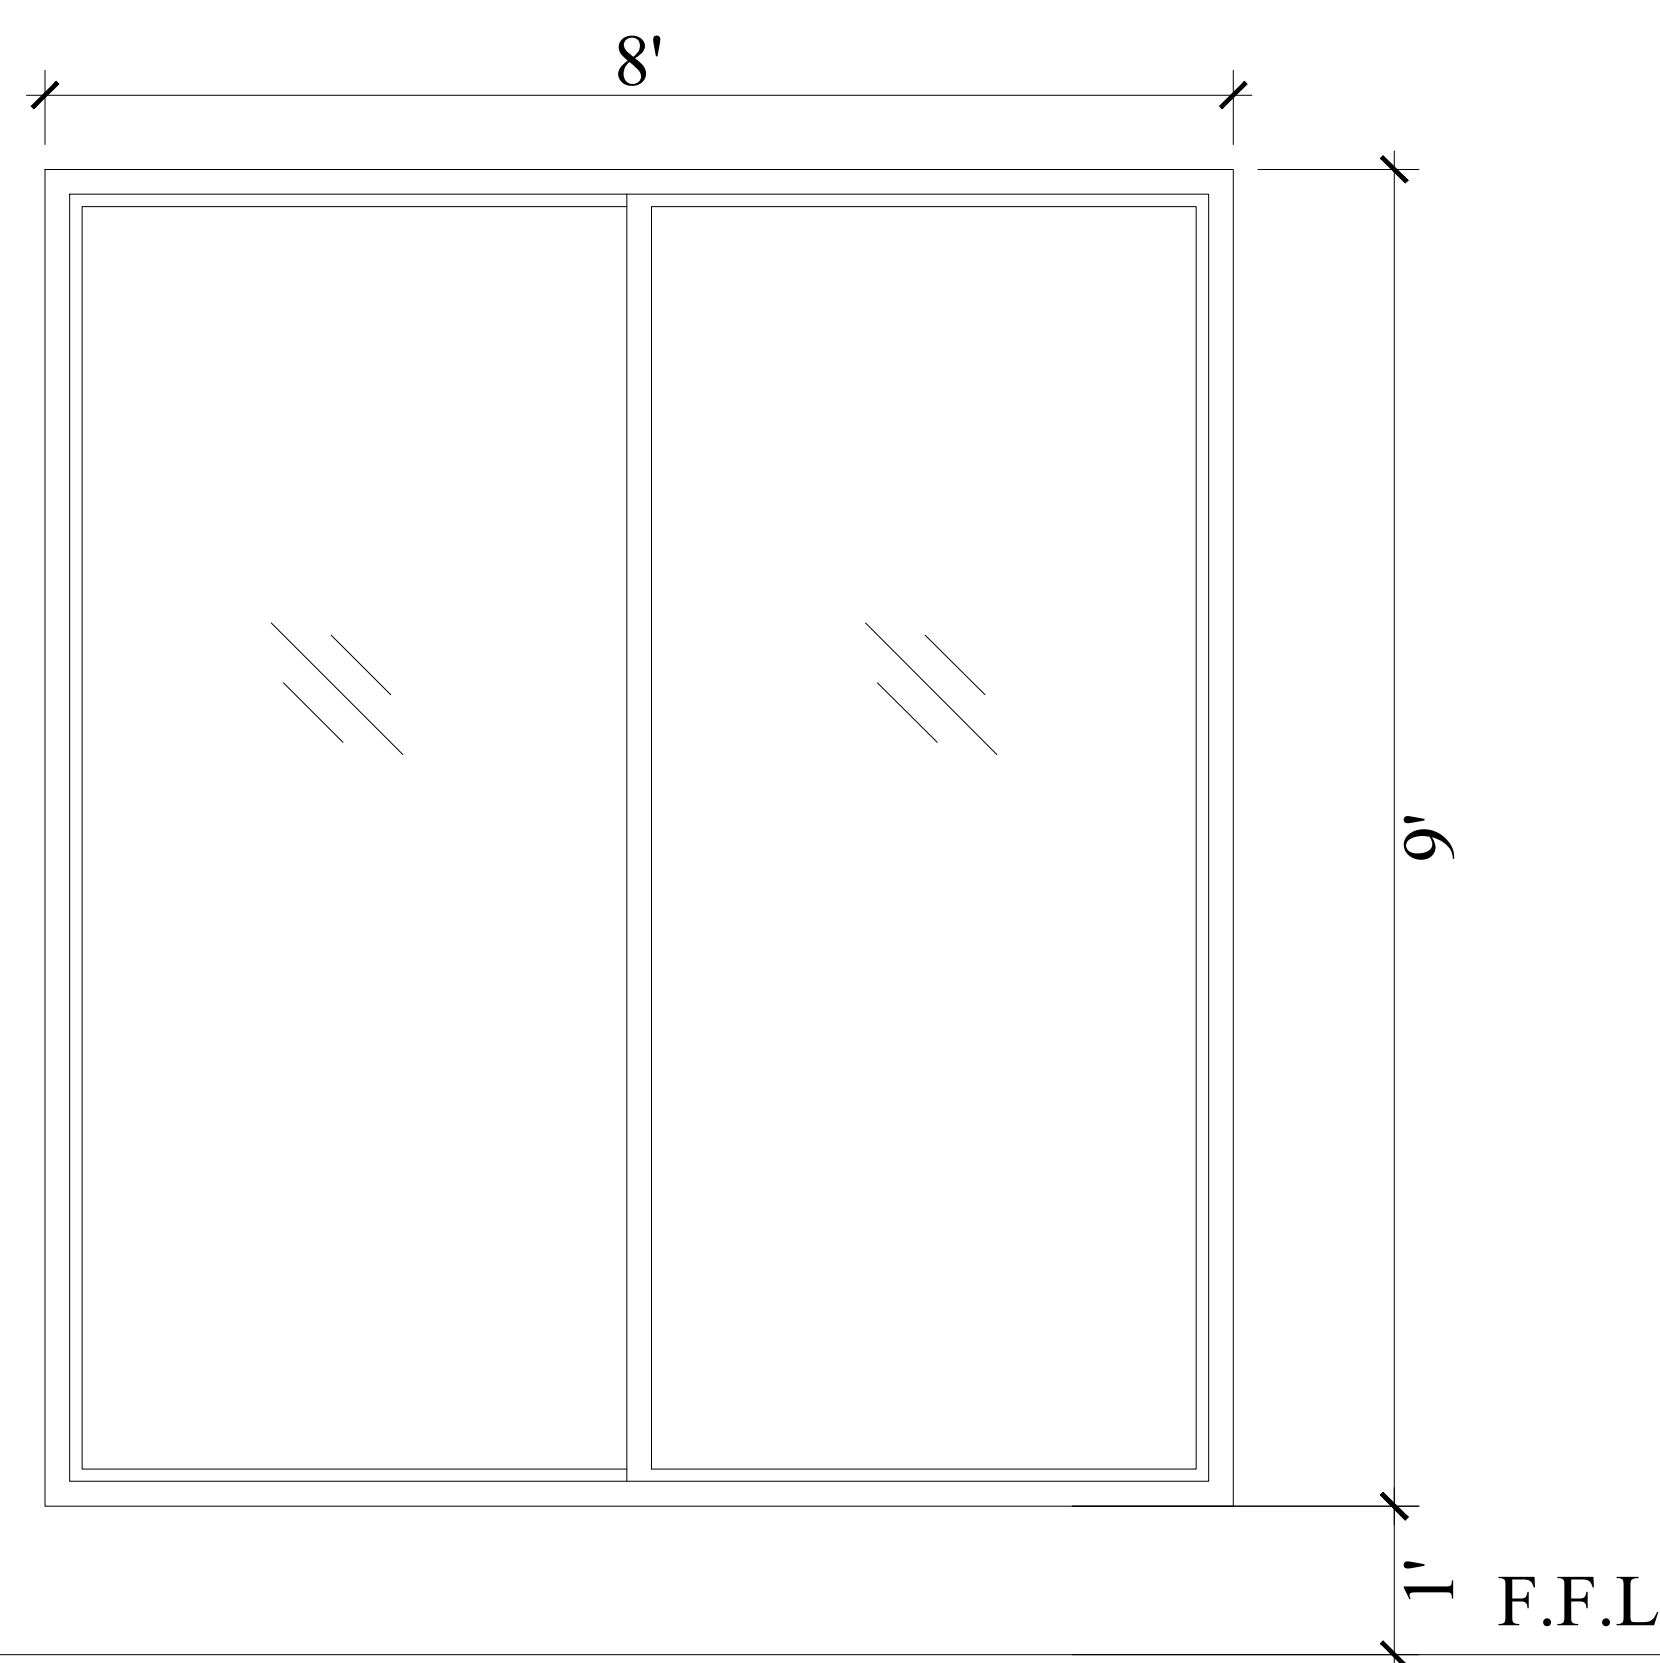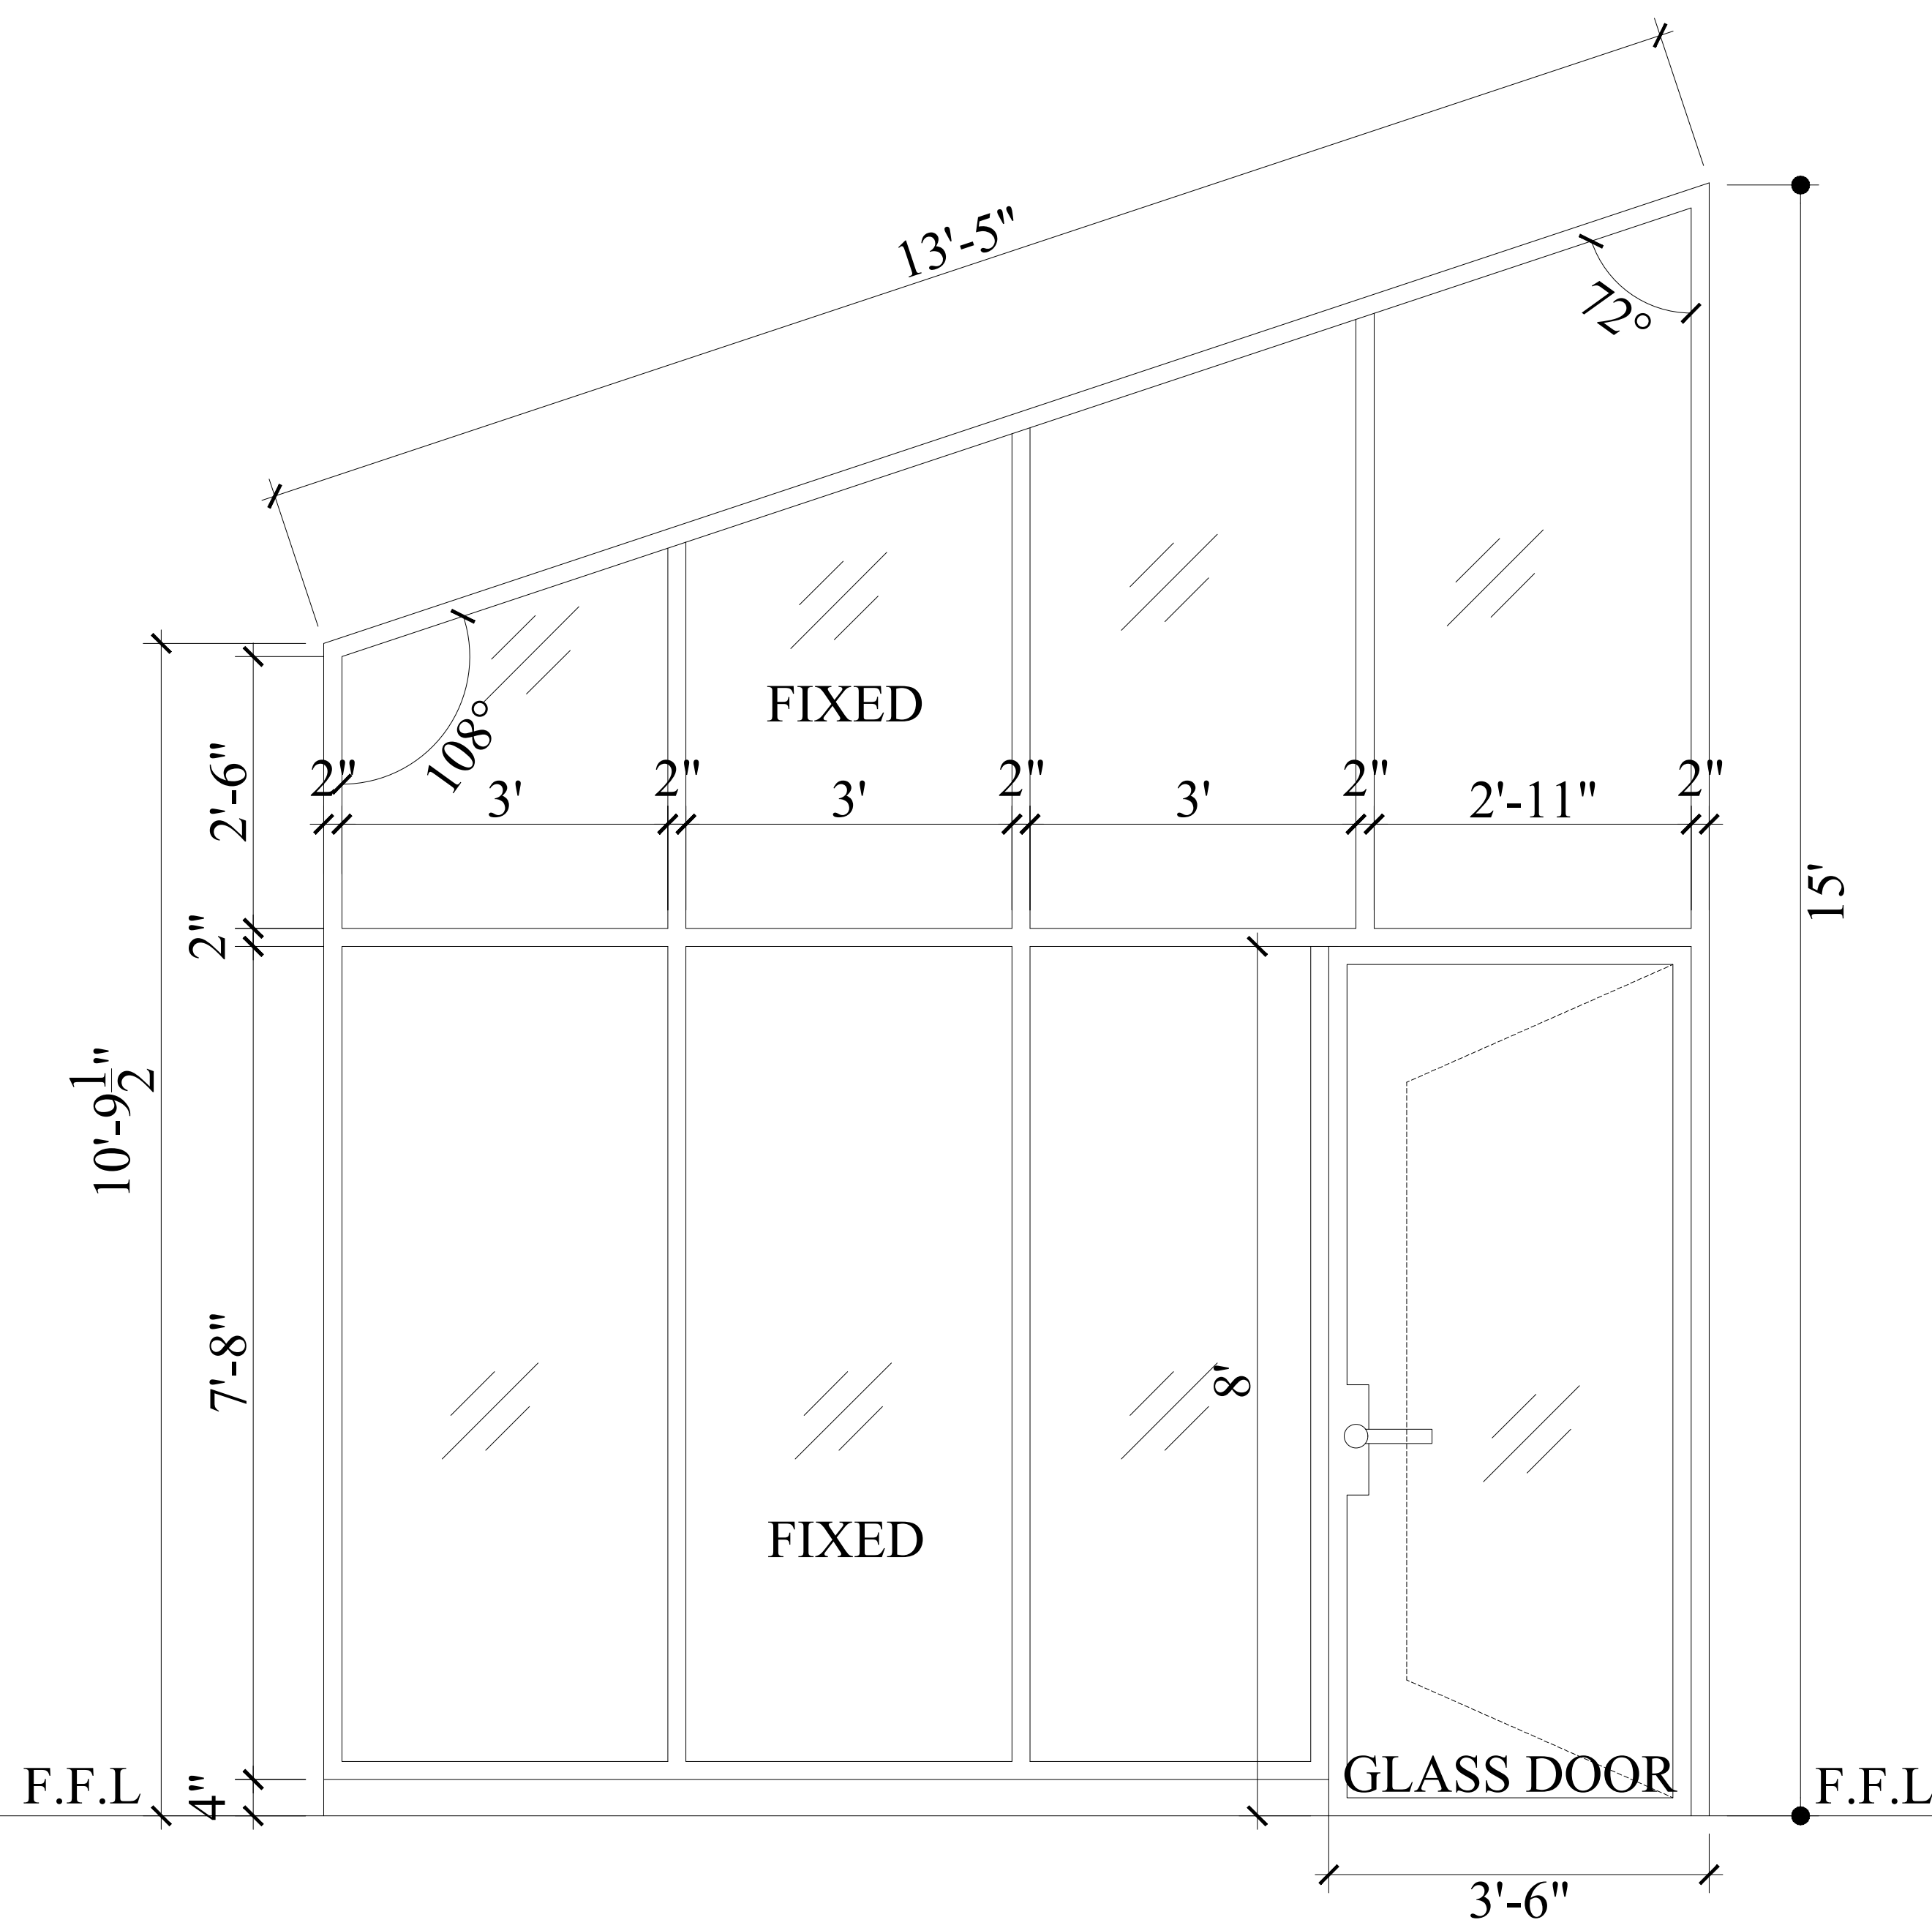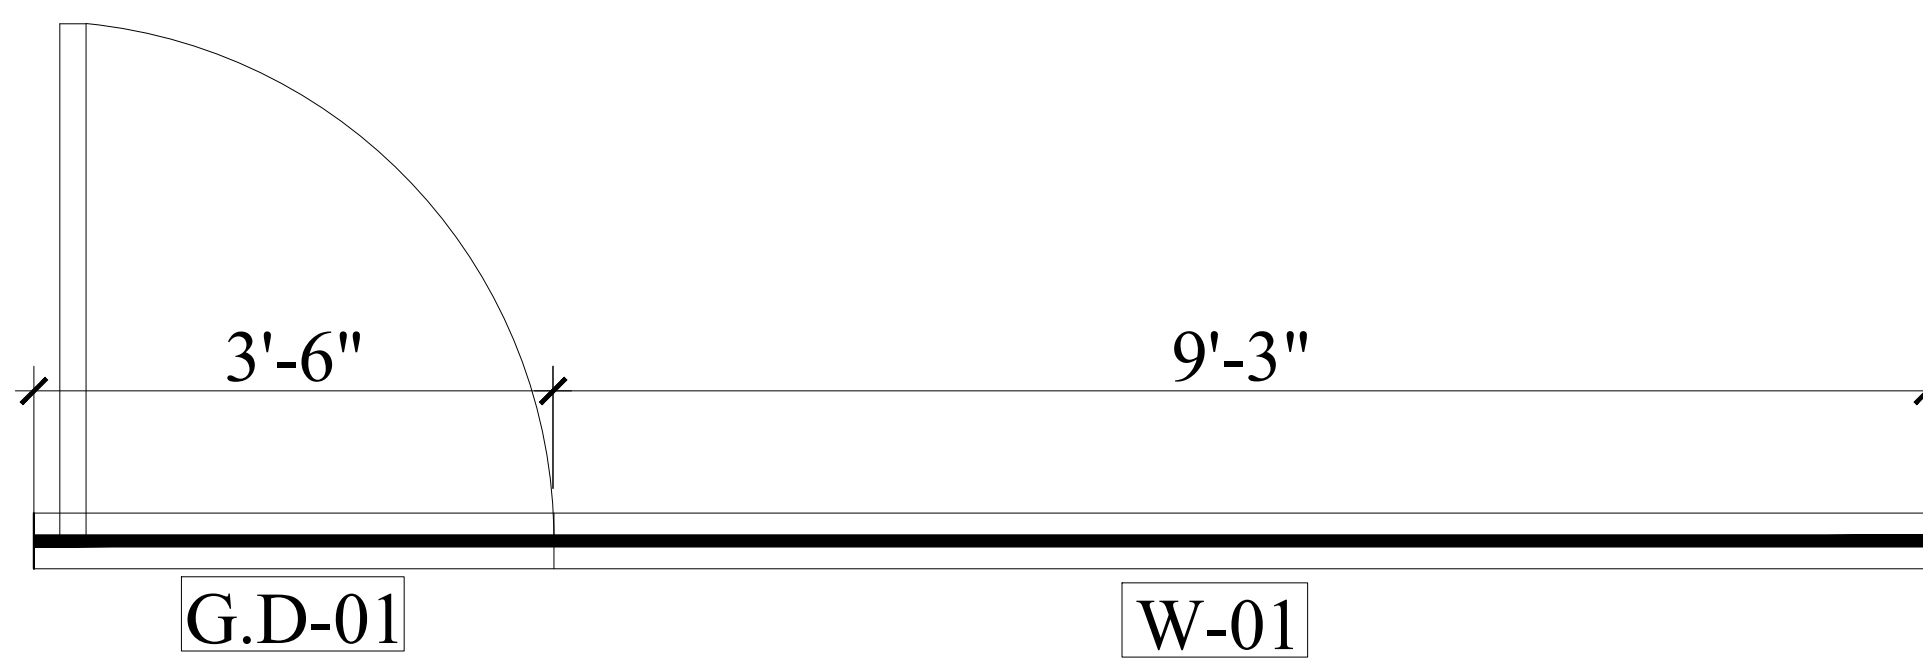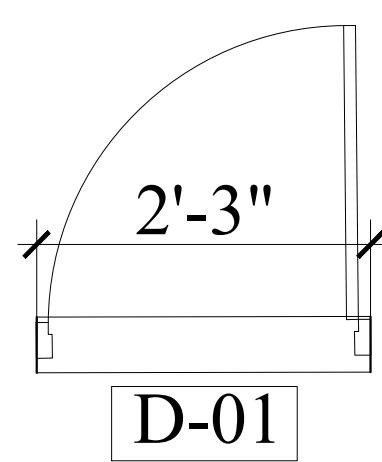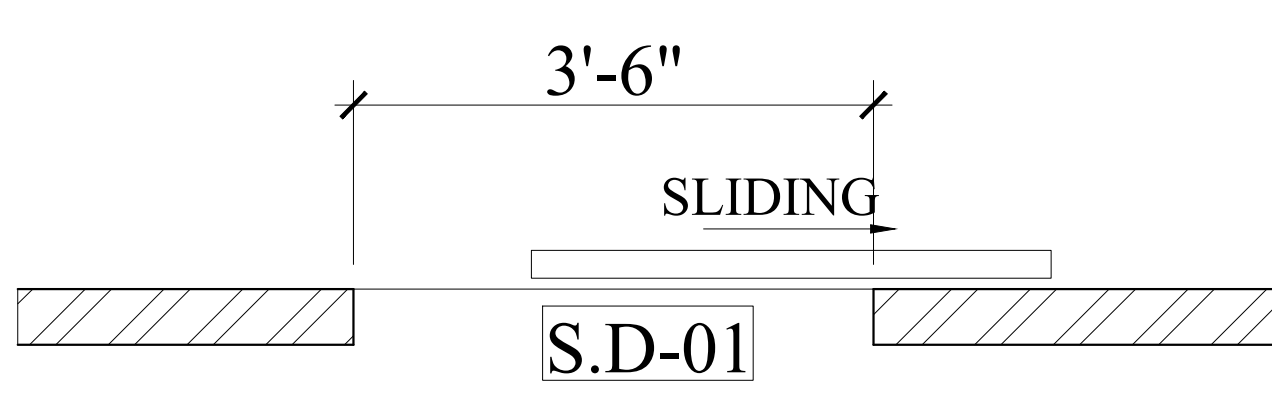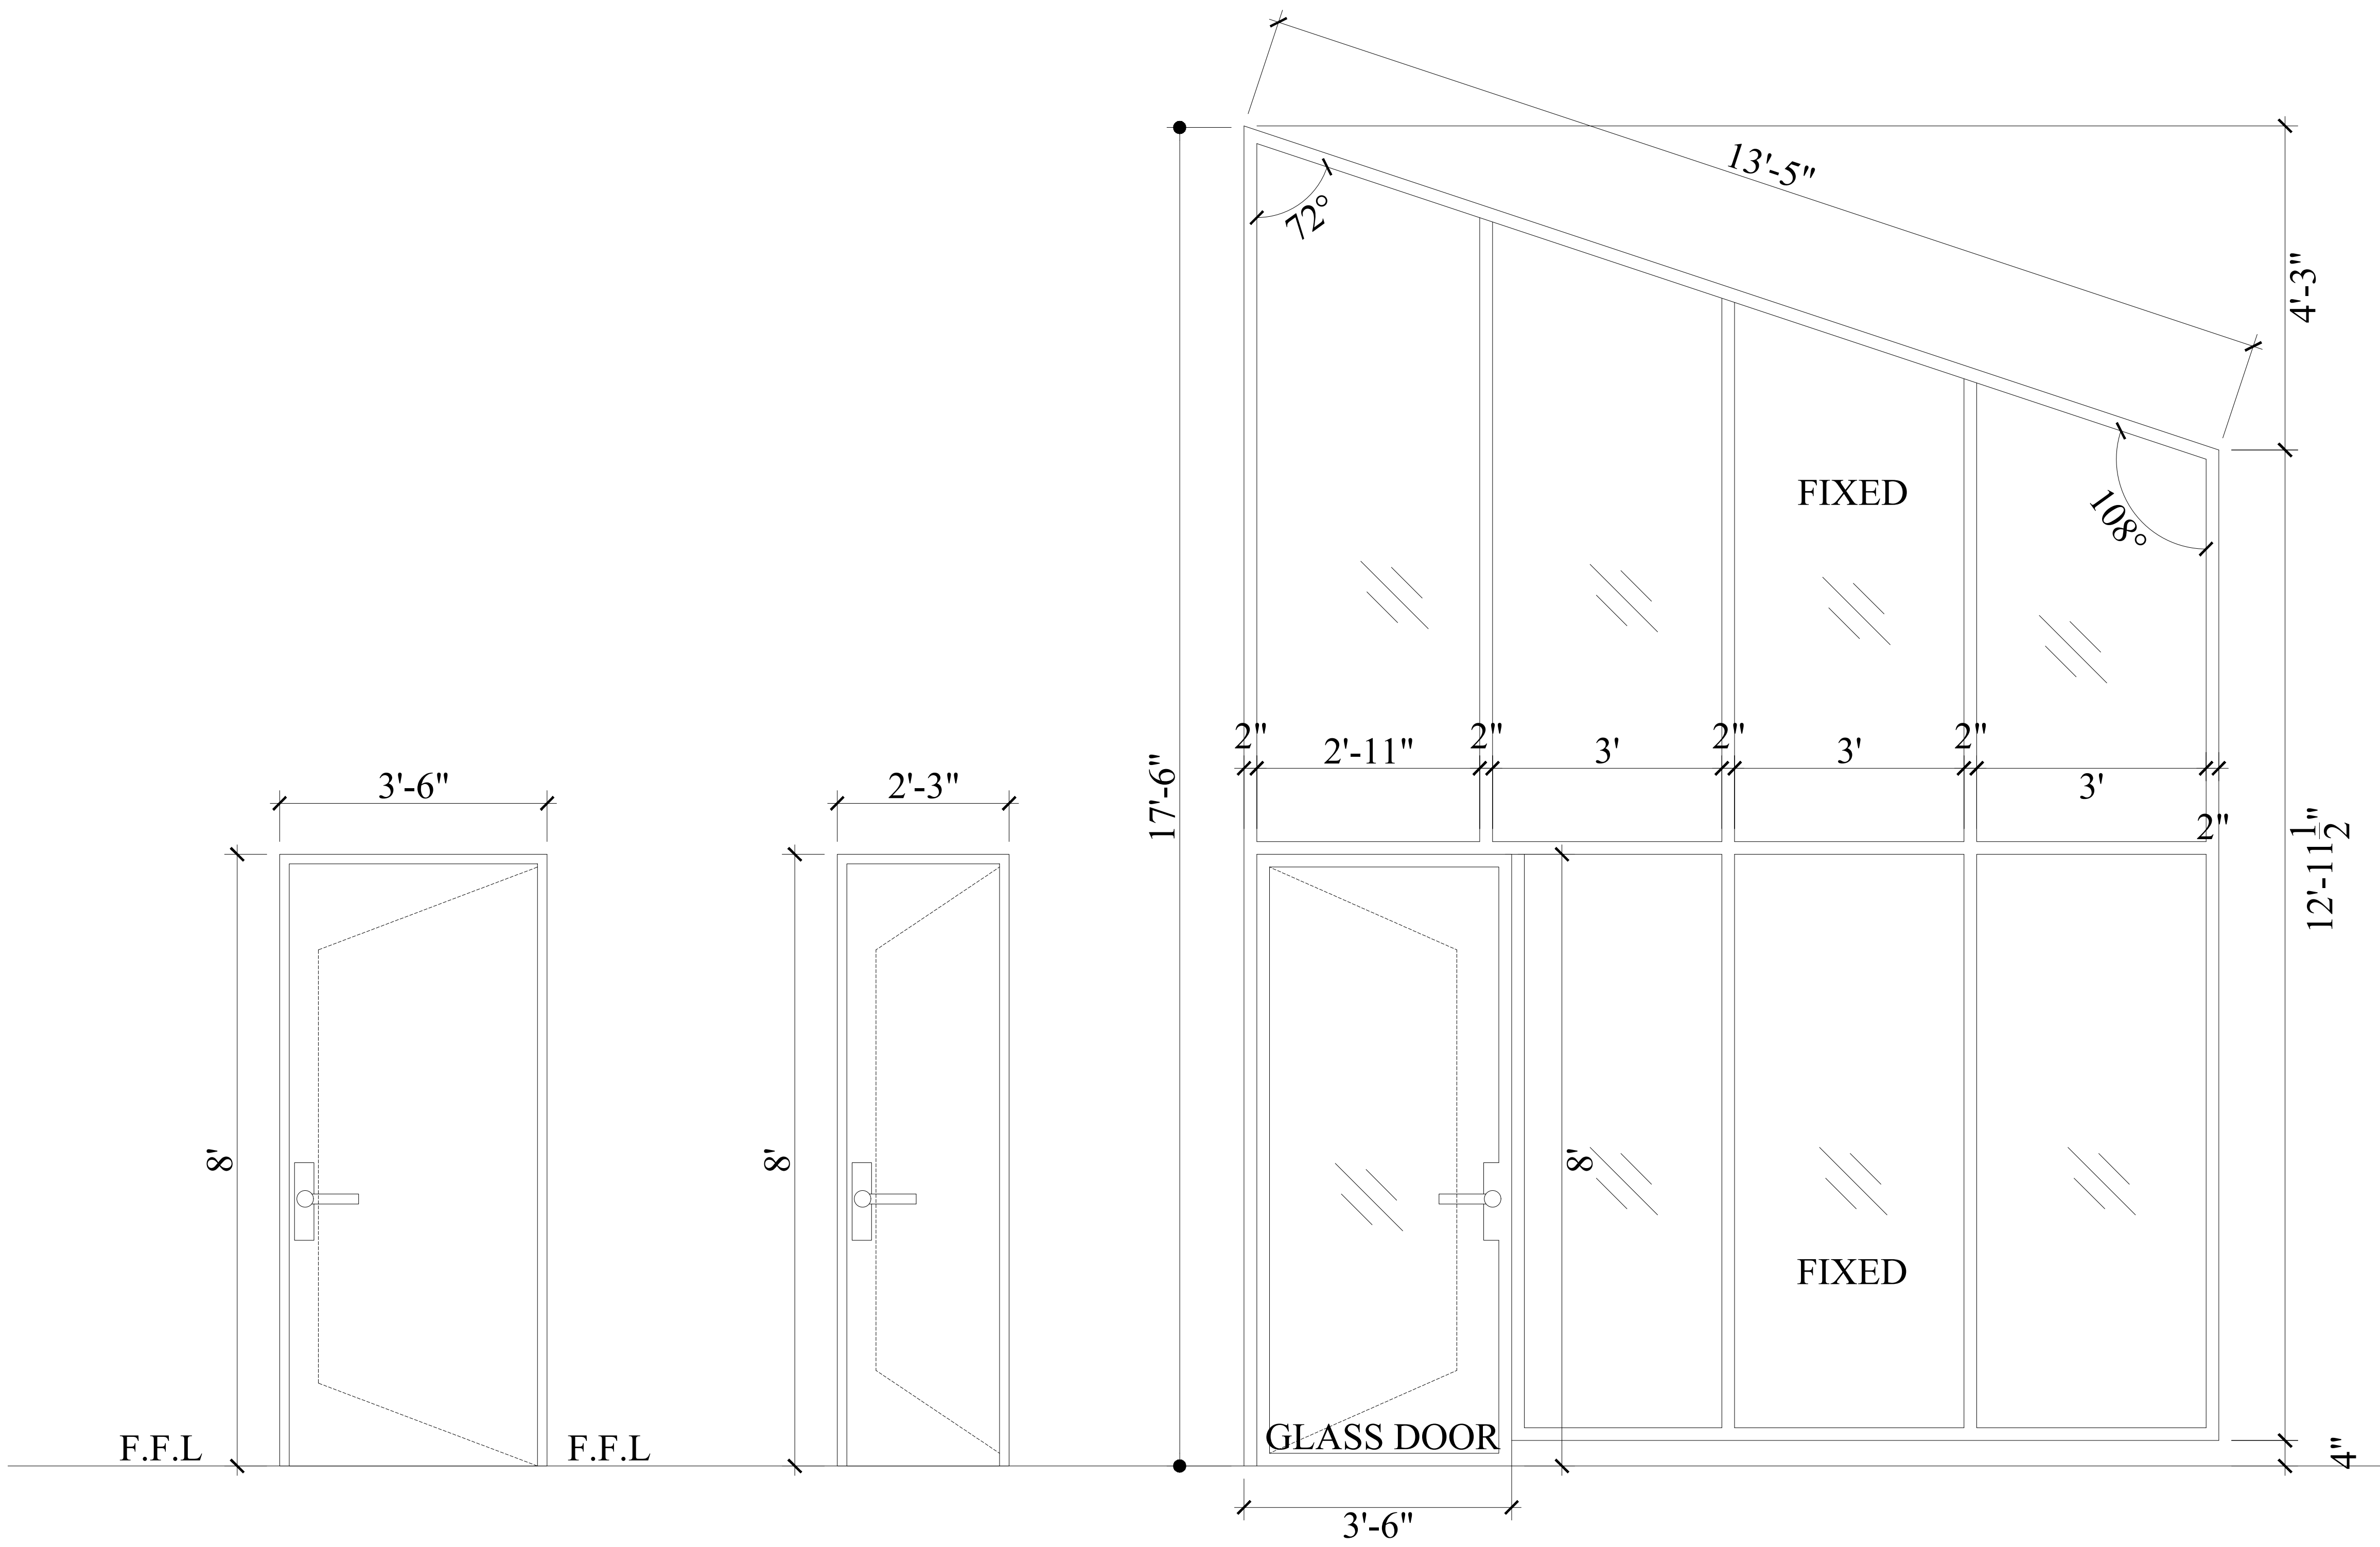

PROPOSAL DRAWINGS

DOORS & WINDOWS
ELEVATIONS & SCHEDULE

PAGE NO.

15

DRAWING NO.

AR-14

DESIGN BY:

Aqib ali

CLIENT:

.....

PROJECT :


MURREE COTTAGE HOUSE

DRAWN BY:

Eshan

DATE:

23.08.2024

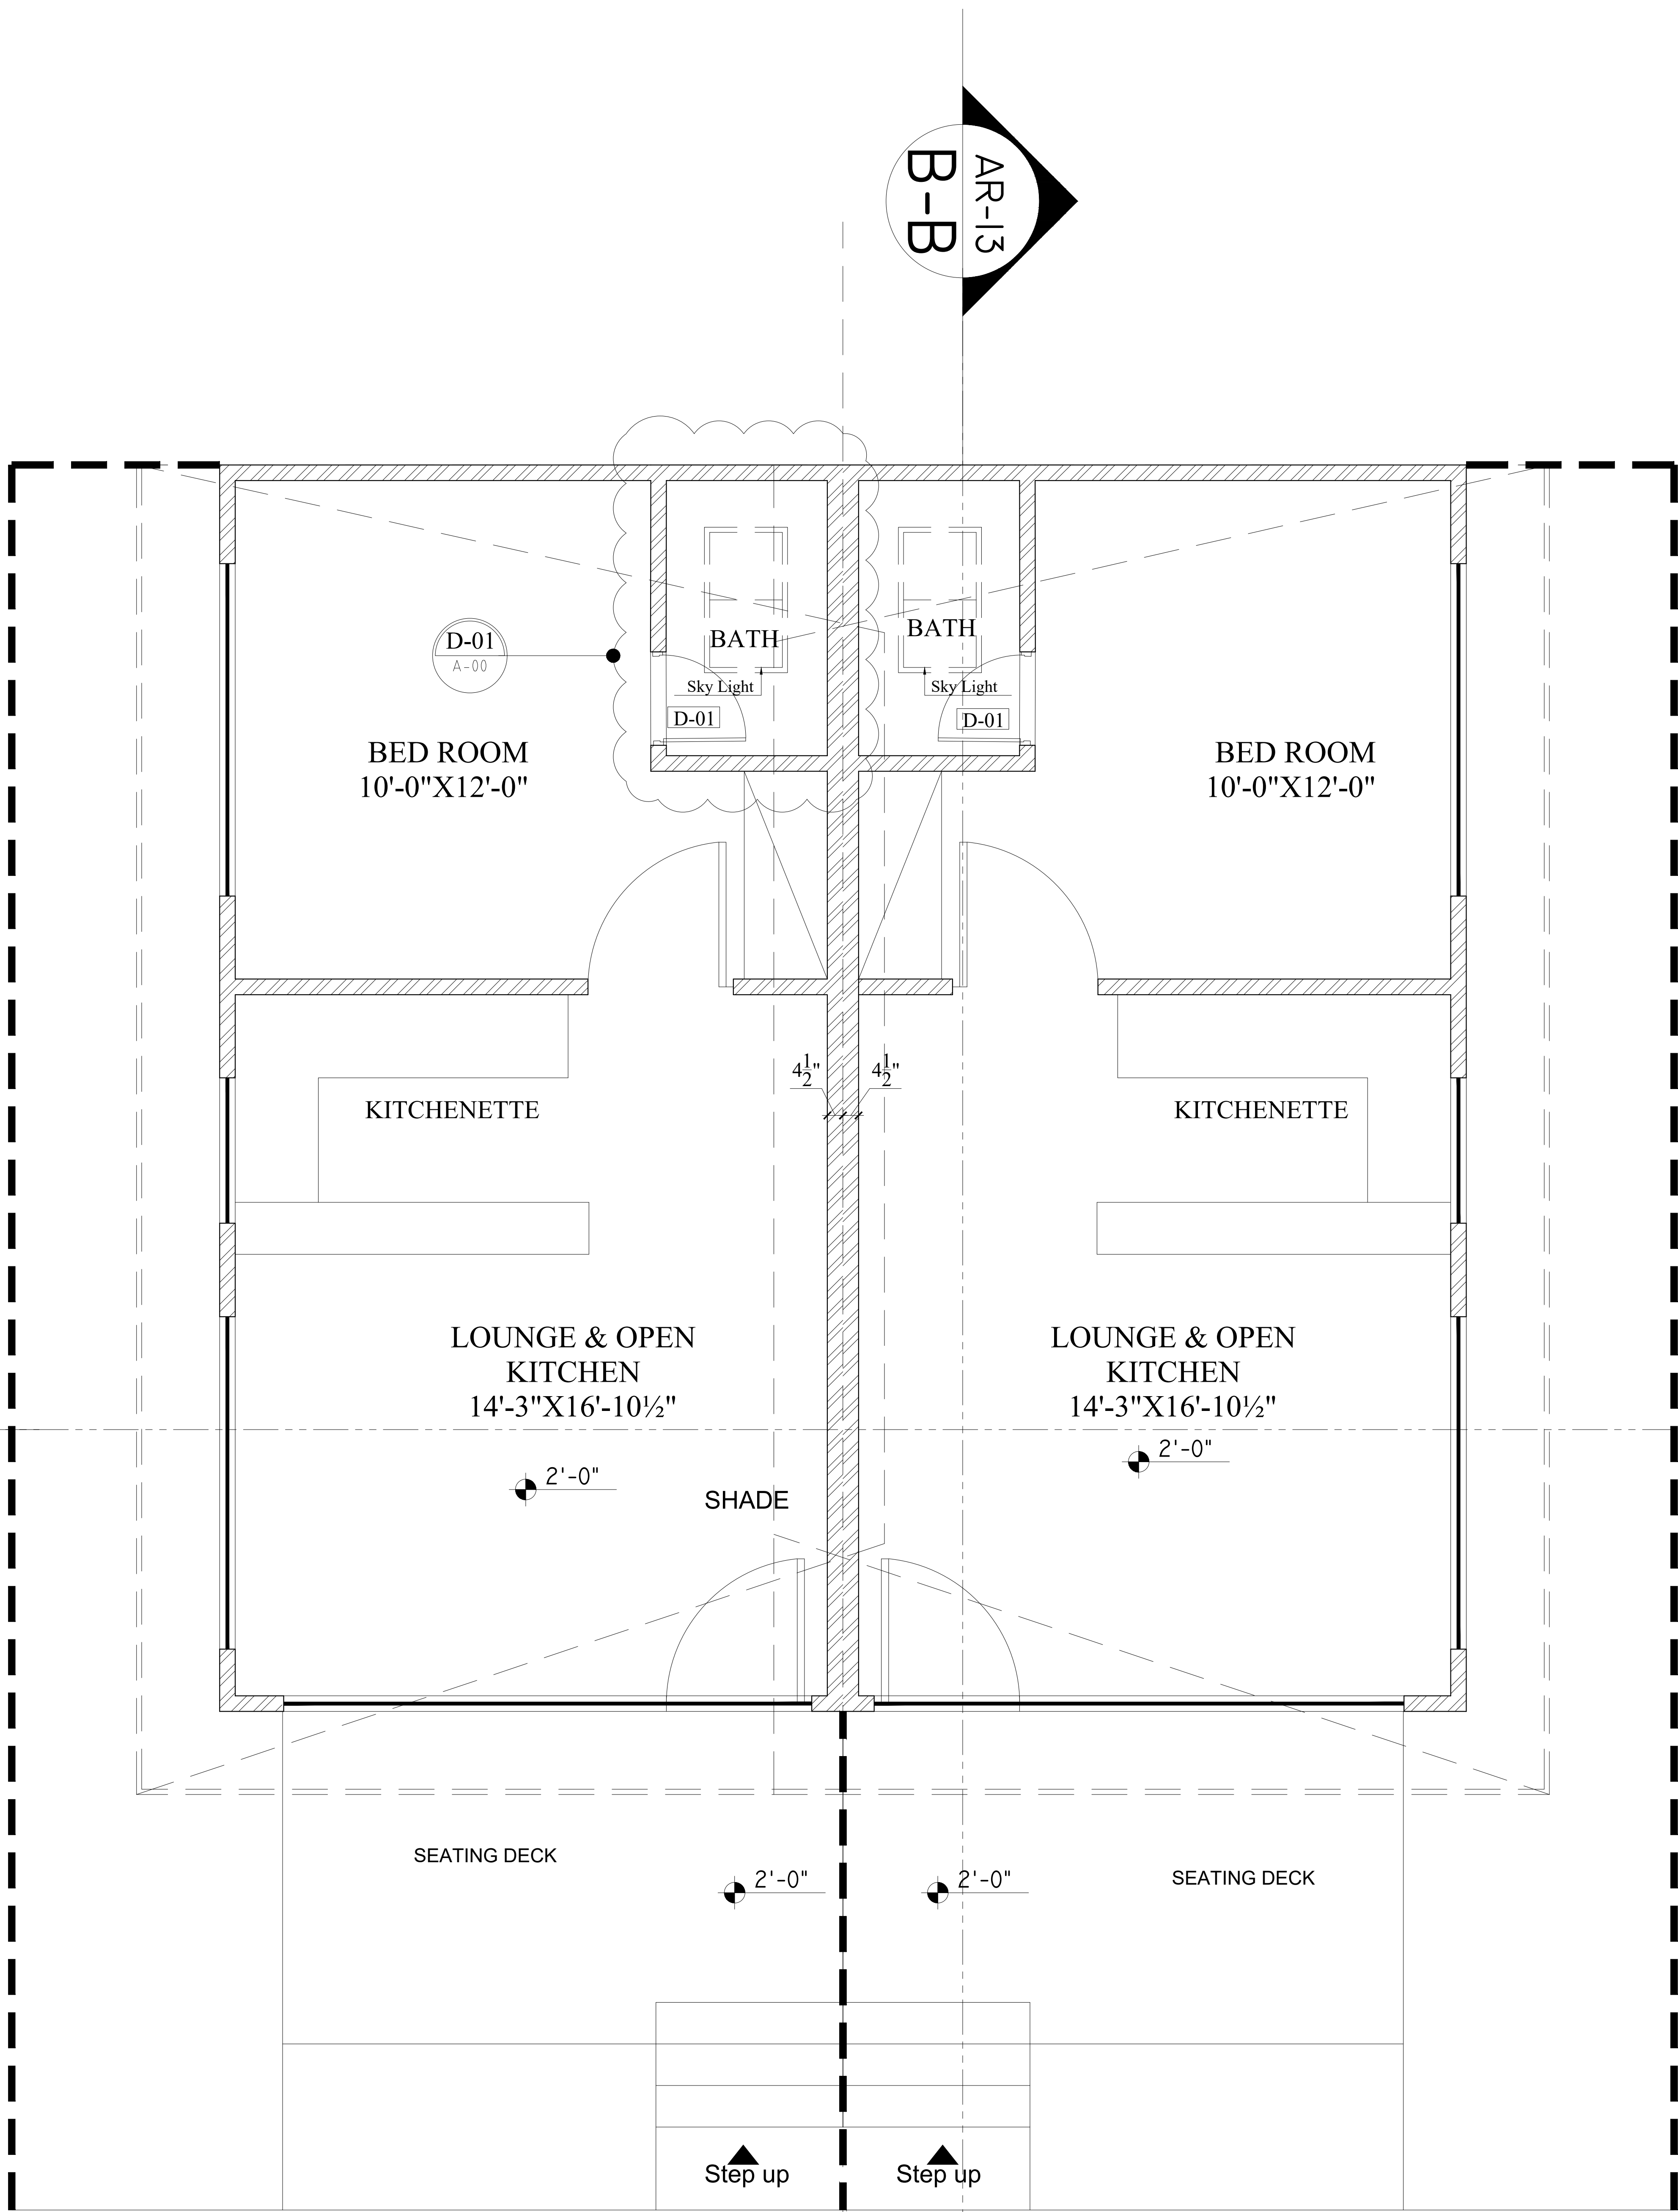


COTTAGE HOUSE LAYOUT PLAN
Covered Area = 450 Sft
Total plot Area = 840 Sft
Plot no # 26



PROPOSAL DRAWINGS

TAGGING LAYOUT PLAN
GROUND FLOOR

PAGE NO.	16	DRAWING NO.	AR-15	DESIGN BY:	Aqib ali
CLIENT:		PROJECT :	MURREE COTTAGE HOUSE	DRAWN BY:	Eshan
				DATE:	23.08.2024

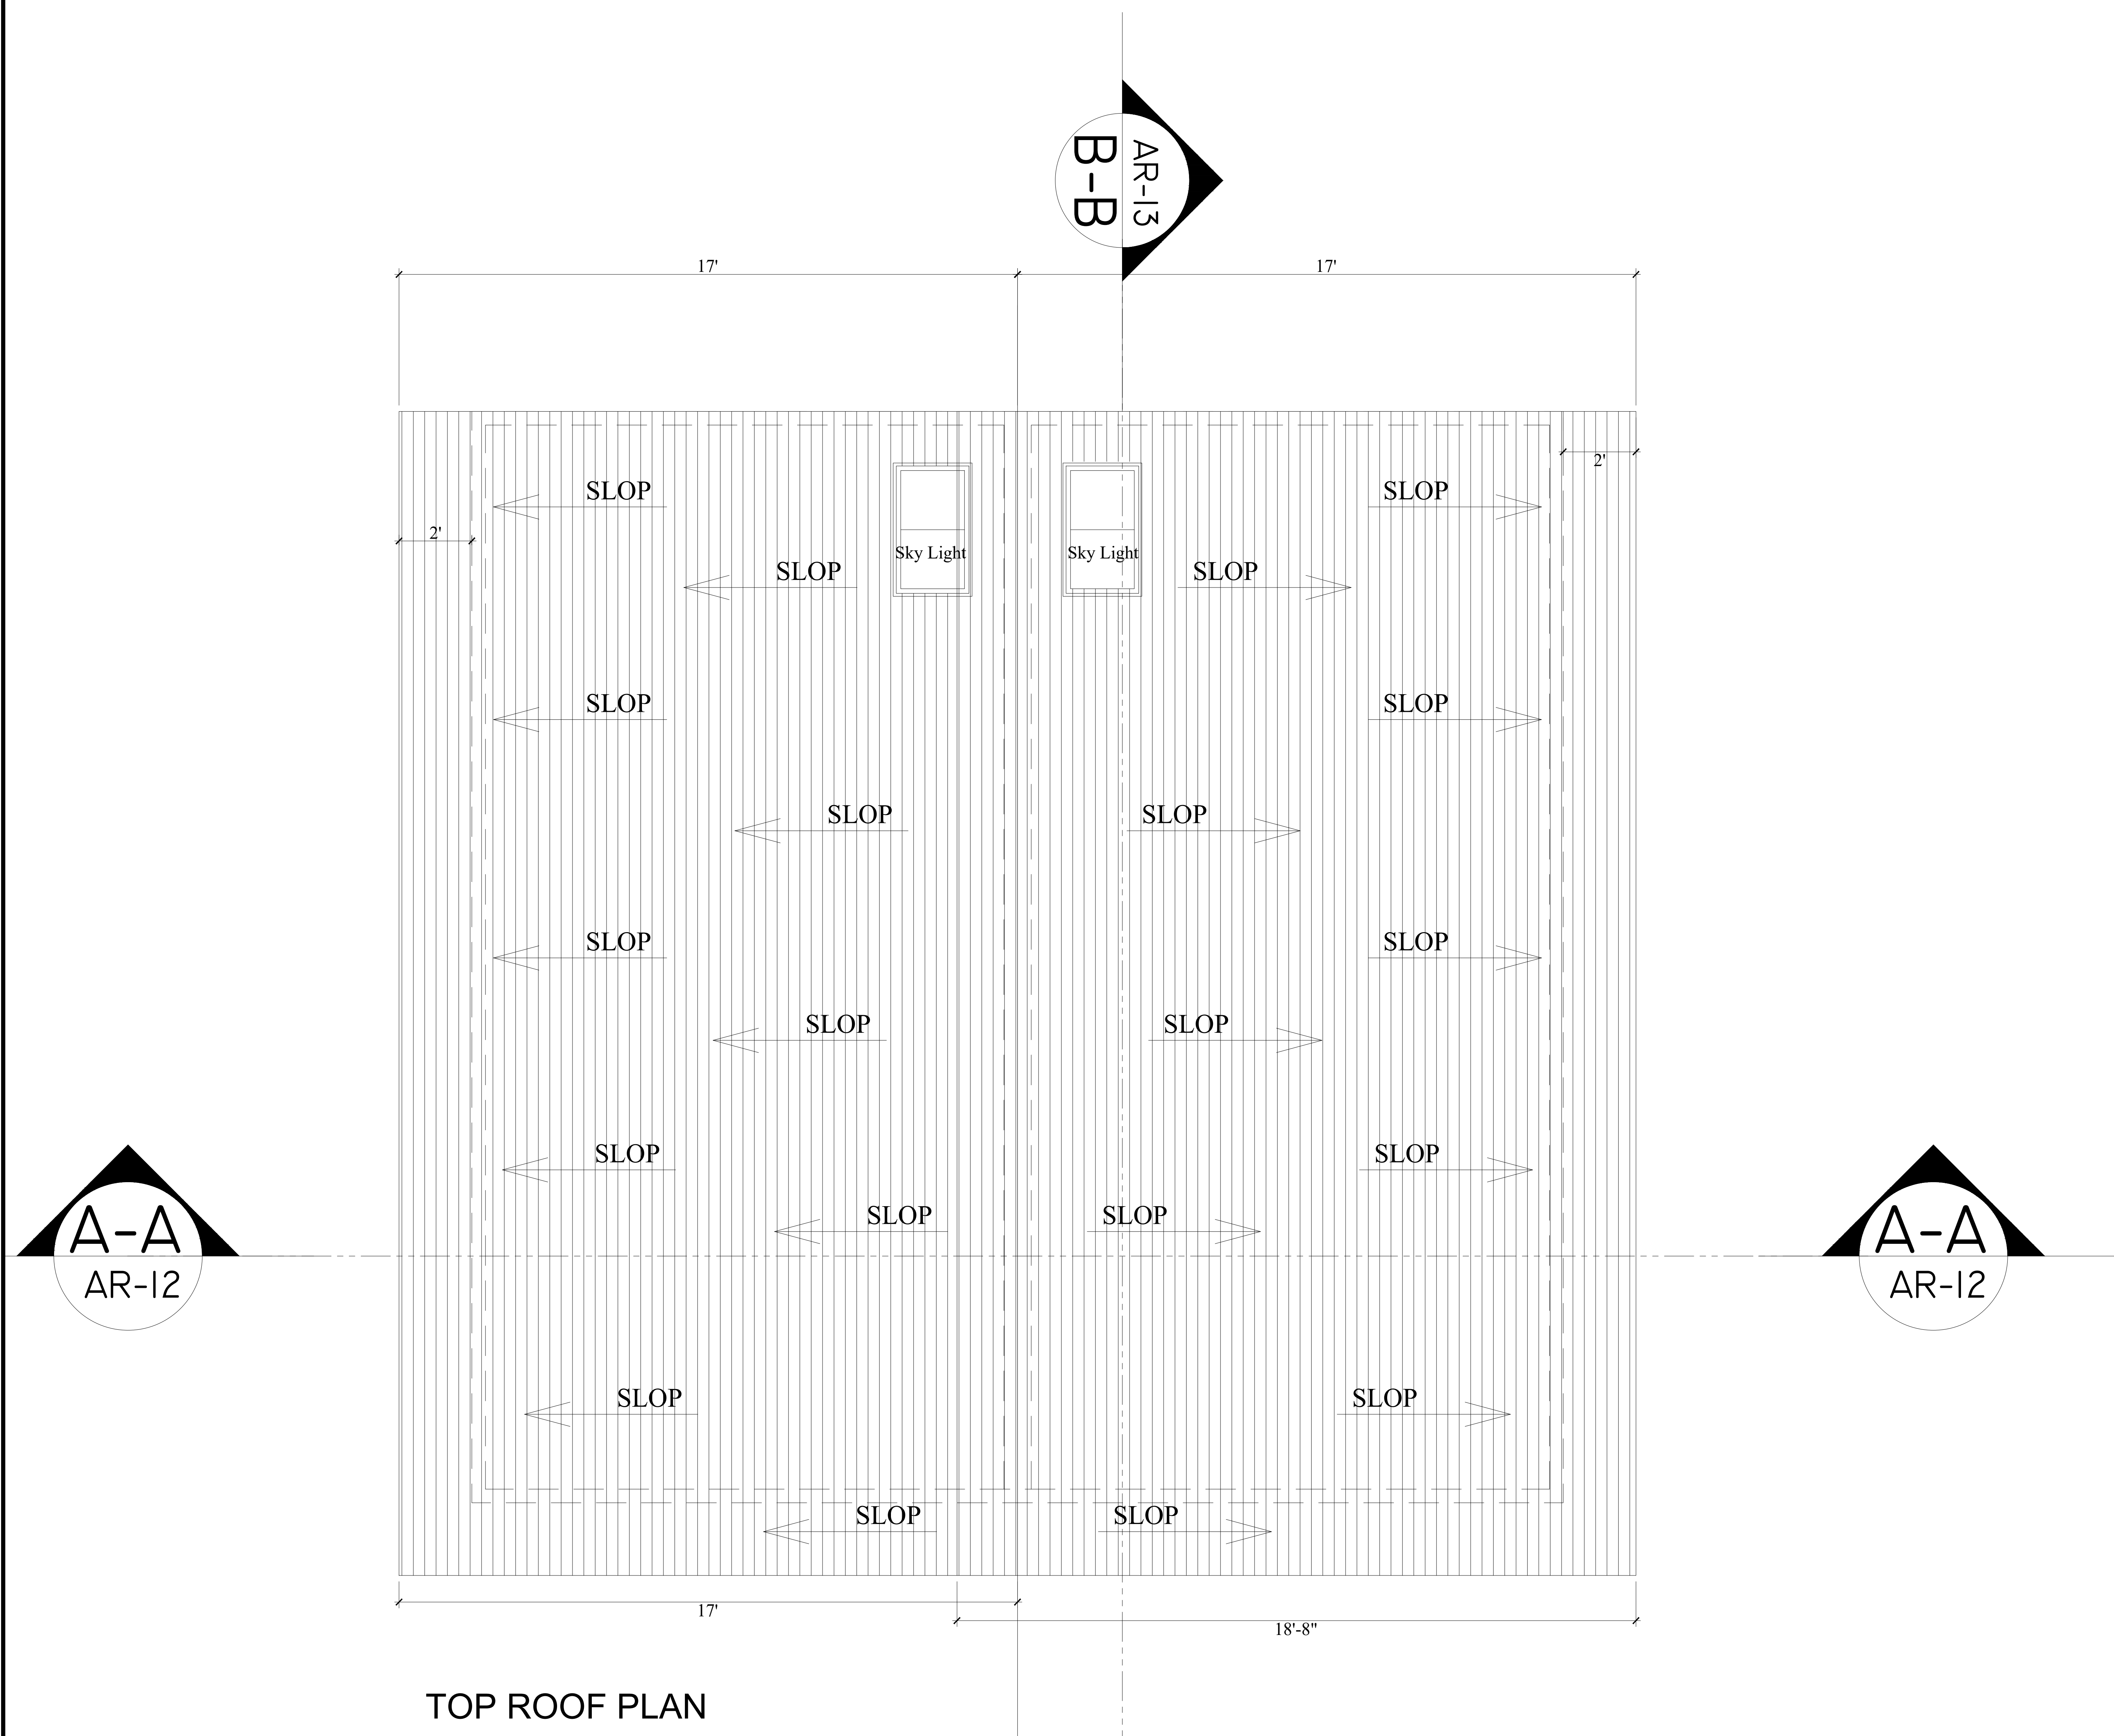

WOODEN BEAM 6"X6"

BLOCK WALL

PAINT

TILE

8'

7'

+ 2'-0"
FINISH FLOOR LEV.

SECTION E-E

SKY LIGHT

2'

PAINT

BLOCK WALL

TILE


W.C

BATH

19'-6"

+ 2'-0"
FINISH FLOOR LEV.

SECTION D-D

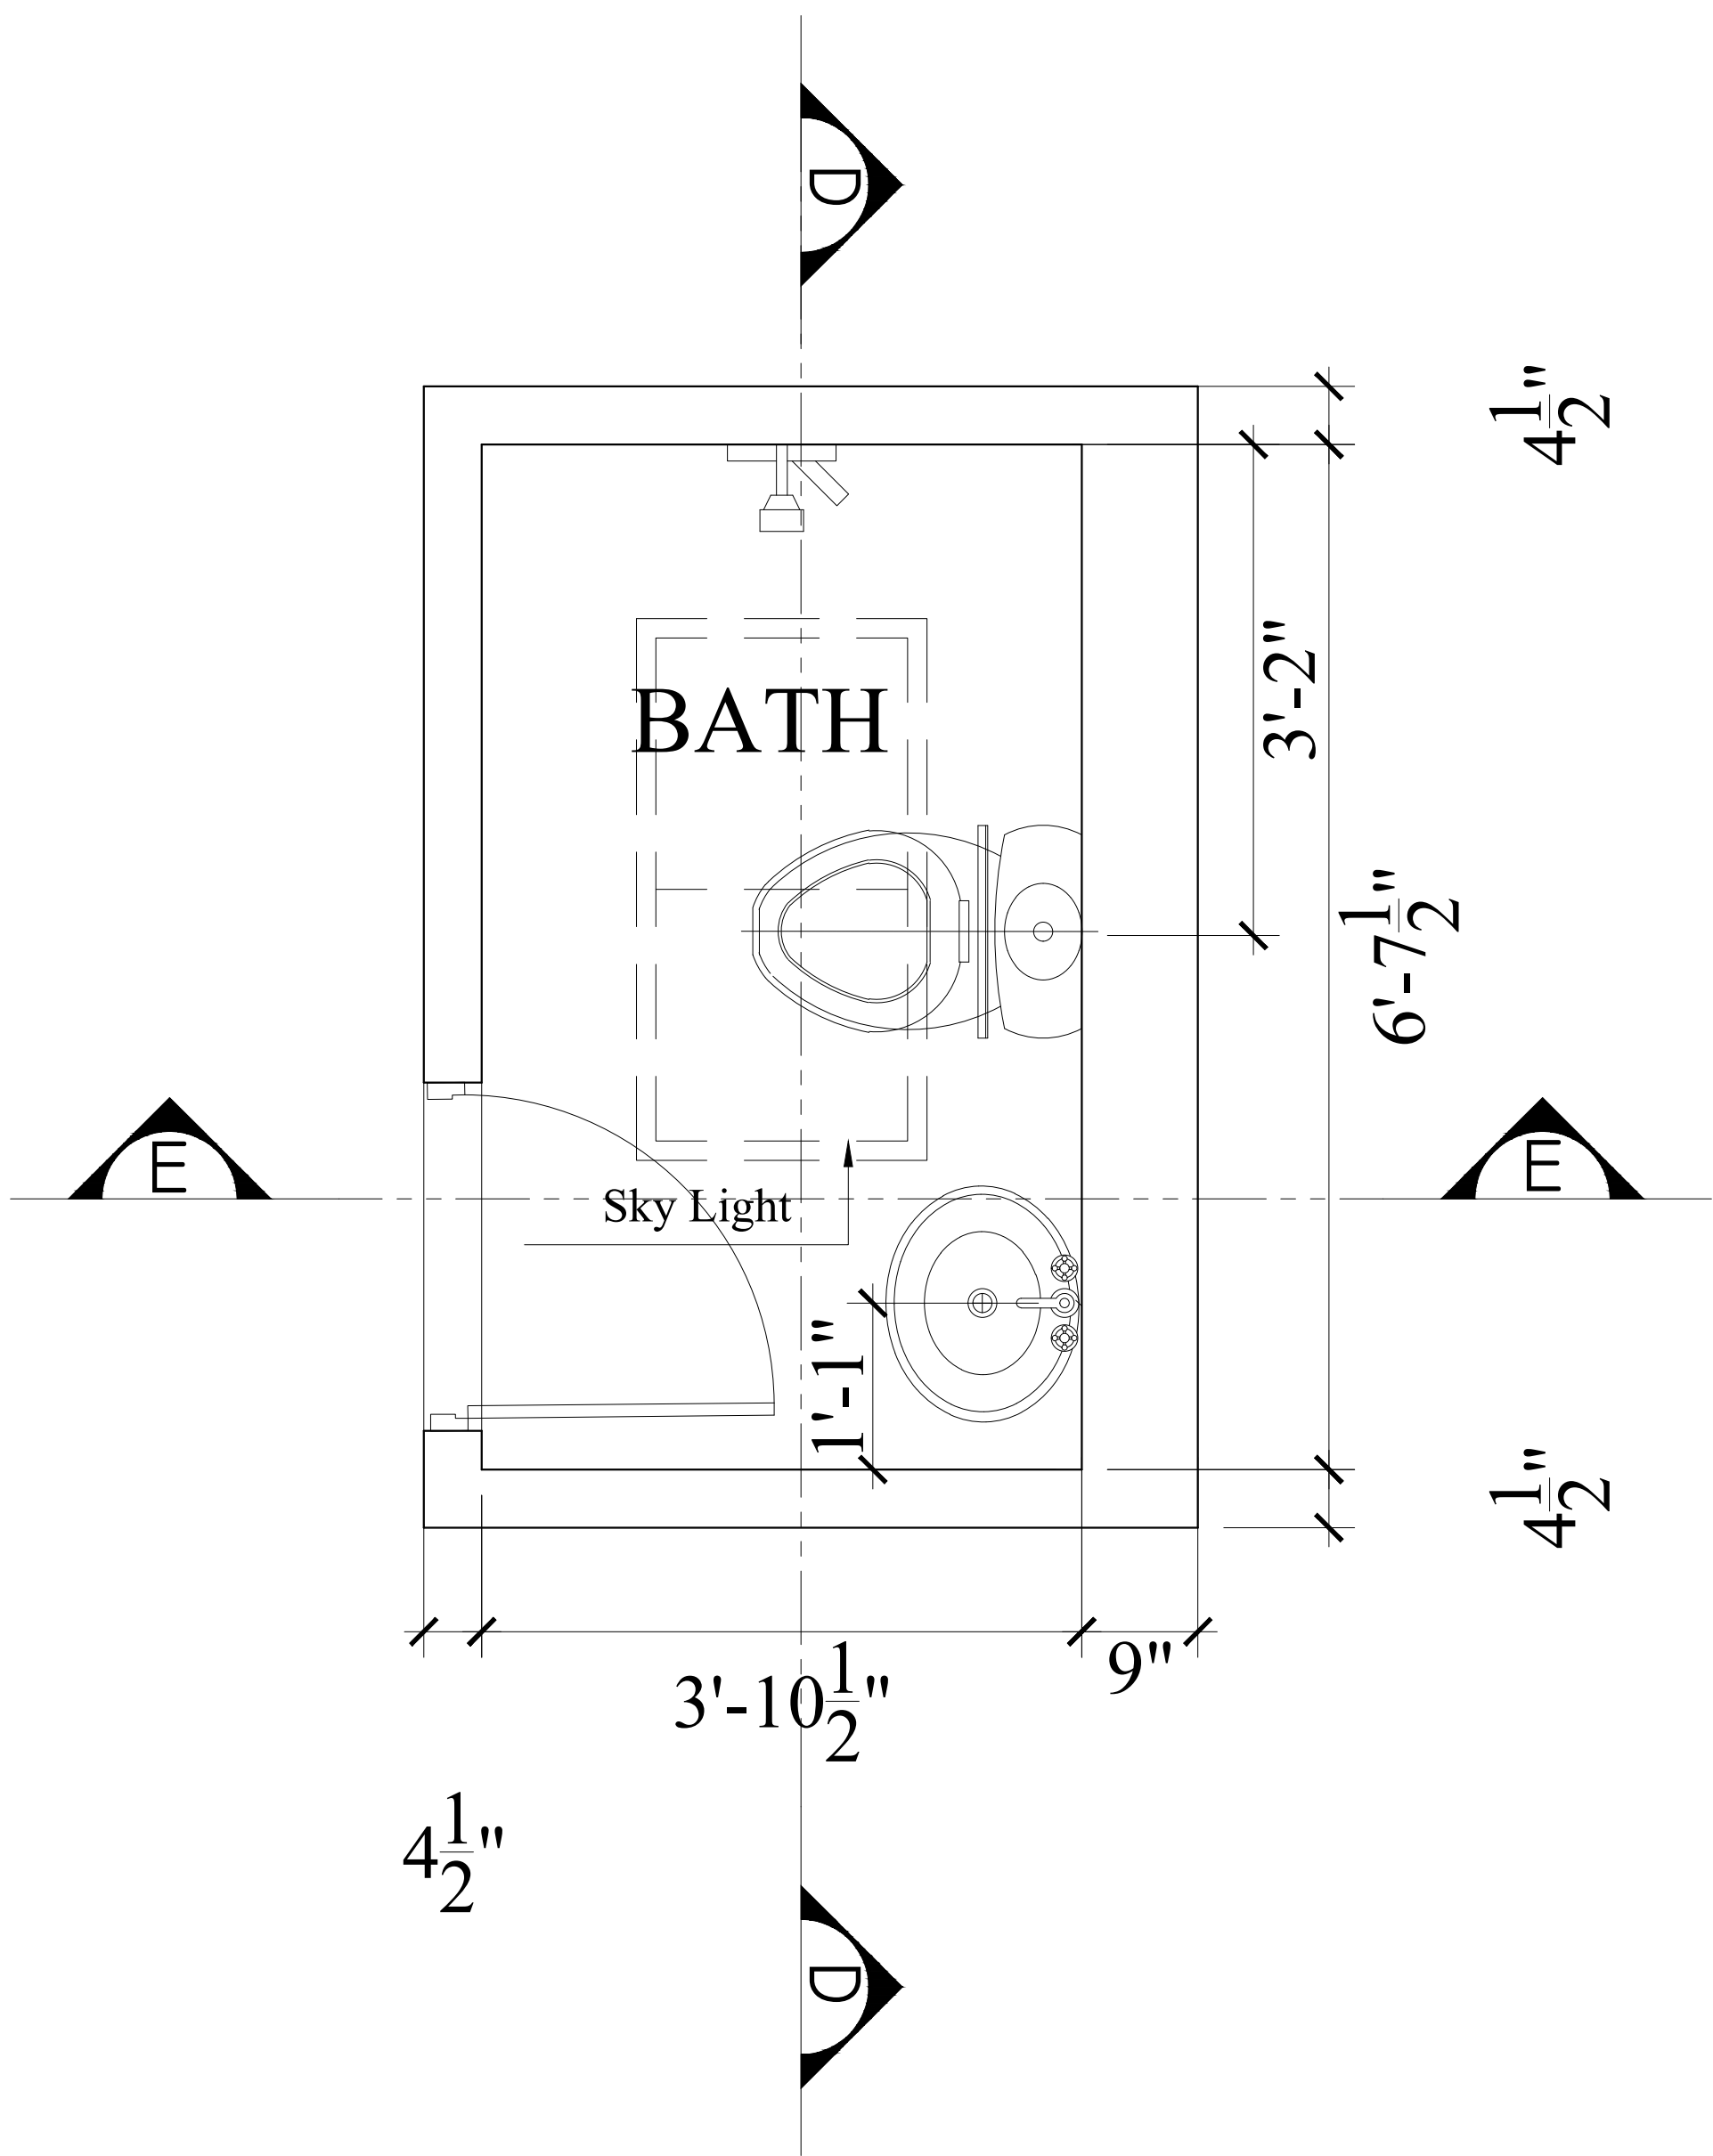

PROPOSAL DRAWINGS

BATH DETAIL

PAGE NO.

18

DRAWING NO.

AR-17

DESIGN BY:

Aqib ali

CLIENT:

PROJECT :

MURREE COTTAGE HOUSE

DRAWN BY:

Eshan

DATE:

23.08.2024








LIST OF DRAWINGS


S/N	DRAWING/TITLE	DWG#
01	LIST OF DRAWINGS	ELE-00
02	ELECTRICAL GENERAL NOTES & LEGENDS	ELE-01
03	(LIGHTING LAYOUTS)	
04	LIGHTING LAYOUTS PLAN GROUND FLOOR	ELE-02
05	ELECTRICAL SWITCH BOX DETAIL	ELE-03
06	(POWER LAYOUTS)	
07	POWER LAYOUTS PLAN GROUND FLOOR	ELE-04
08	DB-DETAIL GROUND FLOOR	ELE-05
09	EARTHING NOTES & DETAIL	ELE-06
10	(NETWORKING LAYOUTS)	ELE-07
11	NETWORKING LAYOUTS PLAN GROUND FLOOR	
12	NETWORKING SLD AND DETAIL	ELE-08

ELECTRICAL NOTES:

- 01-The contractor shall thoroughly review all the drawings before start of work and shall coordinate with all other discipline and any discrepancy appears it should be brought to the consultant's knowledge immediately, before start work.
- 02-No work shall be carried out unless shop drawing are prepared and Submitted by the contractor for the approval of consultant.
- 03-MEP services shall not cut in any structural beams, ribs or any other structural elements unless a prior written approval has been taken from the Structure Engineer.
- 04-MEP contractor shall provide sleeve/opening/pipes in civil work prior to Construction for respective services.
- 05-Provide earth pits an indicated in the drawings, it details to be coordinated with other discipline.
- 06-All electrical operated equipment shall have earth connections.
- 07-Minimum wire size shall be 1.5mm.sq for detail cable sizes see DB details given in the drawings.
- 08-Contractor shall take approval from consultant for all the material to be installed prior to purchase however, Pakistan cable,
New age and Pioneer Cable are approved.
- 09-All distributions board DB, s shall be approved by consultant prior to purchase by Contractor, Contractor provide technical submittal for DB,s.
- 10-Main and sub Telephone/TV/FACP junctions' box shall be provided where required.
- 11-All kinds of wiring shall not be visible inside or outside the Building, contractor shall place sleeve/conduits where required during constructions.
- 12-Color coding for wires shall be done and approved by IEEE regulations.
- 13-The distance for cables supports and saddle for conduit or cable tray shall be according to the latest IEEE regulations.
- 14-Use separate conduit for every circuit coming out of DBs and provide Junction box required for easy pulling electrical wire.
- 15-Fire alarm penal digital video recorder, voice control penal shall be under surveillance of security staff.
- 16-All electrical pumps motor shall be provide with starter relay.
- 17-lights layout schematic, selections of lights shall be done by the architect.
- 18-Telephone & Networking cables must be 1ft away from POWER & NETWORKING cable.

     LEGEND:

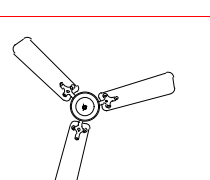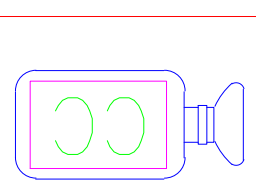
DESCRIPTION	MOUNTING HEIGHT BOTTOM FROM F.F.L.	SYMBOL	DESCRIPTION	MOUNTING HEIGHT BOTTOM FROM F.F.L.	SYMBOL
SWITCH BOARD	3'-0"		POWER PLUG 10A/15A	1'-0"	
2 WAY SWITCH POINT	3'-0"		POWER PLUG (GEYSER)	1'-0"	
HALOGEN SPOT LIGHT	CEILING		POWER PLUG (AC)	6'-0"	
EXHAUST FAN	8'-0"		TELEPHONE JUCTION BOX	WALL	
WALL LED LIGHT	7'-0"		TELE PHONE (RJ-11)	1'-0"	
DECORATED LIGHT	CEILING		TV POINT (RG-6) & LED SCREEN	1'-0"	
FAN POINT	CEILING/ 9'-0"		CCTV CAMERA	CEILING	
MIRROR LIGHT	7'-0"		WIRELESS FIDELITY	WALL	
FLUORESCENT LIGHT	CEILING		GESIER POINT	5'-0"	
IDUN LIGHT	CEILING		FANCY LIGHTS MAIN GATE LIGHT	Column pillar main gate	
DISTRIBUTION BOARD	4'-0"		WATER PROOF LIGHT	WALL	
ELECTRIC BELL	7'-0"		BELL PUSH BUTTON	4'-0"	
LIGHT PLUG 5A/10A	1'-0"		ELECTRIC METER	4'-0"	

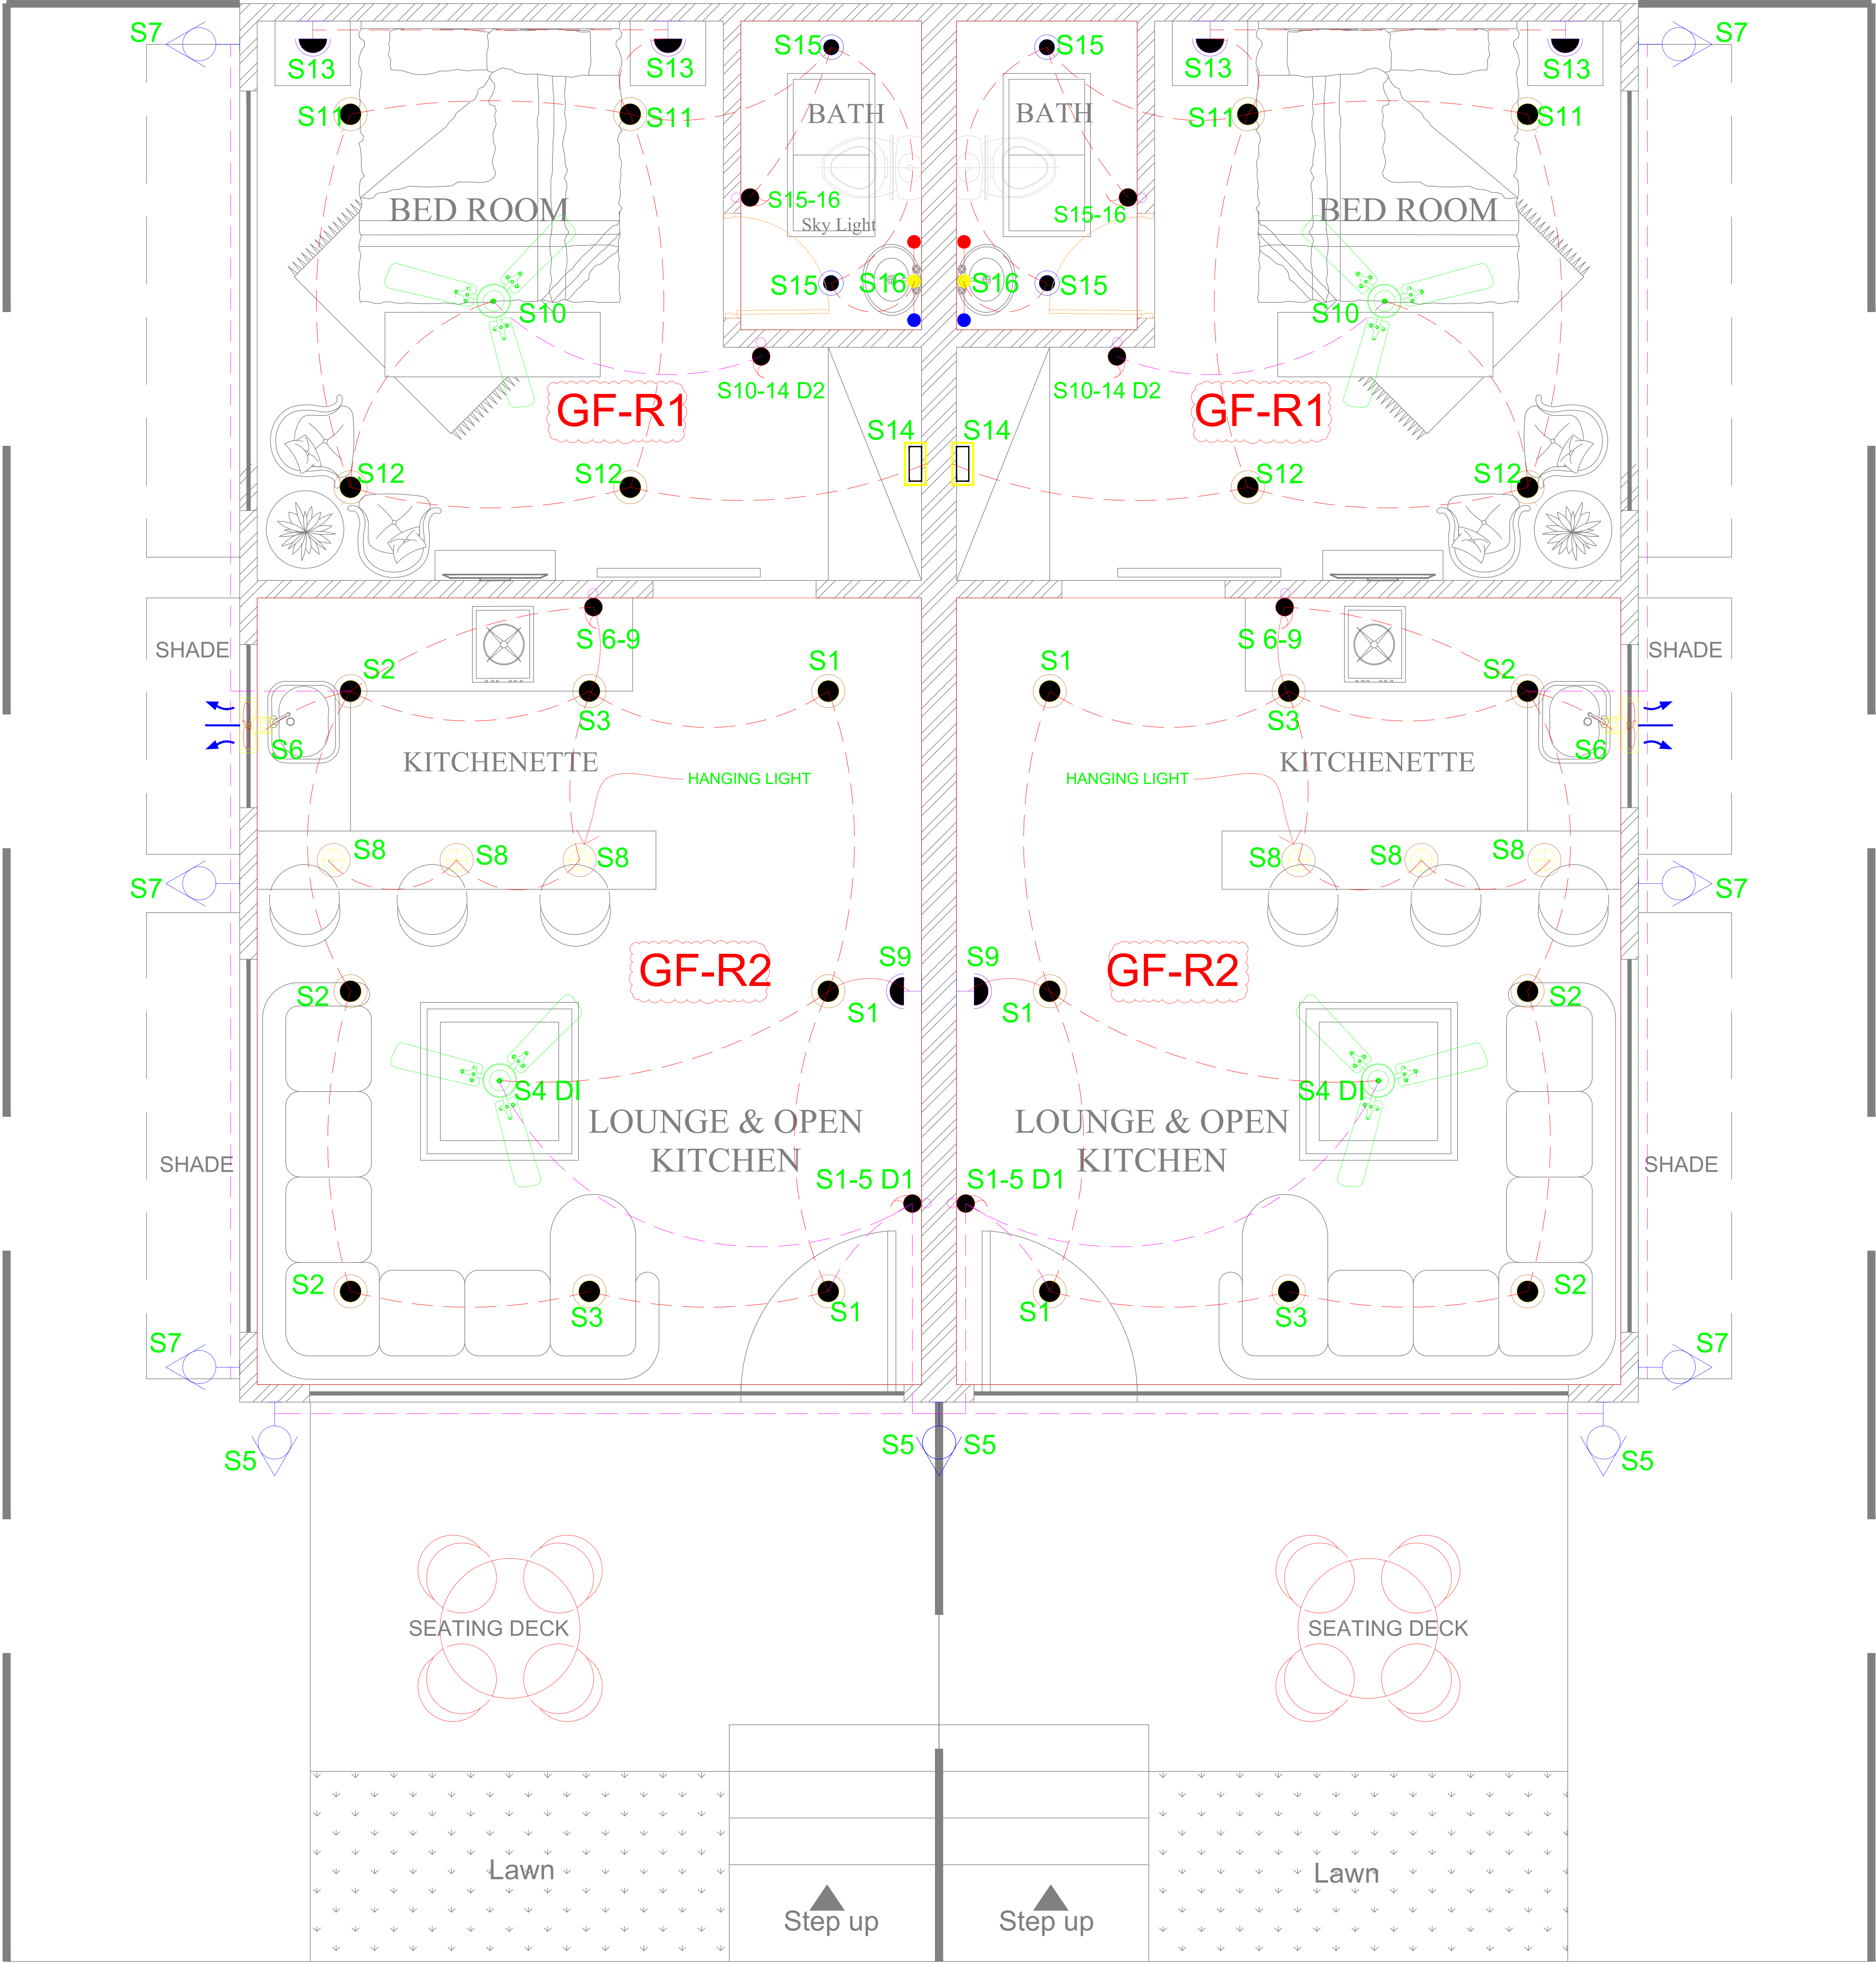


GROUND FLOOR PLAN
LIGHTING LAYOUTS PLAN

 PROPOSAL DRAWINGS	PAGE NO. 03	DRAWING NO. ELE-02	DESIGN BY: Aqib ali
	CLIENT: _____	PROJECT : MURREE COTTAGE HOUSE	DRAWN BY: Eshan
			DATE: 20.08.2024


LIGHTING LAYOUT PLAN
GROUND FLOOR

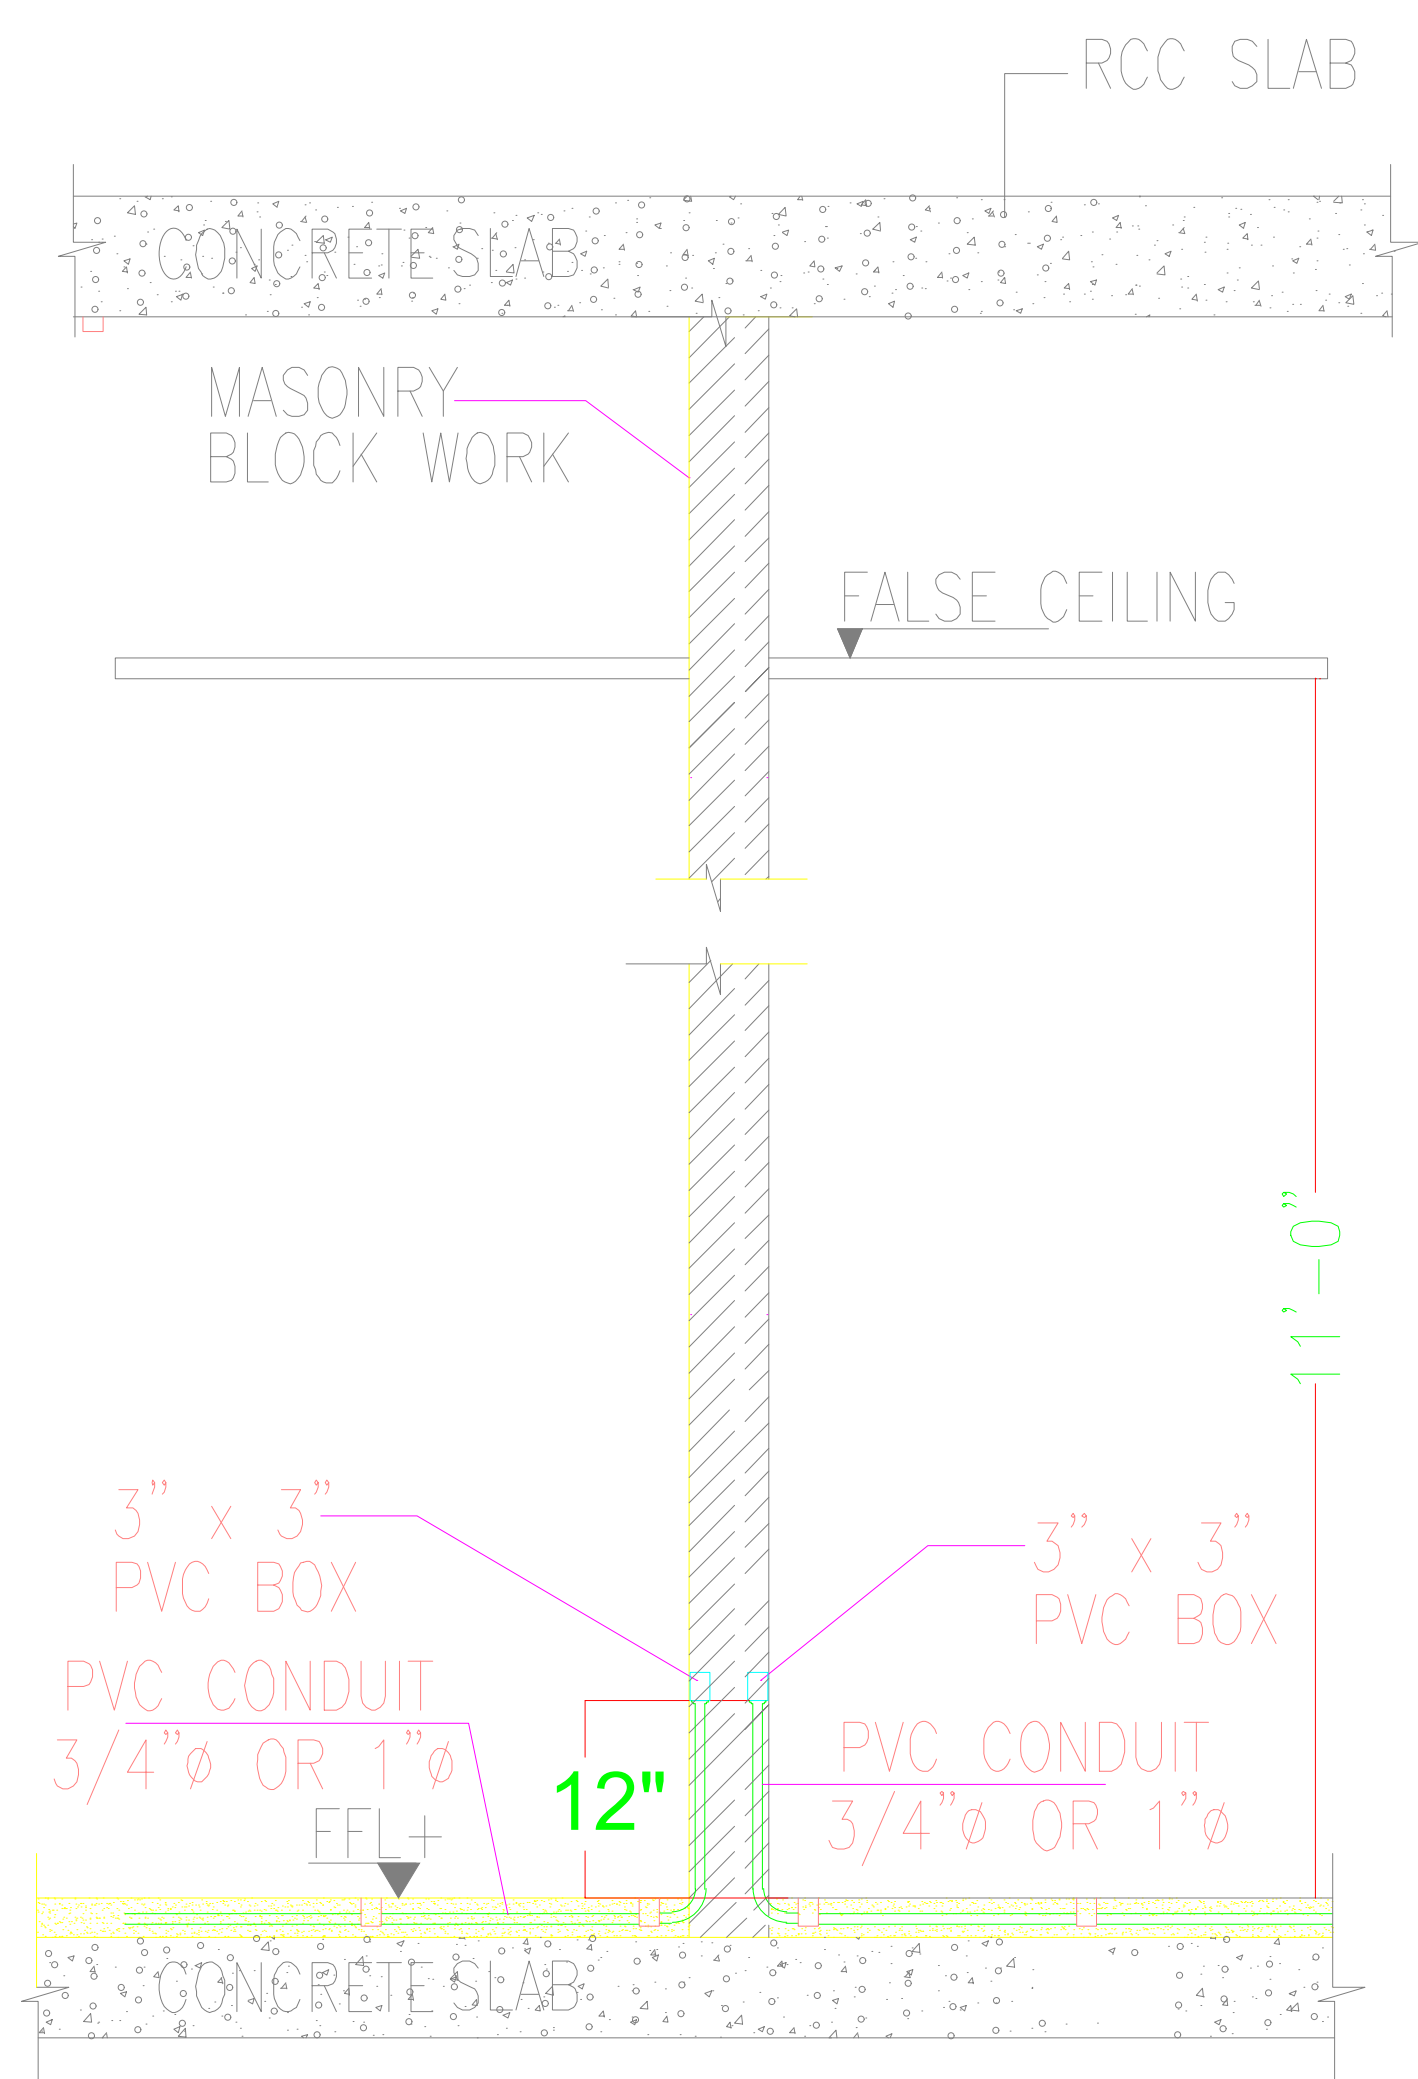


G TYPICAL OUTLET MOUNTING DETAIL
NTS

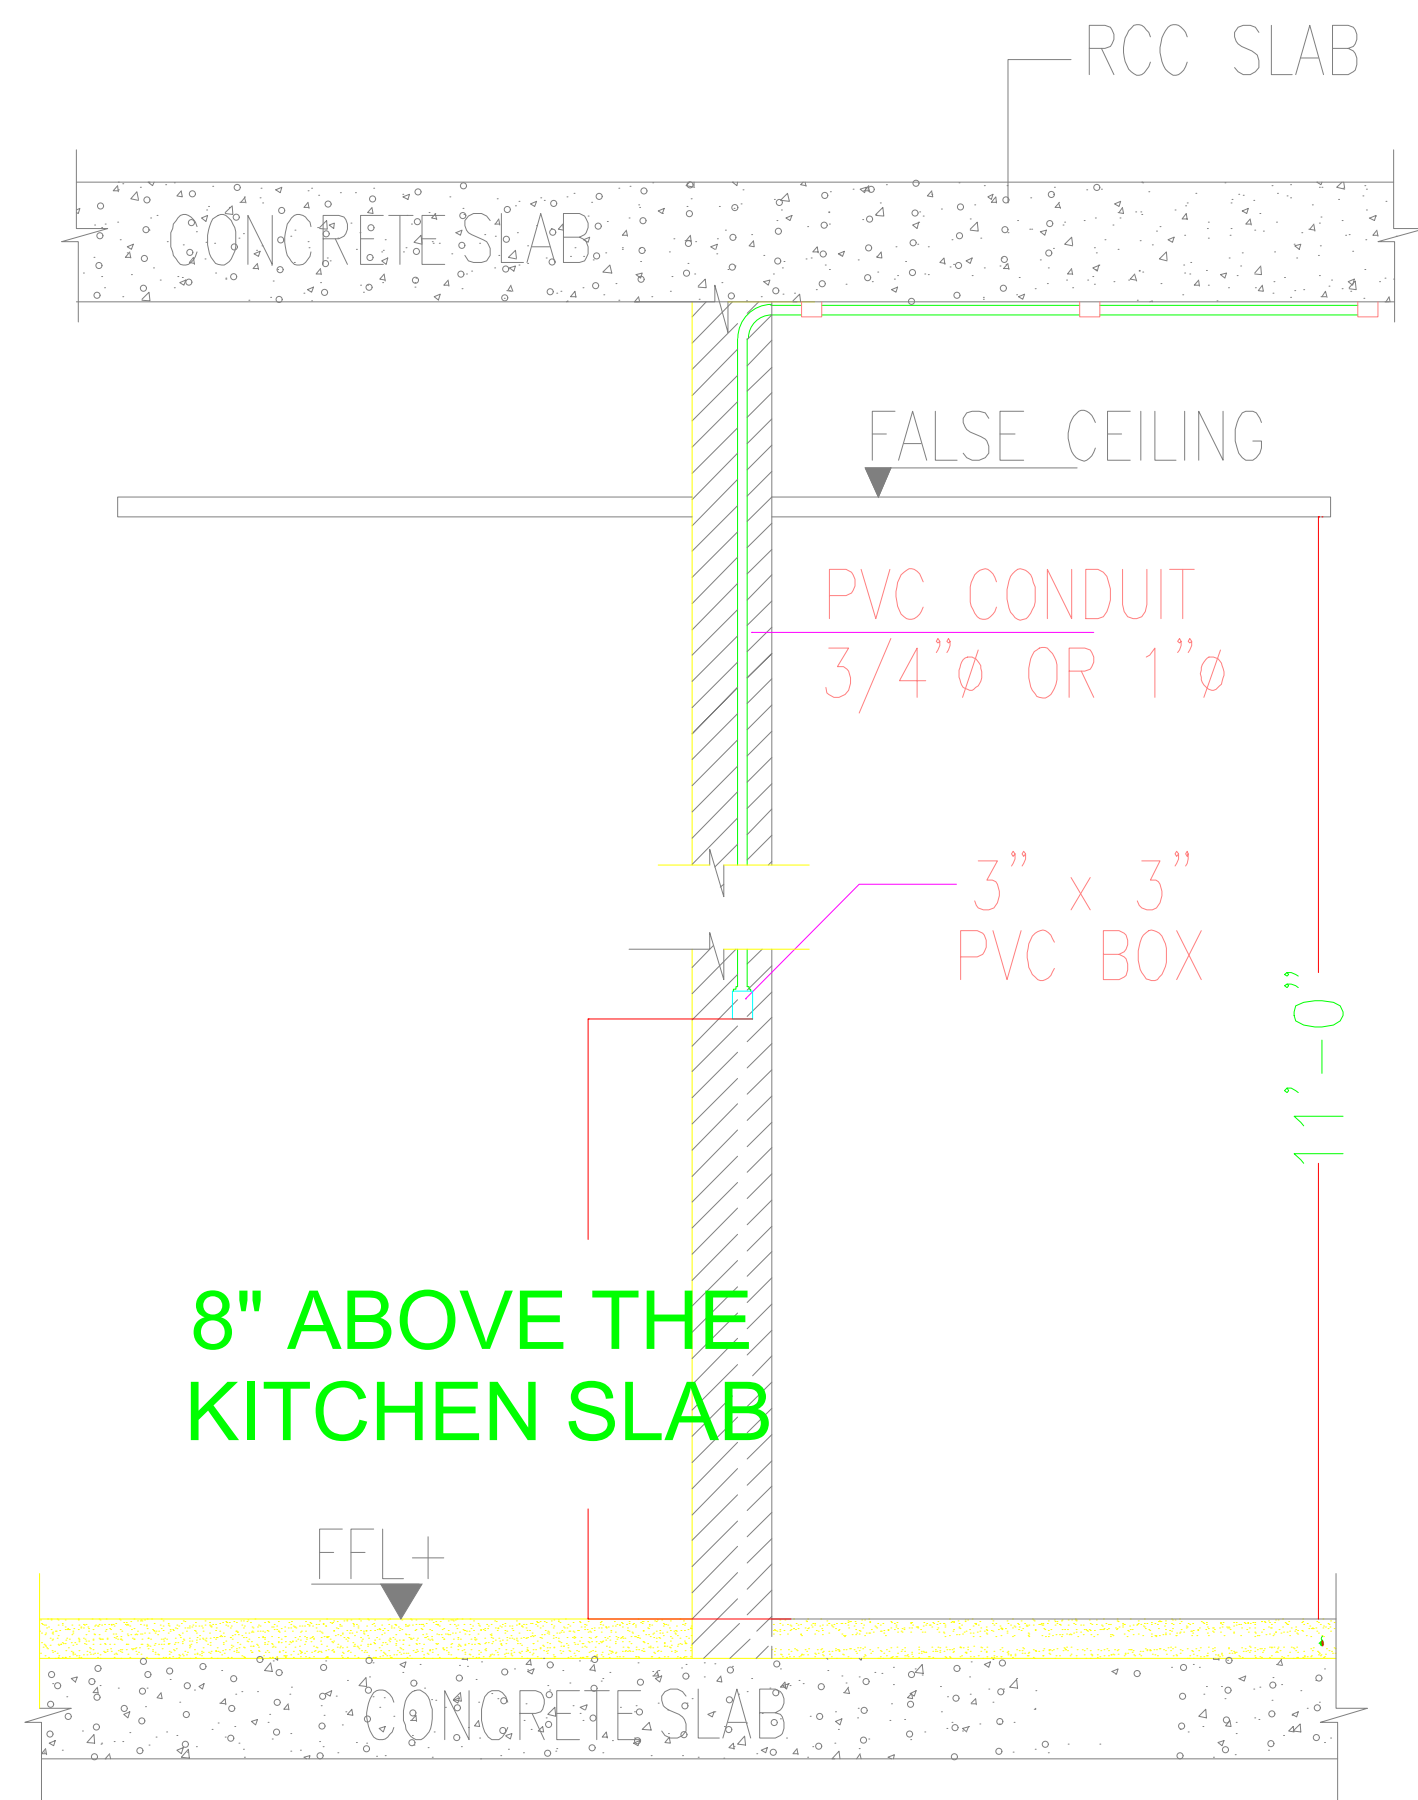

C 13A SOCKET OUTLET INSTALLATION
DETAILS FOR KITCHEN
NTS

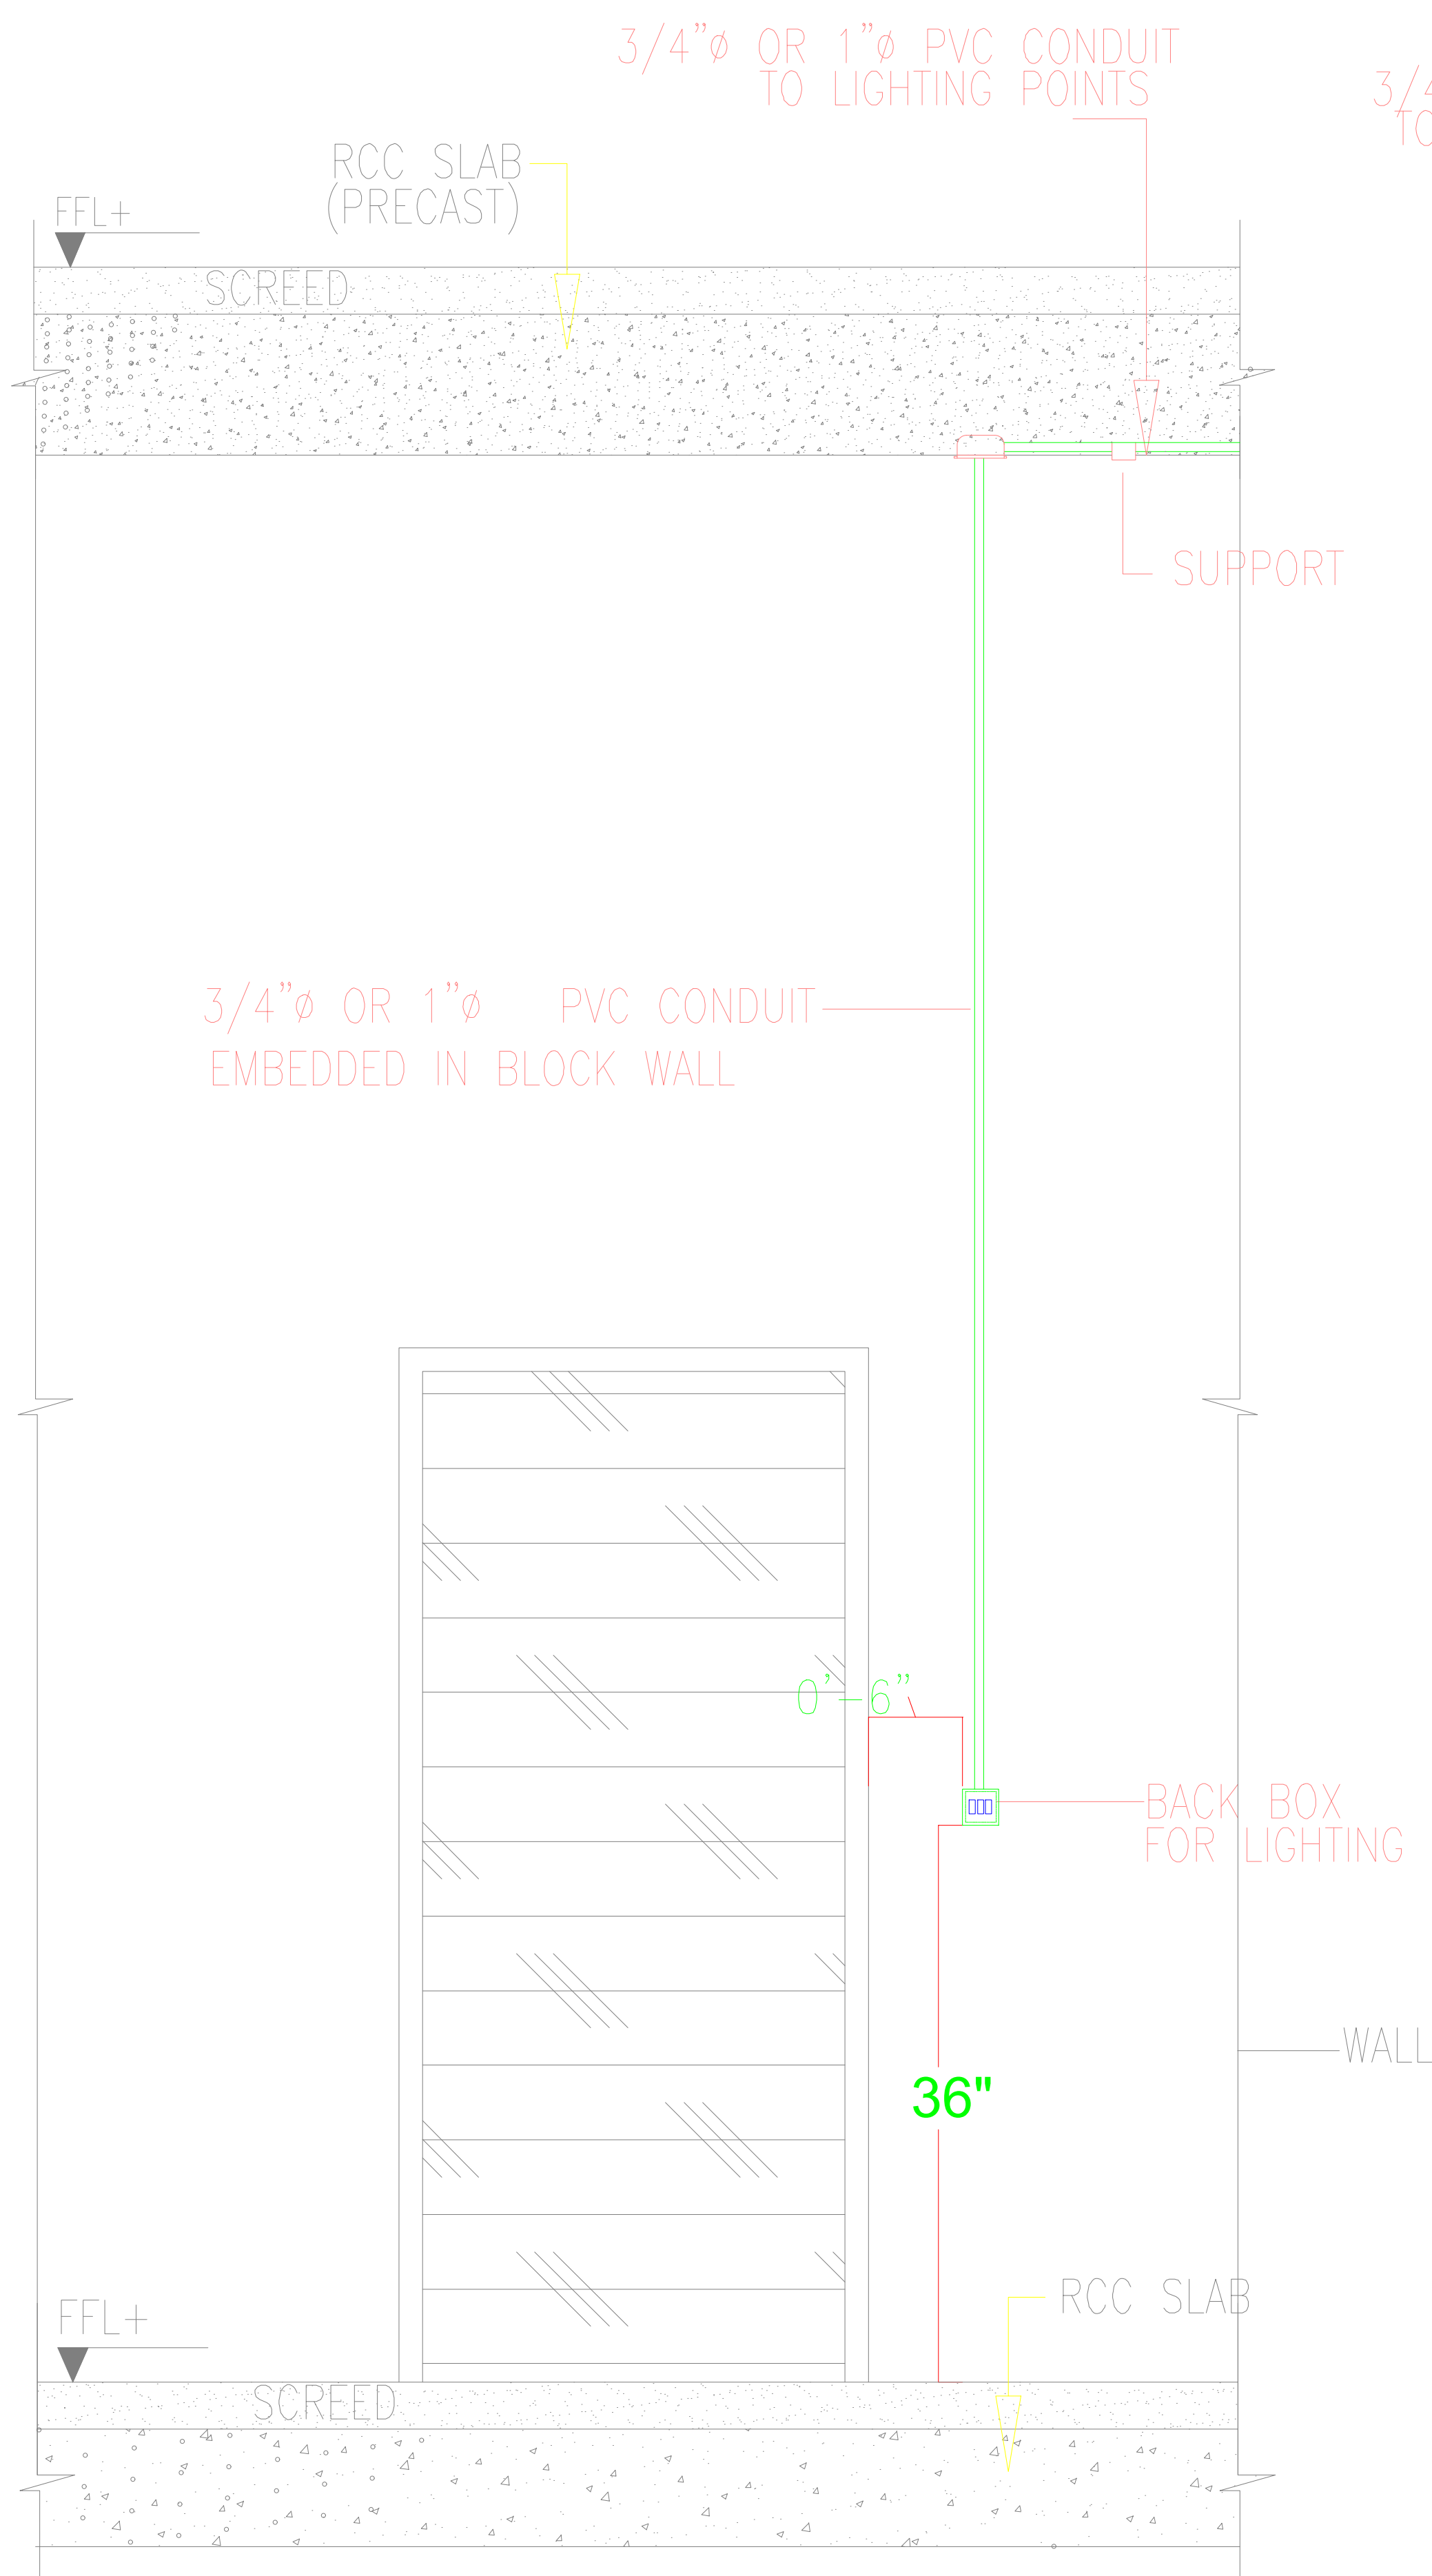


ELEVATION

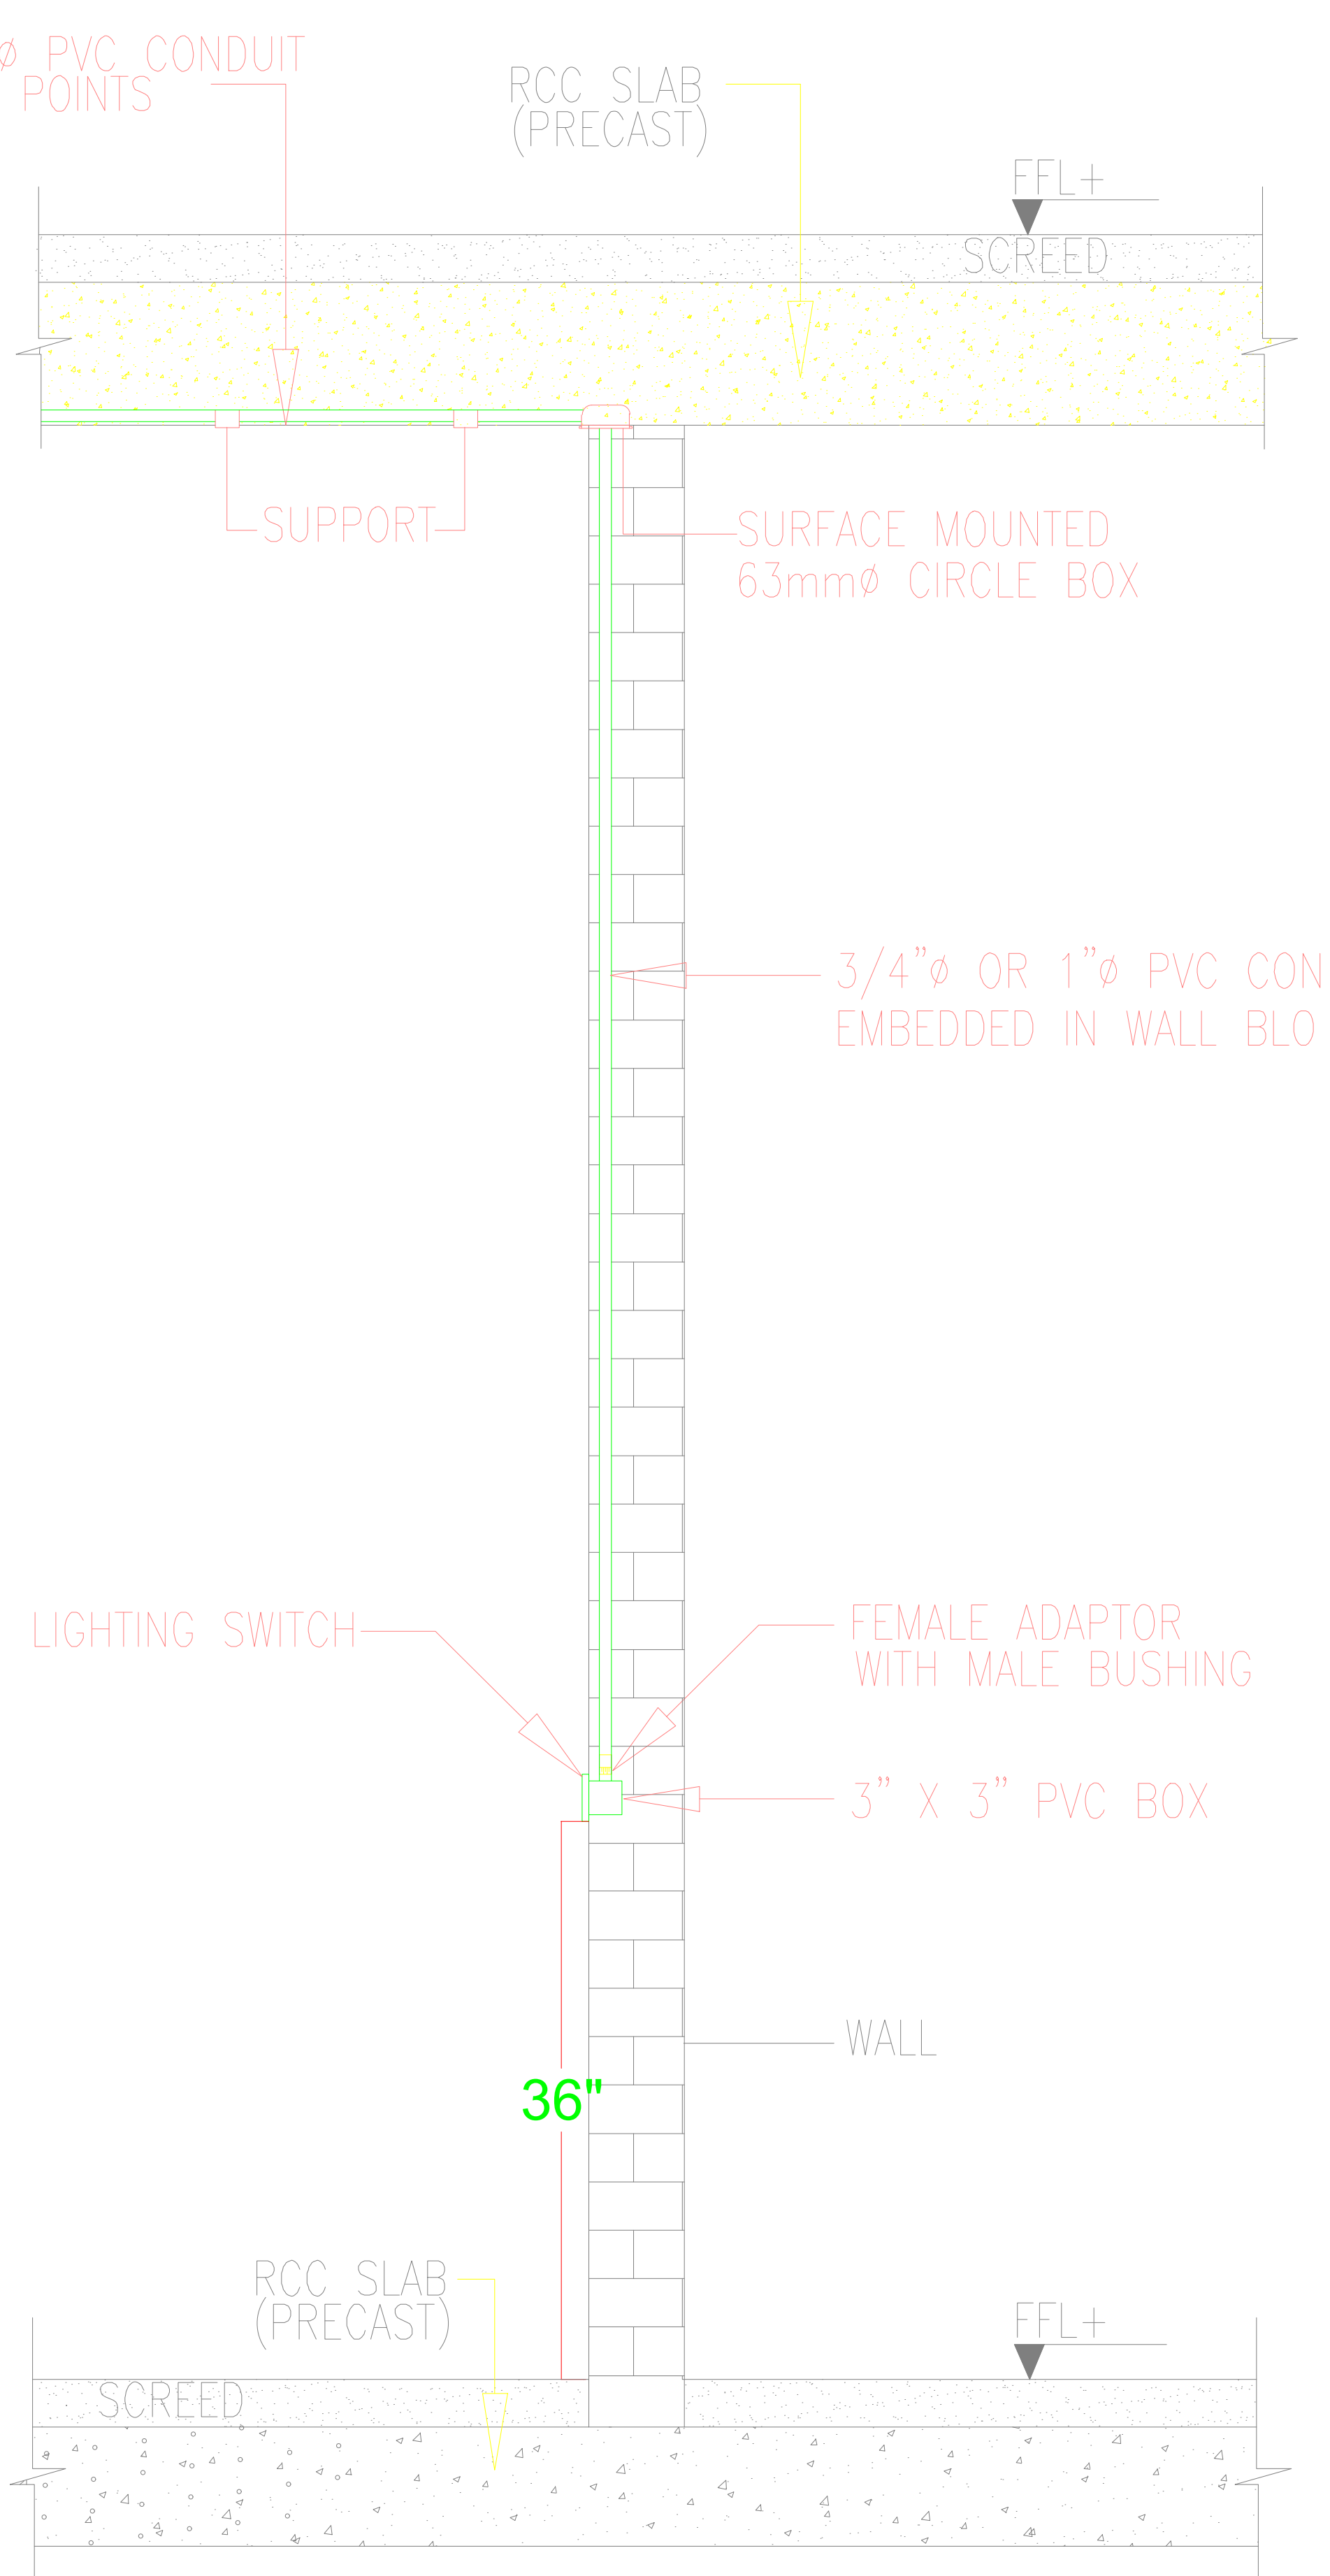

SECTION



E LIGHTING SWITCH INSTALLATION DETAIL
NTS

ELECTRICAL SWITCH BOX DETAIL

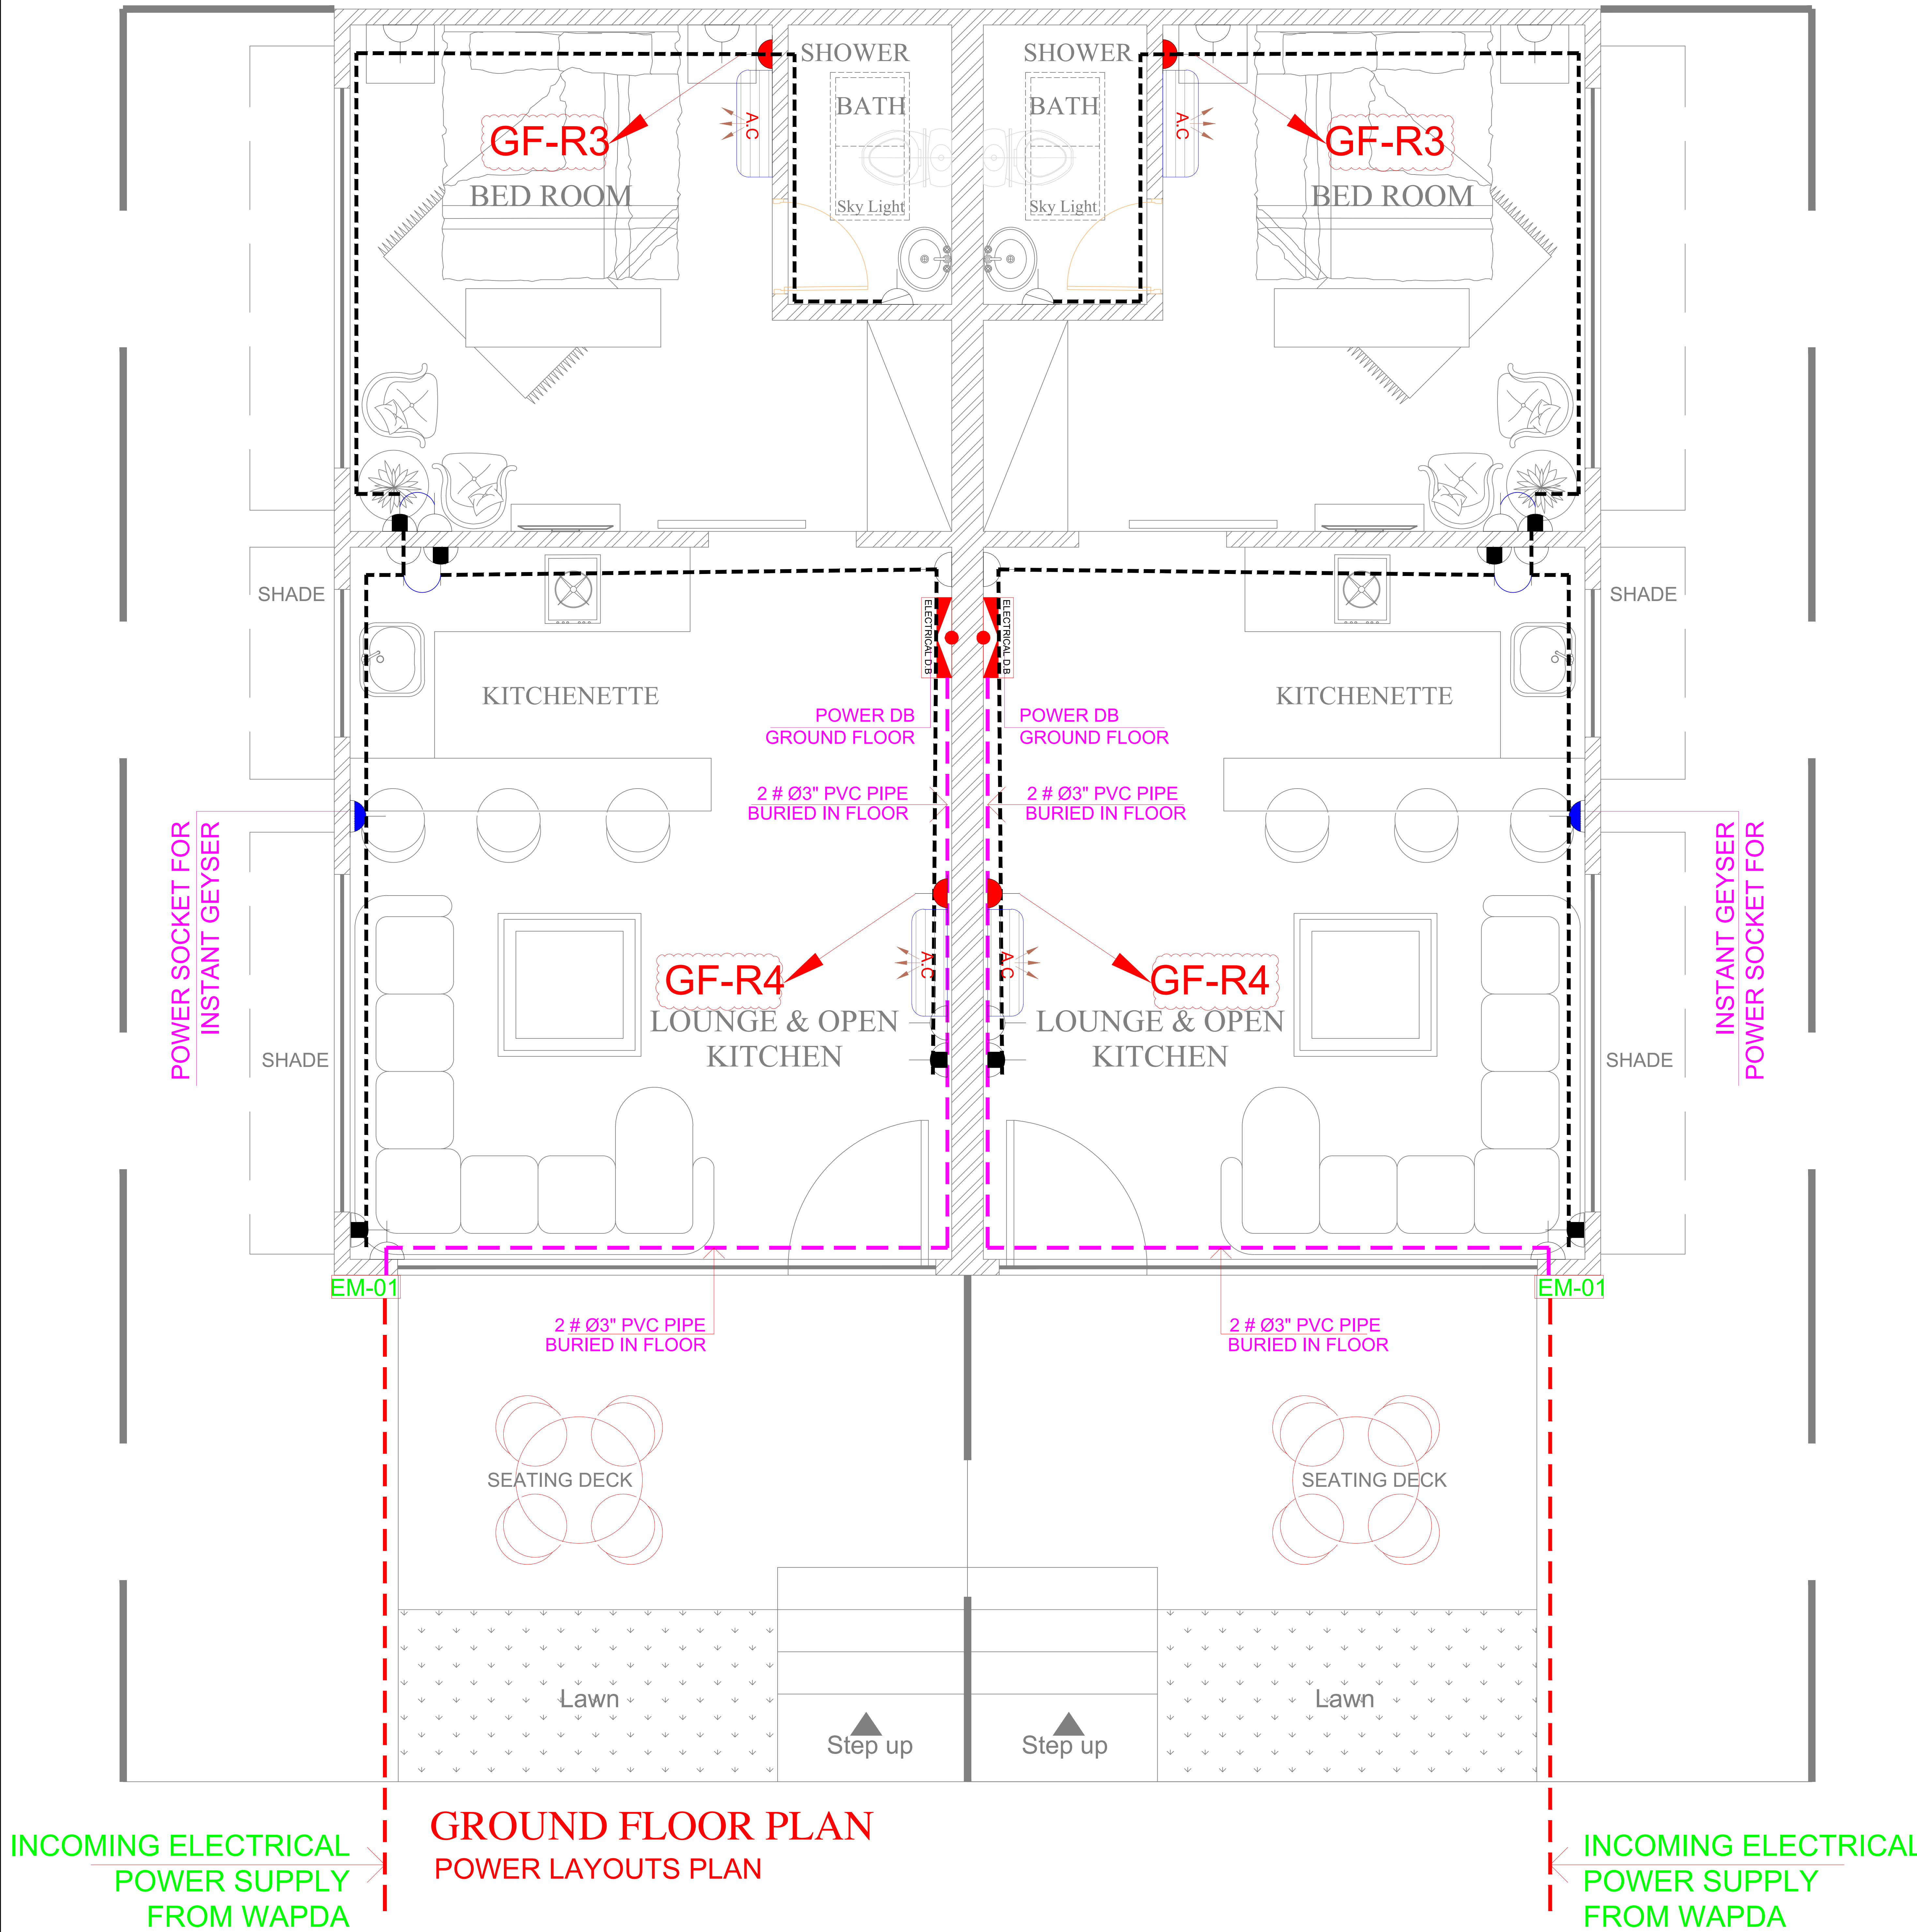


NOTES FOR EARTHING SYSTEM

- 1- EARTH BORE SHALL BE MADE AT 6'-0" AWAY FROM FOUNDATION.
- 2- DISTANCE BETWEEN 2 EARTH BORES SHALL NOT BE LESS THEN 10 ft (3m)
- 3- COPPER CONDUCTOR AT TOP OF G.I PIPE SHALL BE BOLTED WITH THIMBLES, BRASS NUTS, BOLTS ETC.
- 4- JOINTS SHALL BE COVERED WITH BITUMEN
- 5- CONTRACTOR TO MEASURE EARTHING RESISTANCE IN THE PRESENCE OF SITE ENGINEER. BOTH THE SITE ENGINEER AND CONTRACTOR SHALL SIGN THE EARTH TESTING RESULT AND SUBMIT IT TO THE CLIENT FOR RECORD.

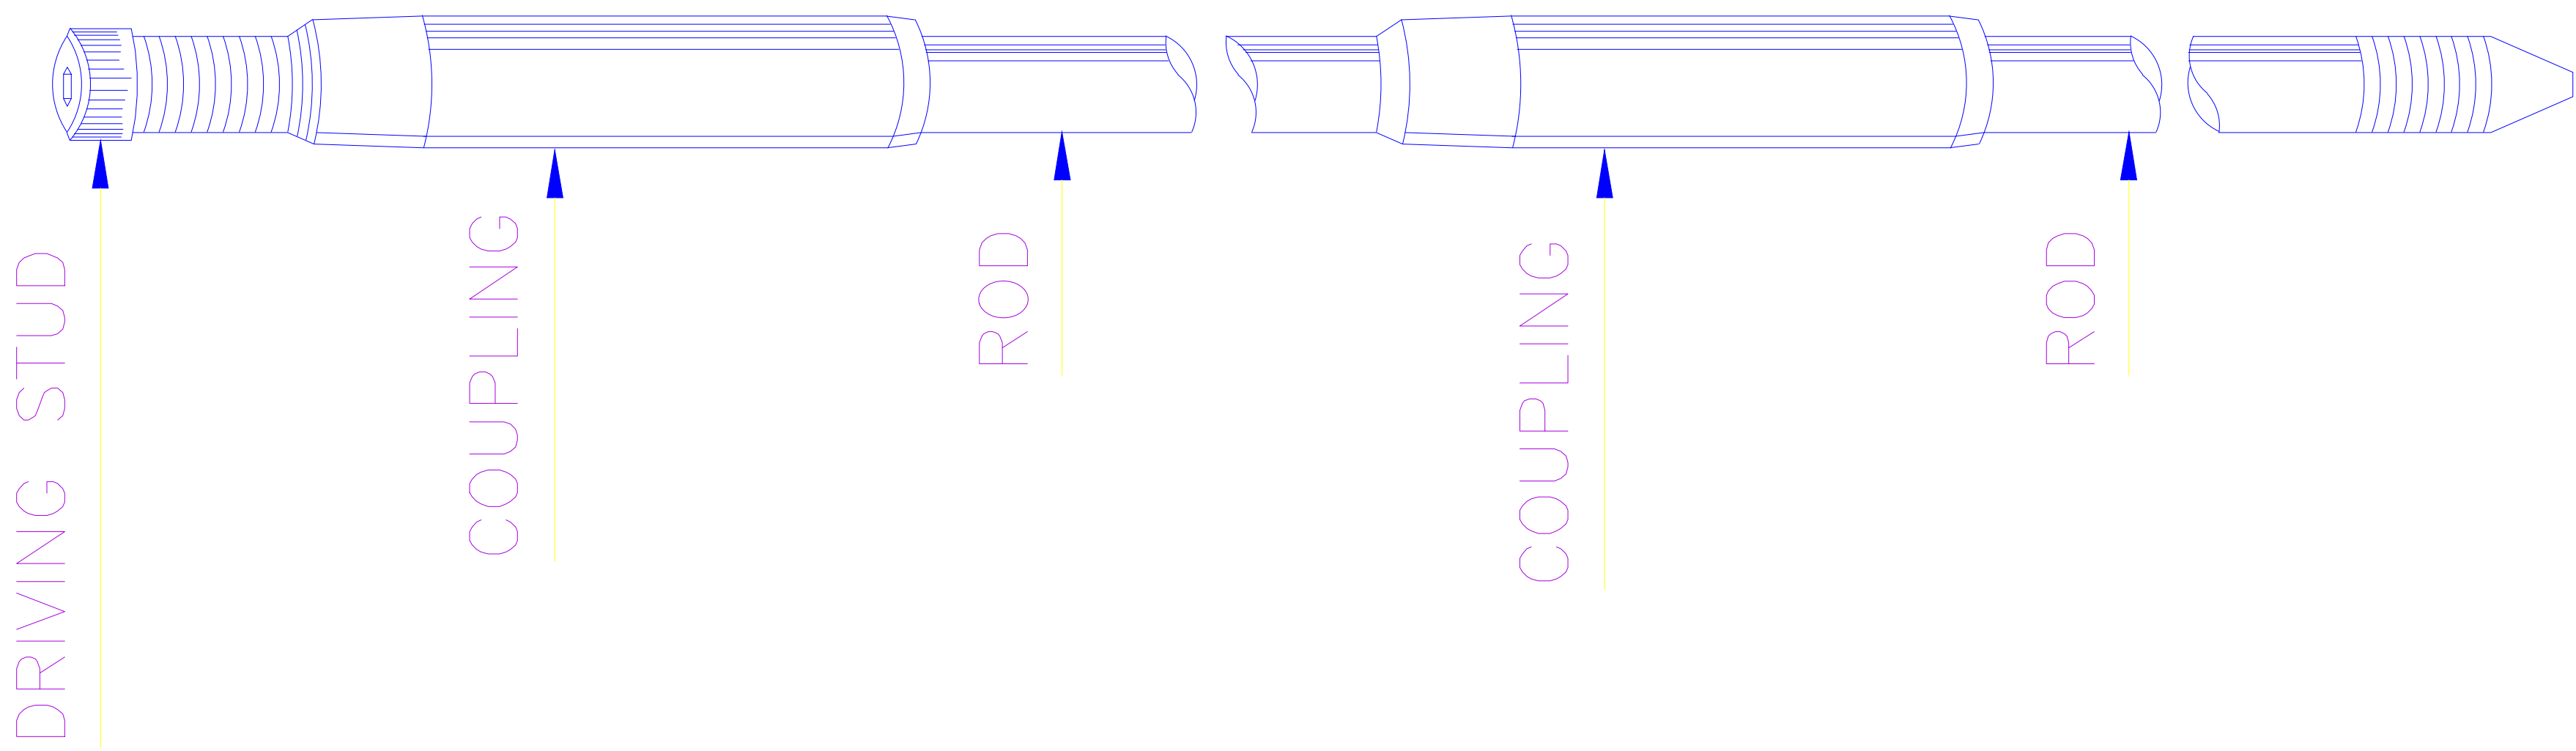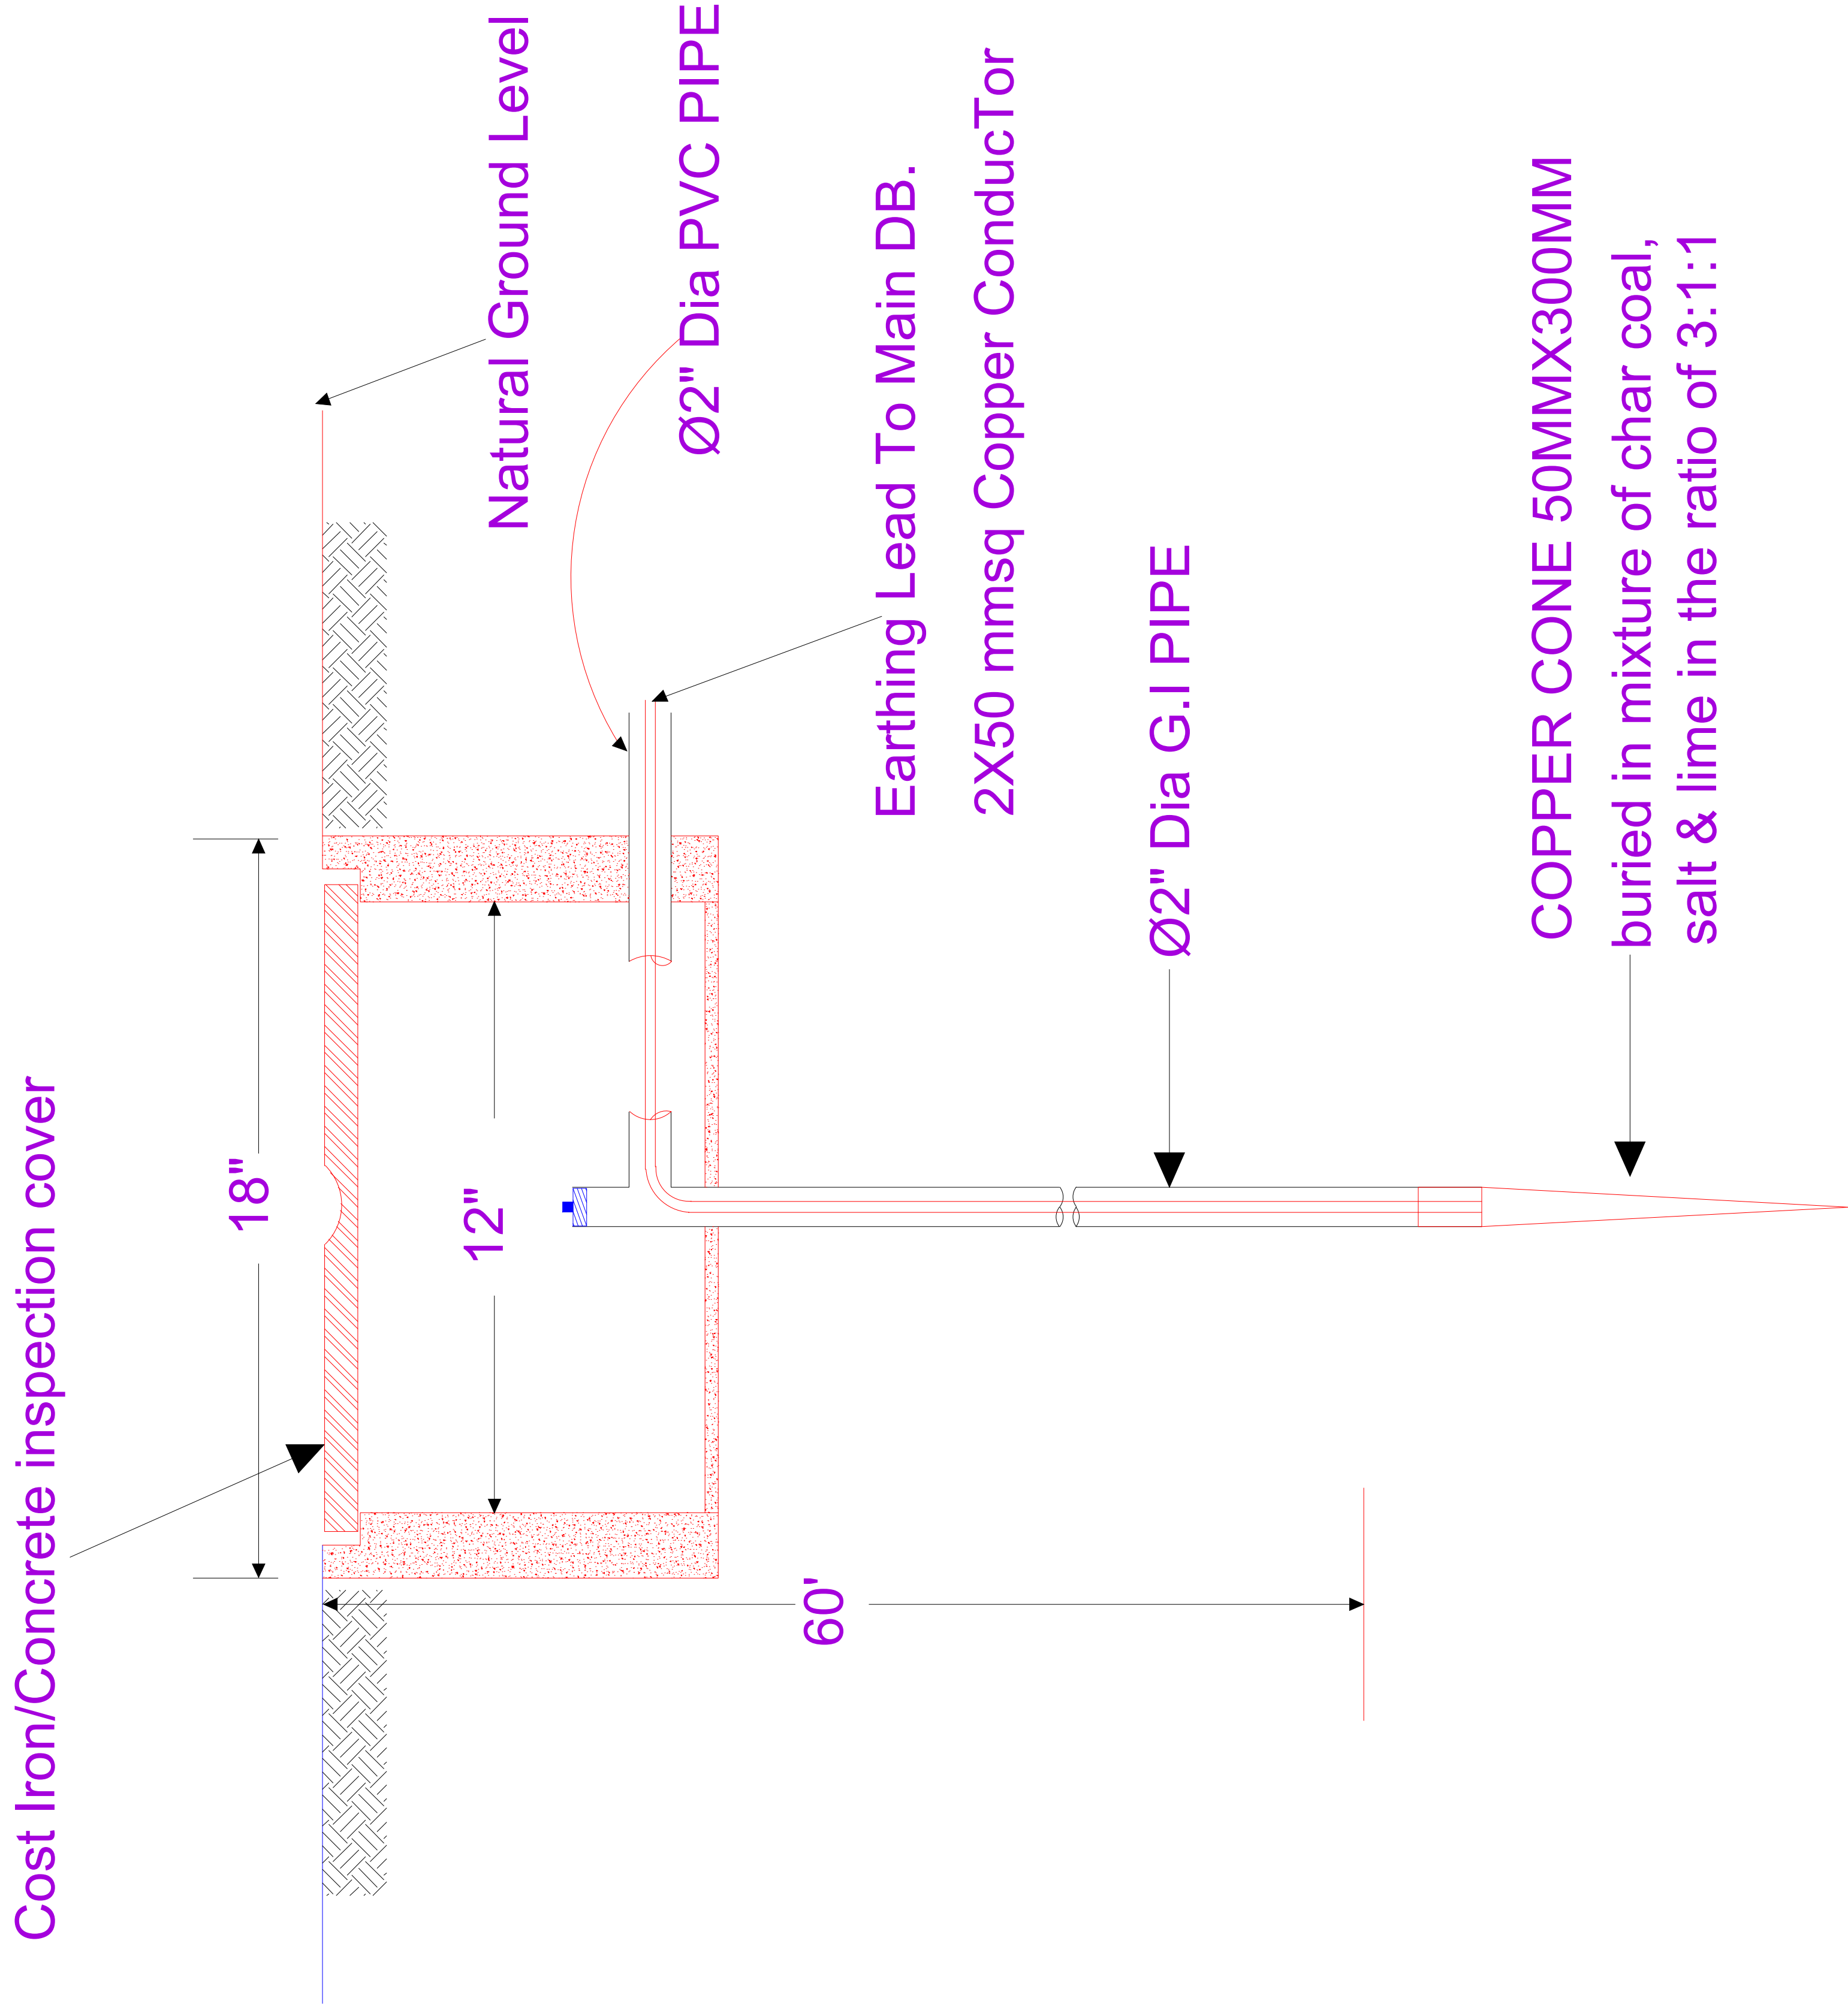

DETAIL OF EARTHING ELECTRODE



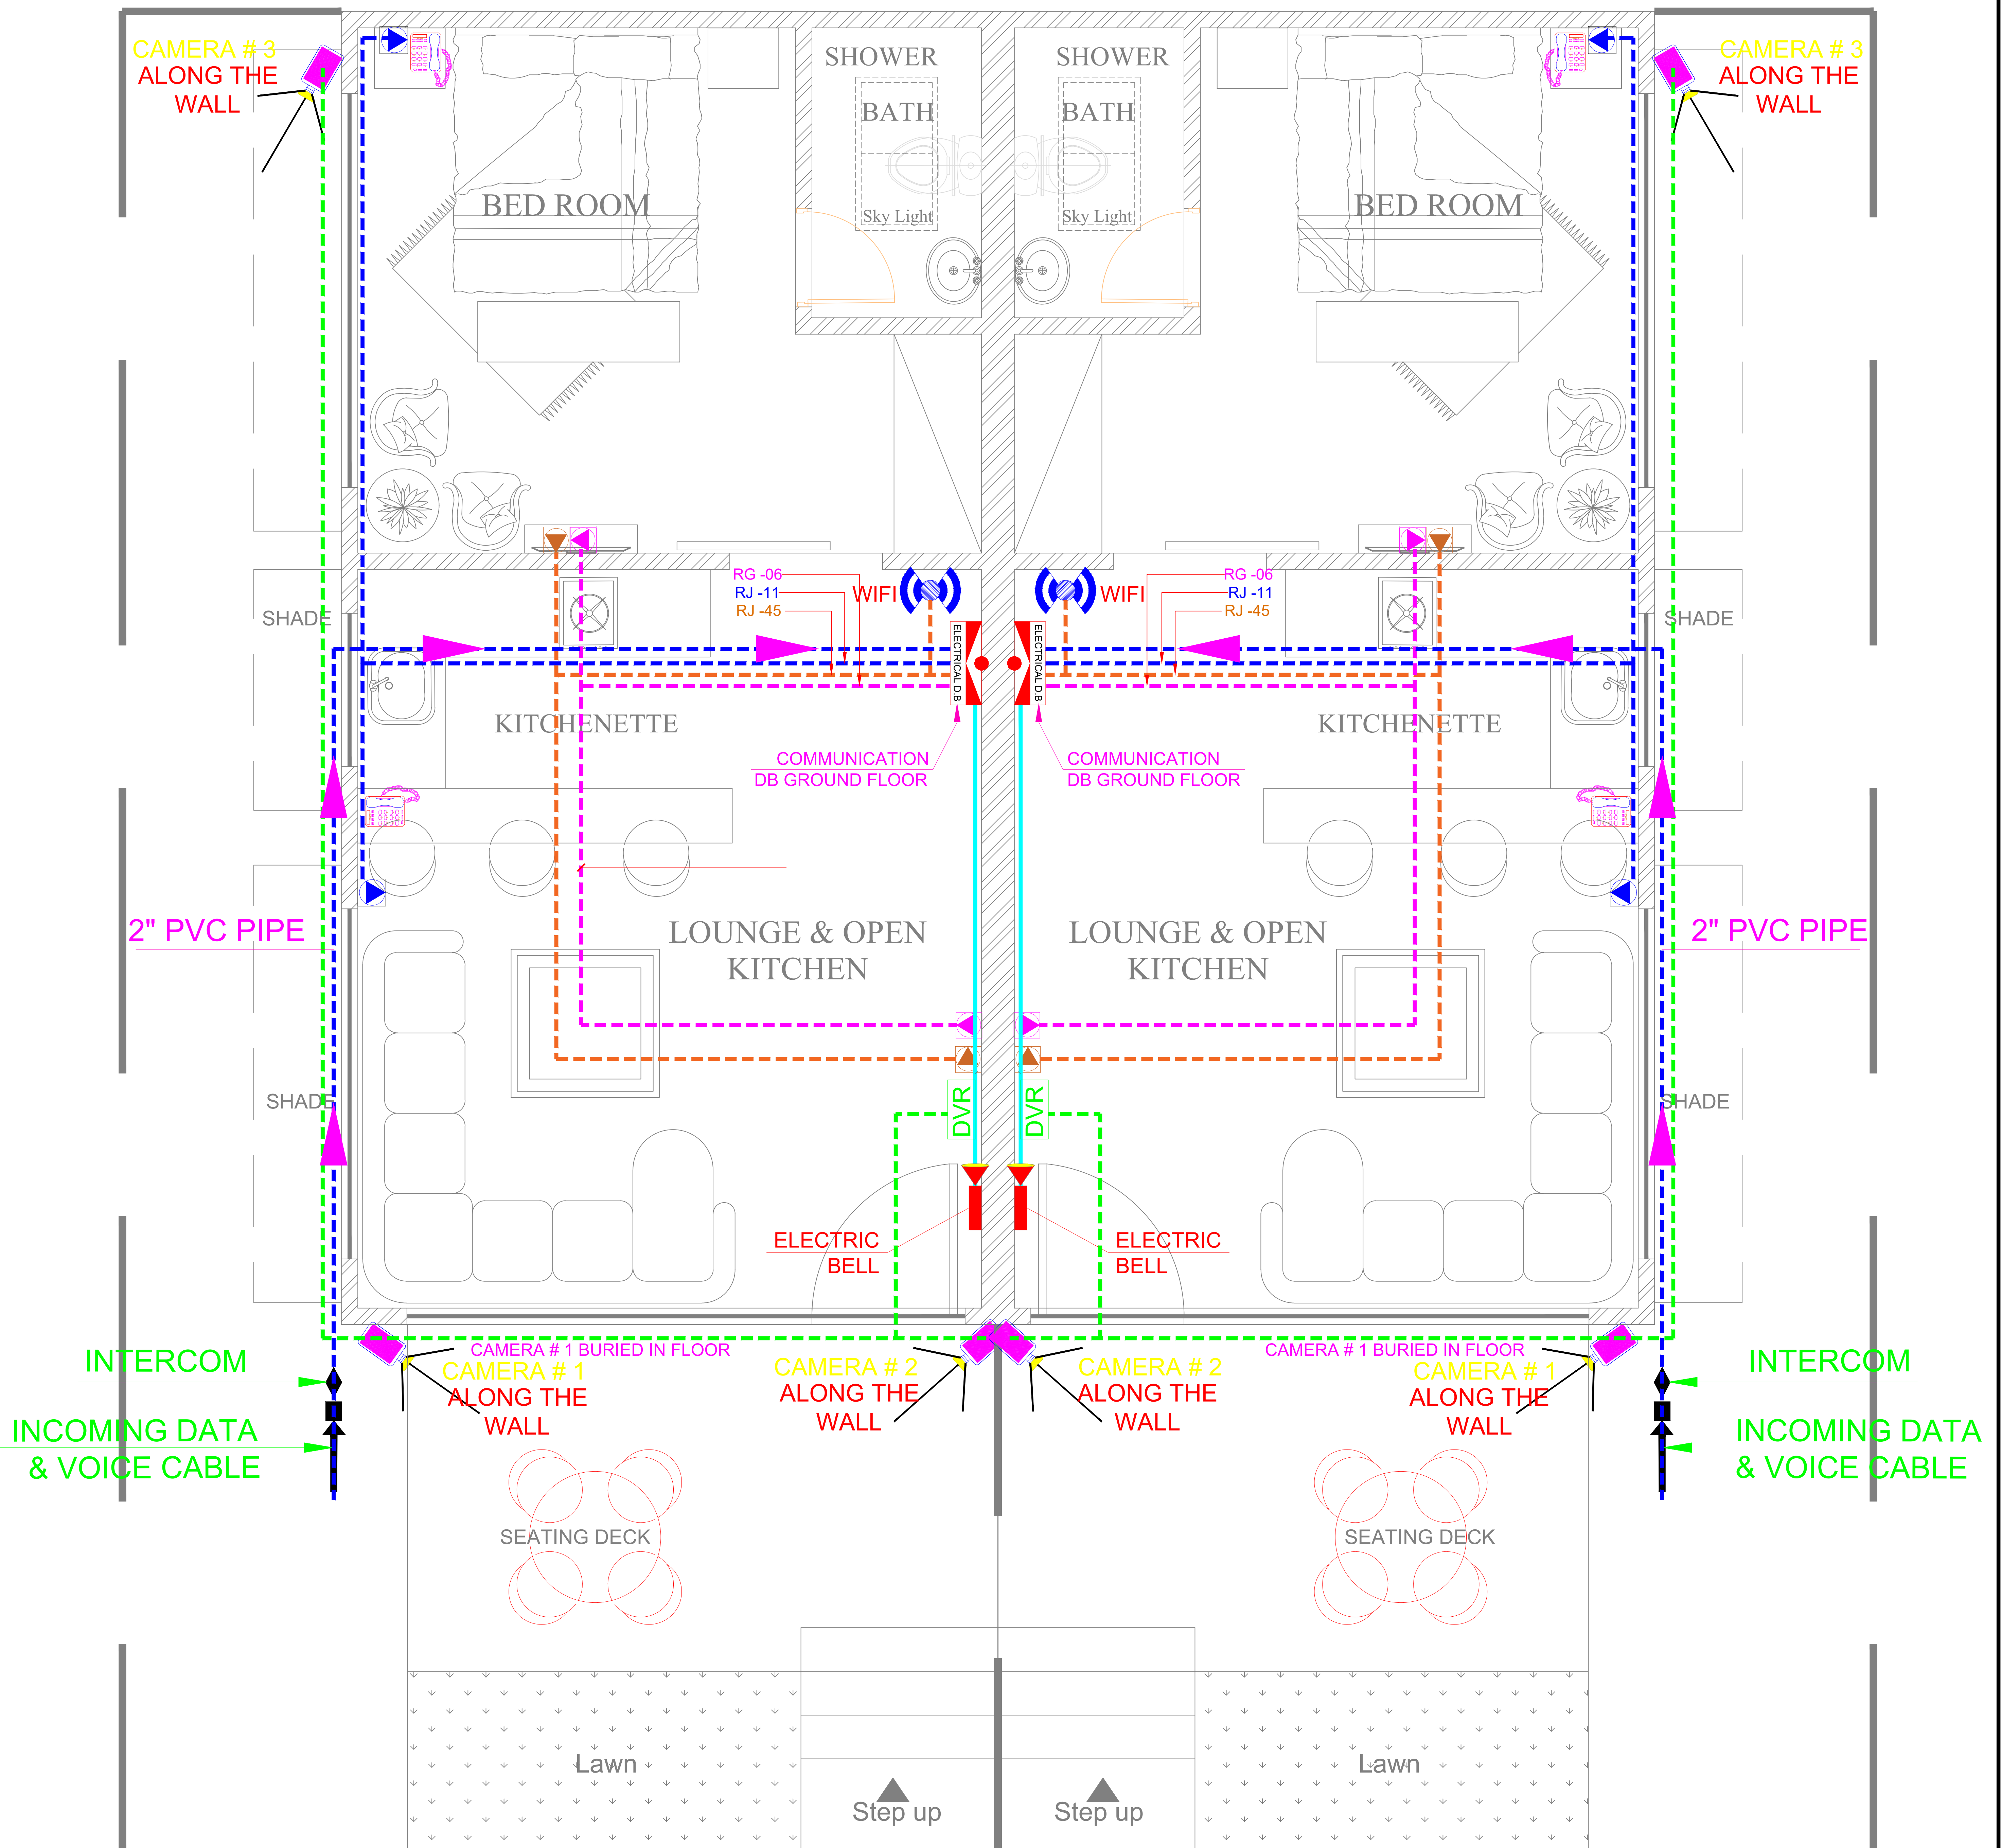

GROUND FLOOR PLAN
NETWORKING LAYOUTS PLAN



PROPOSAL DRAWINGS

NETWORK LAYOUT PLAN
GROUND FLOOR

PAGE NO.

08

DRAWING NO.

ELE-07

CLIENT:

PROJECT :

MURREE COTTAGE HOUSE

DESIGN BY:


Aqib ali

DRAWN BY:


Eshan

DATE:

20.08.2024

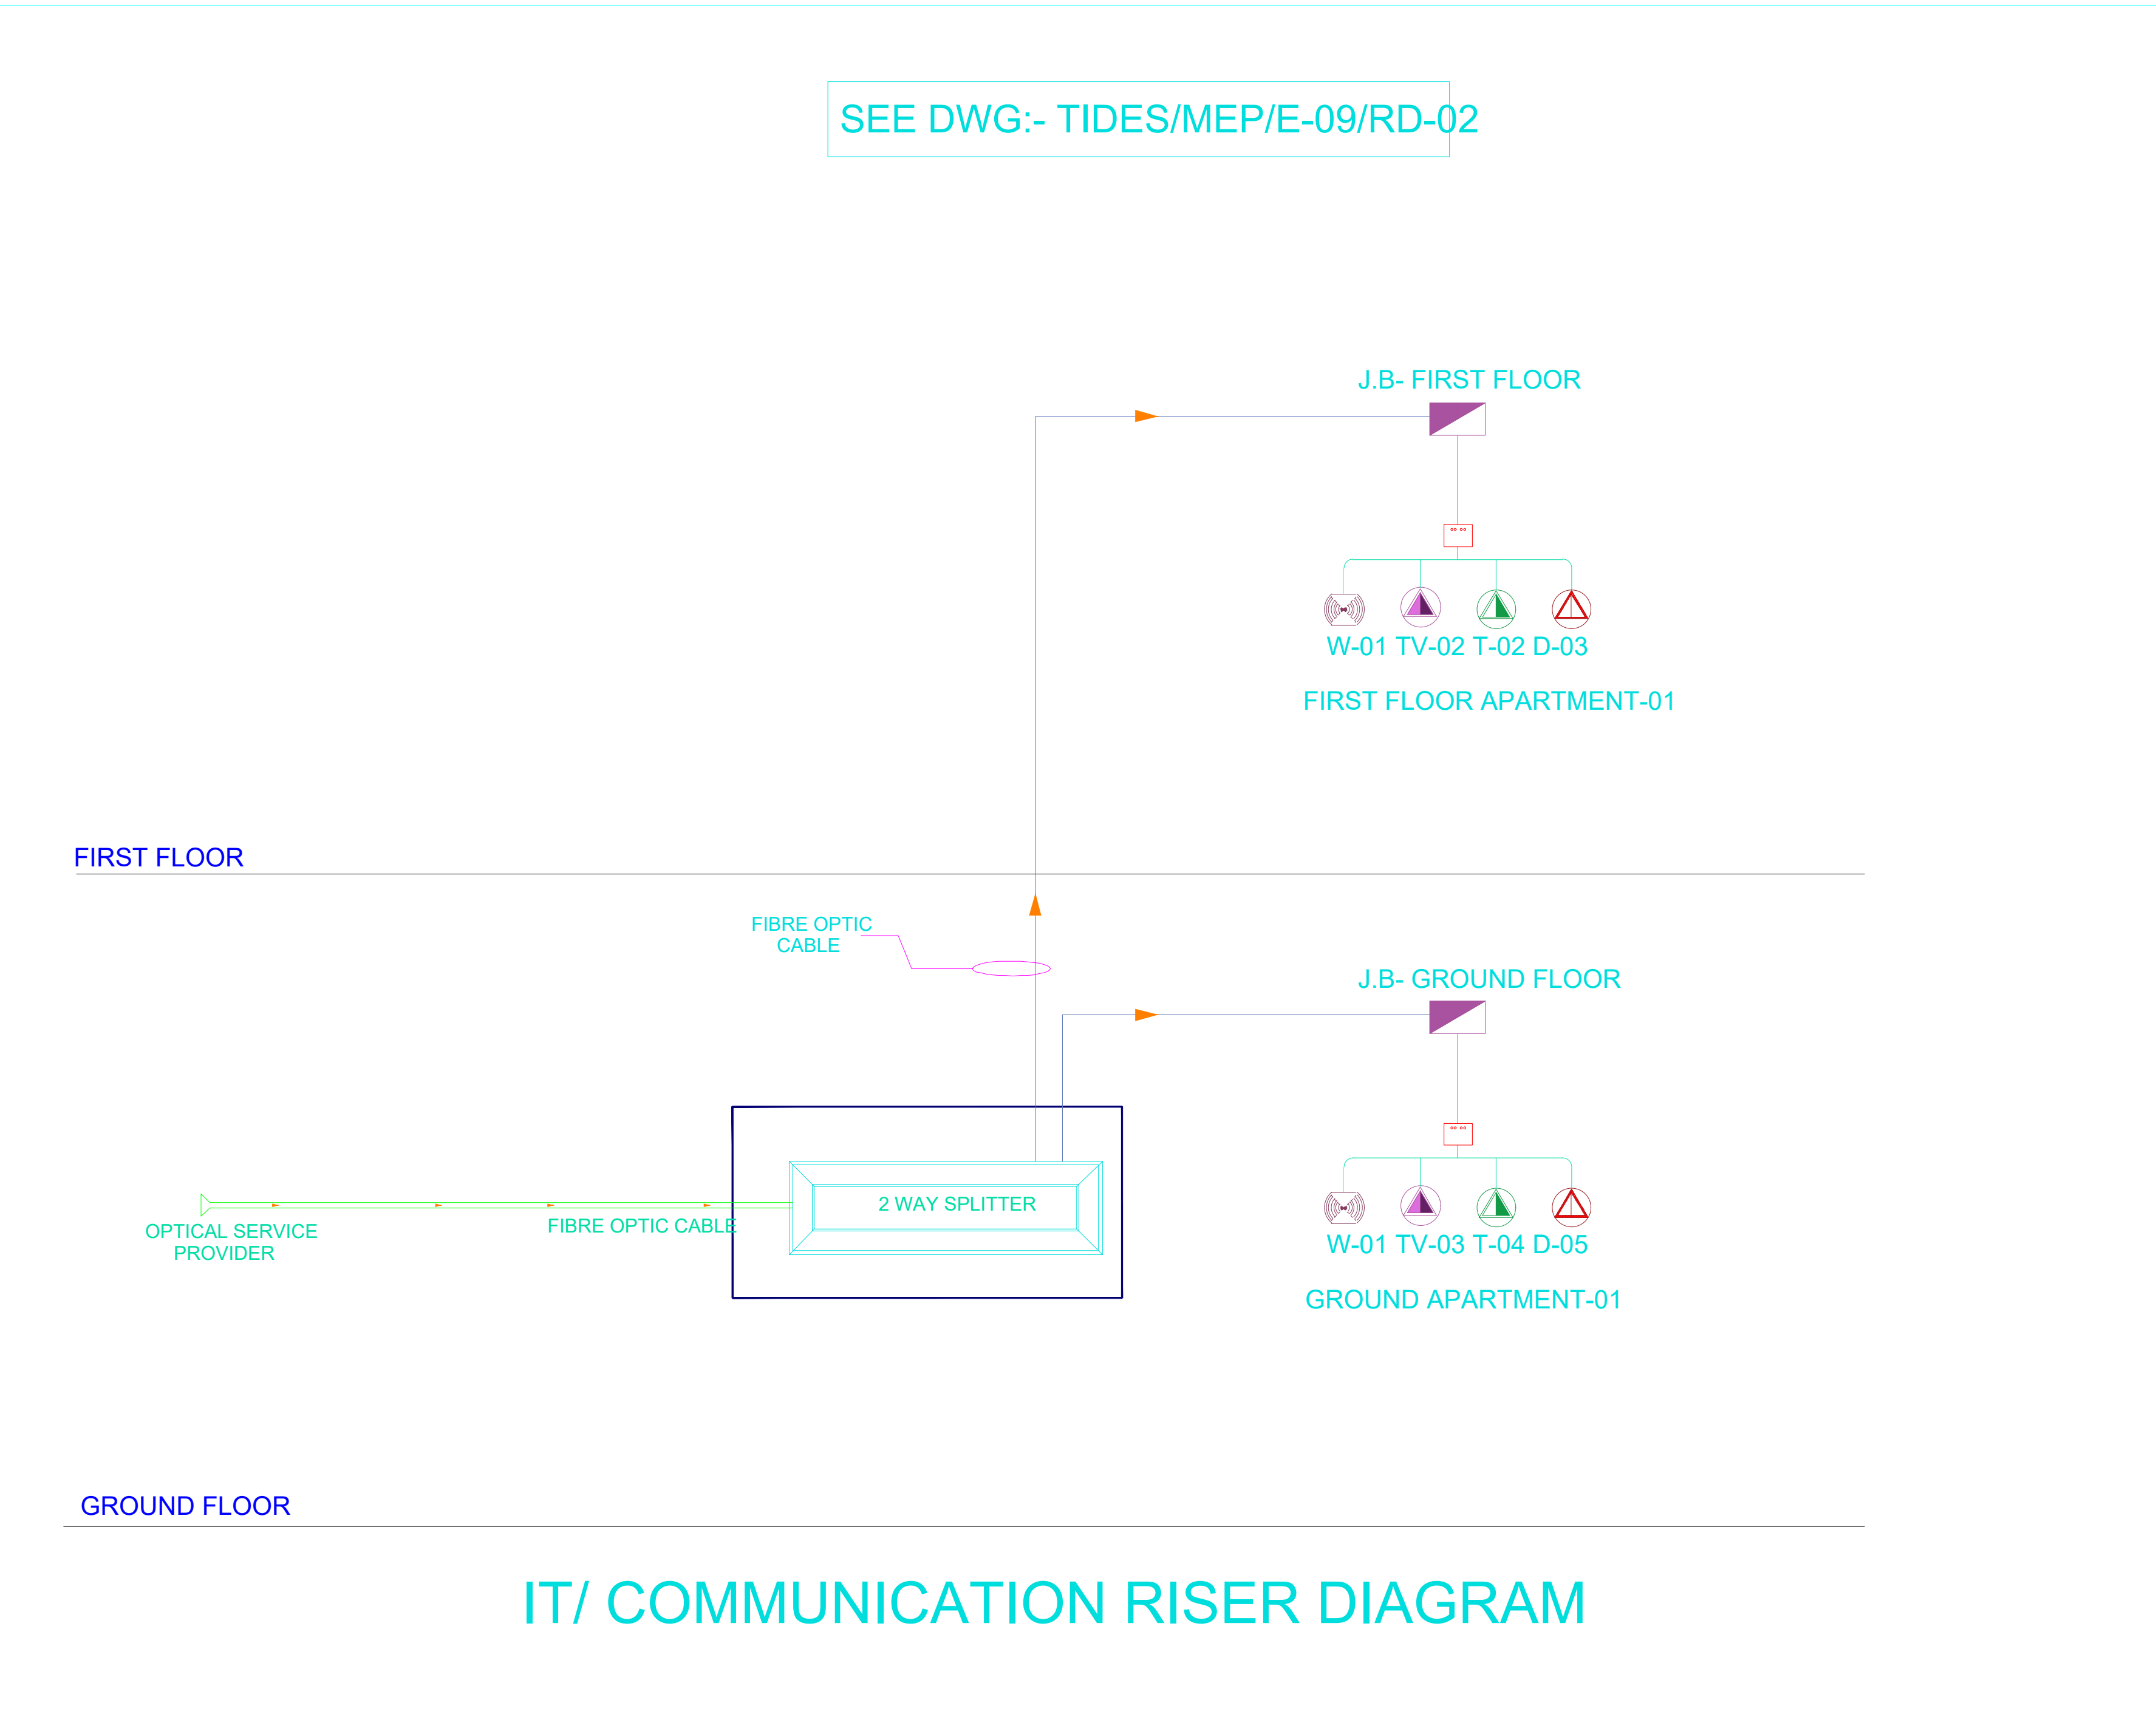

IT & CCTV SYSTEM TYPICAL DETAILS

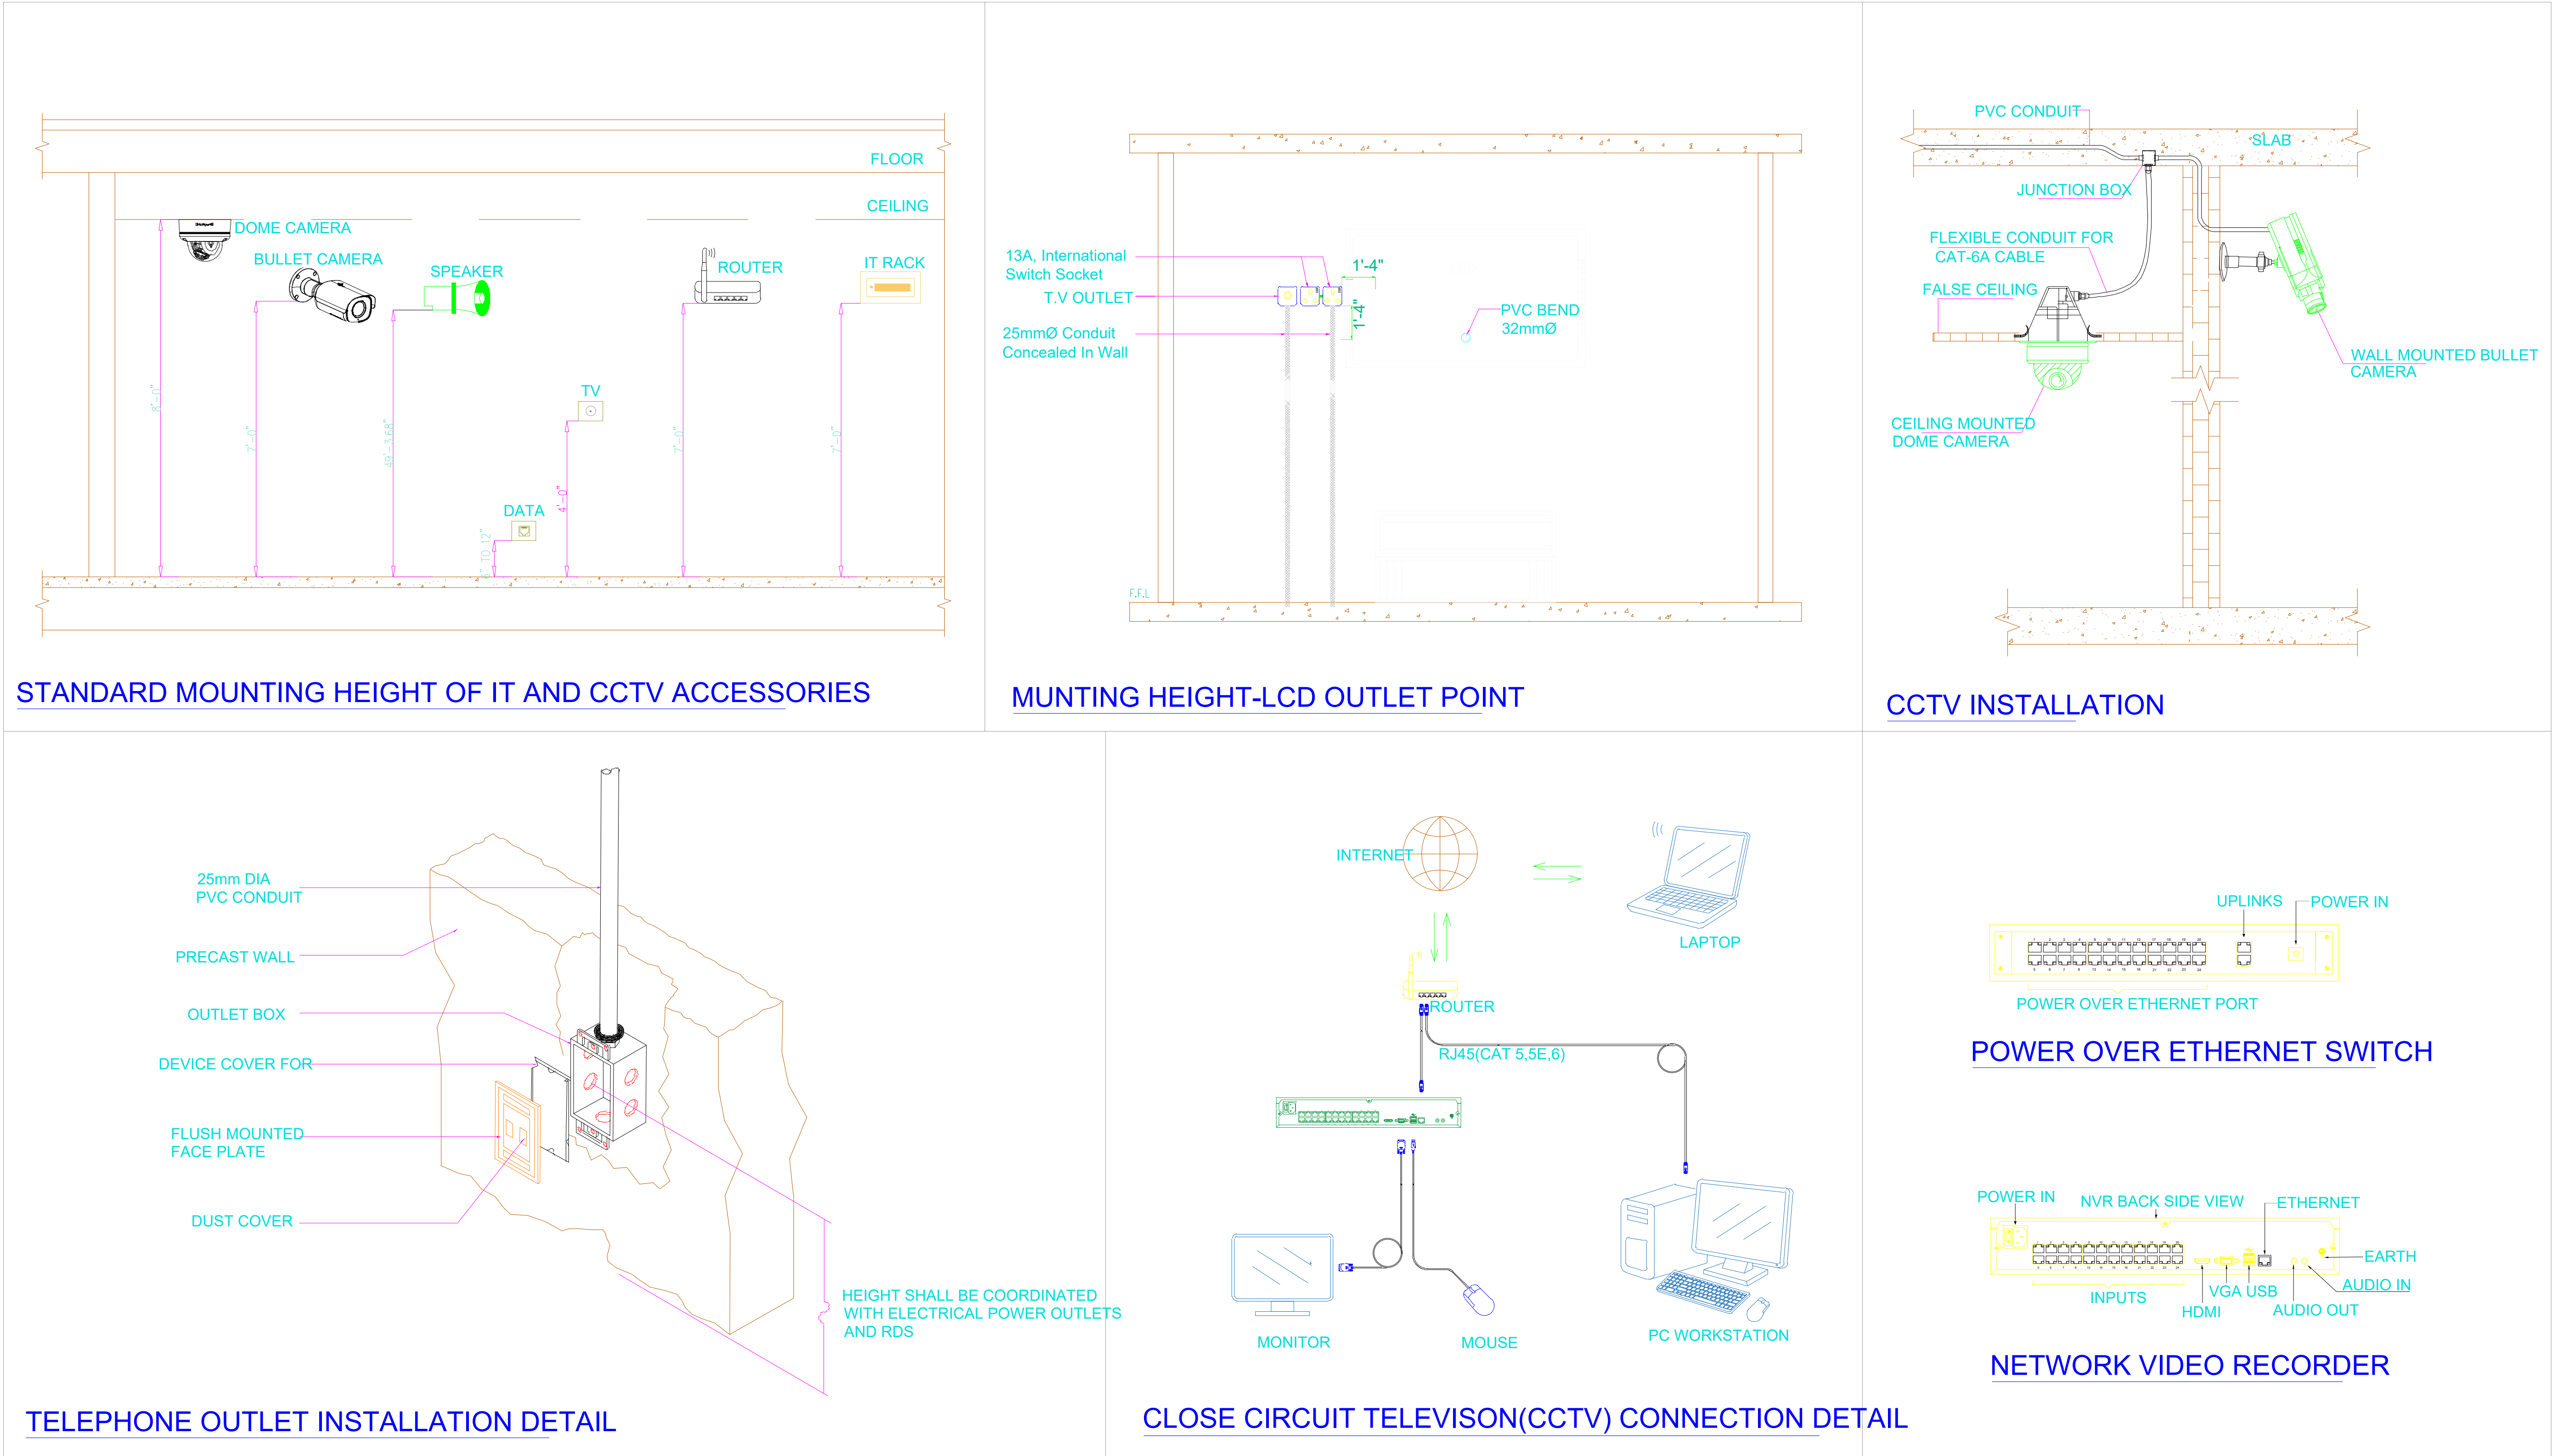

NETWORKING SLD AND MOUNTAIN HEIGHT DETAILS

	PROPOSAL DRAWINGS	NETWORK LAYOUT PLAN GROUND FLOOR	PAGE NO.	09	DRAWING NO.	ELE-08	DESIGN BY:	Aqib ali
			CLIENT:	-----	PROJECT :	MURREE COTTAGE HOUSE	DRAWN BY:	Eshan
							DATE:	20.08.2024

LIST OF DRAWINGS

S/N	DRAWING/TITLE	DWG#
01	LIST OF DRAWINGS	PL-00
02	GENERAL NOTES & LEGENDS	PL-01
03	APPROVED MANUFACTURES	PL-02
04	(DRAIANGE LAYOUTS)	
05	DRAINAGE LEGENDS	PL-03
06	DRAINAGE LAYOUTS PLAN GROUND FLOOR	PL-04
07	DRAINAGE LAYOUTS PLAN TOP FLOOR	PL-05
08	DRAINAGE DETAILS	PL-06
09	DRAINAGE DETAILS FOR STRUCTURE	PL-07
10	(WATER SUPPLY LAYOUTS)	
11	WATER SUPPLY LEGENDS	PL-08
12	WATER SUPPLY LAYOUTS PLAN GROUND FLOOR	PL-09
13	WATER SUPPLY DETAILS FOR STRUCTURE	PL-10

GENERAL NOTES:

- 1- ALL SOIL AND WASTE PIPE SHALL BE UPVC AS PER ISO 3633:1991 AND PS 3214:1992 TYPE"B" OR EQUIVALENT SPECIFICATIONS.
- 2- ALL COLD AND HOT WATER PIPES SHALL BE POLYPROPYLENE AS PER DIN 8077-8078 CLASS PN-20 FOR PIPES AND PN-25 FOR FITTINGS.
- 3- UPVC P-TRAP SHALL BE USED WITH ALL GULLY TRAPS.
- 4- VENT PIPES SHALL BE EXTENDED ONE FT ABOVE FINISHED ROOF LEVEL.
- 5- WATER HEATER SHALL BE STORAGE TYPE
- 6- MINIMUM SIZE OF HOT AND COLD WATER PIPES INSIDE TOILET SHALL BE 25 MM O/D.
- 7- ALL PIPING SHALL BE TESTED FOR LEAKAGE BEFORE THE JOINTS ARE COVERED.
- 8- ALL FLOOR TRAP SAHLL BE OF UPVC.
- 9- TEFLON TAPE SHALL BE USED FOR JOINTING OF GI PIPES.
- 10- ALL UPVC PIPING SOIL & WASTE SHALL BE JOINTED WITH SOLUTION.
- 11- ALL SOIL PIPES SHALL BE 4" DIA UPVC UNLESS OTHERWISE MENTIONED.
- 12- ALL WASTE PIPES SHALL BE 3" DIA UPVC UNLESS OTHERWISE MENTIONED.
- 13- ALL WASTE PIPES FROM WASHBASIN OR SINK TO F.T. SHALL BE 2" DIA UPVC.
- 14- ALL PPRC PIPE SIZES SHOWN ON DRAWING ARE OUTER DIAMTERS.


PPRC OUTER DIA	PPRC INTERNAL DIA
25 MM	16.6 MM = 1/2"
32 MM	21.2 MM = 3/4"
40 MM	26.6 MM = 1"
50 MM	33.4 MM = 1-1/4"
63 MM	42 MM = 1-1/2"
75 MM	50 MM = 2"
90 MM	63 MM = 2-1/2"
100 MM	75 MM = 3"

15- SLOPE FOR PIPES

2" DIA	1 IN 48
3" TO 6" DIA	1 IN 96
8" & ABOVE	1 IN 192

LEGEND

- 1- UPVC SEWER PIPE
- 2- UPVC SOIL WATER PIPE
- 3- UPVC WASTE WATER PIPE
- 4- POLYPROPYLENE COLD WATER
- 5- POLYPROPYLENE HOT WATER
- 6- FLOOR TRAP (MULTI)
- 7- GULLY TRAP
- 8- MAN HOLE
- 9- BALL VALVE
- 10- GI/PI GAS PIPE
- 11- GI COLD WATER PIPE
- 12- P- TRAP
- 13- BOTTLE TRAP
- 14- CLEAN OUT PLUG
- 15- MILD STEEL FIRE FIGHTING PIPE
- 16- POLYPROPYLENE HOT WATER RETURN

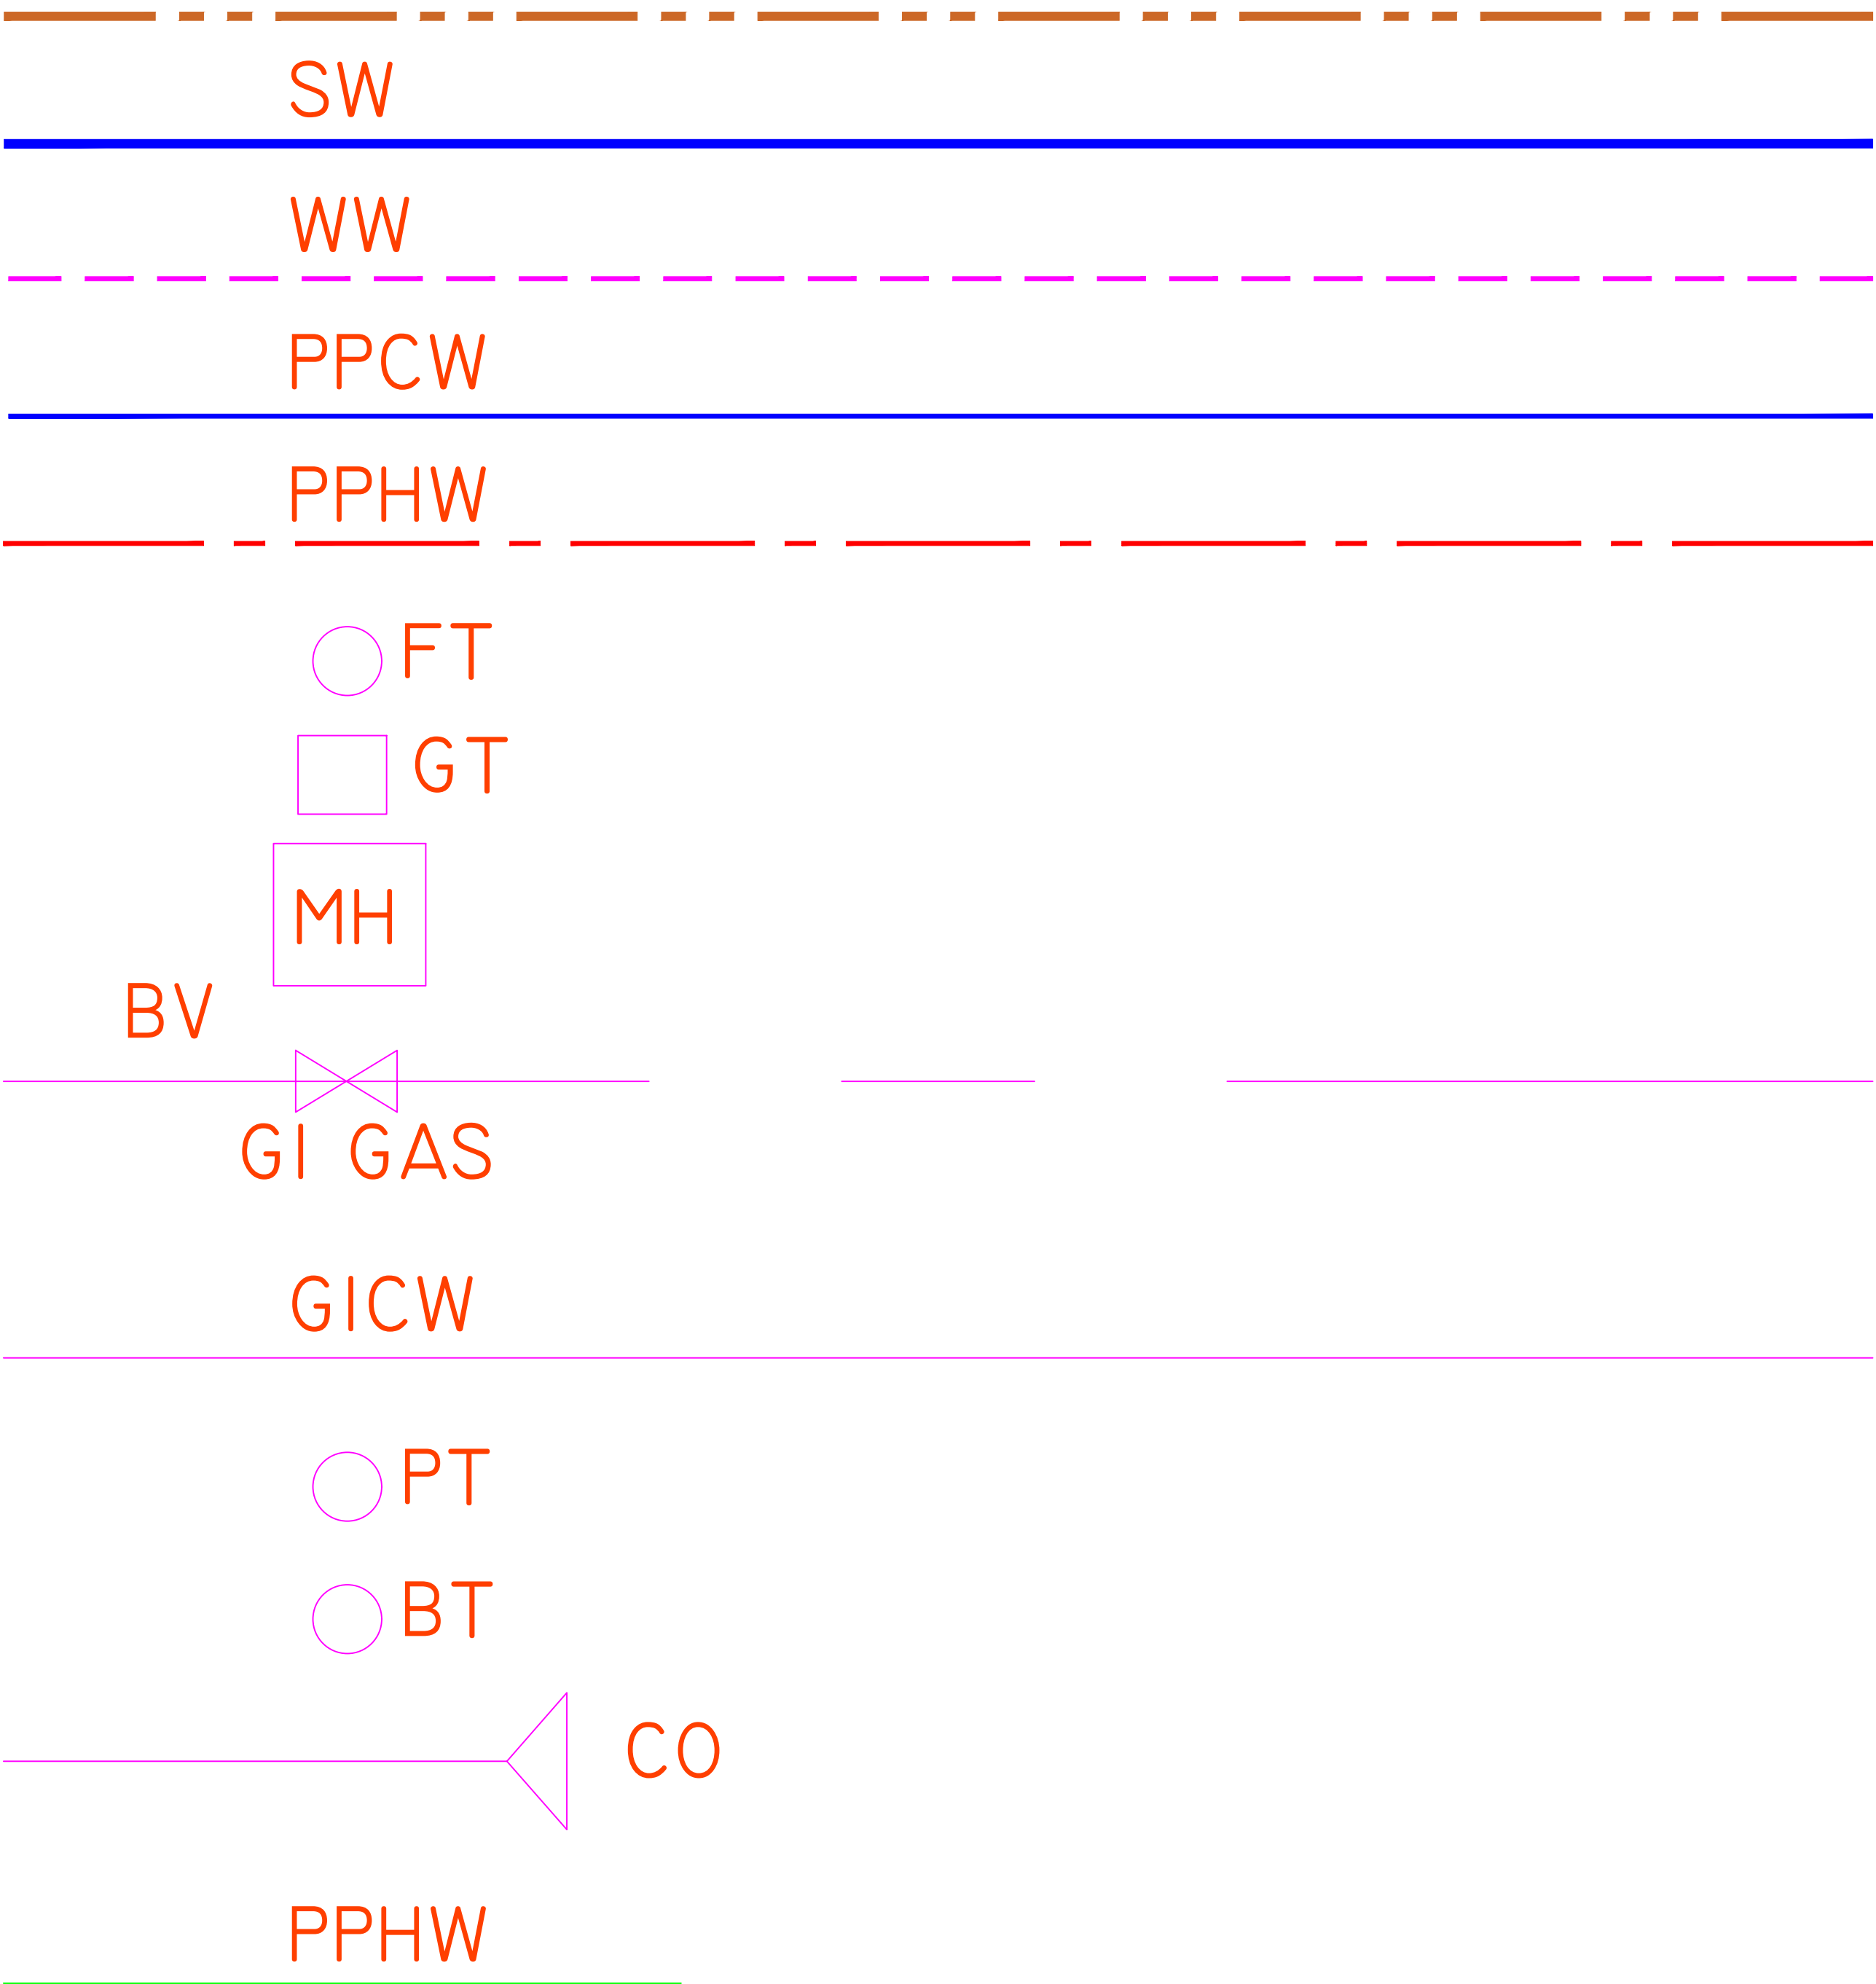

LIST OF APPROVED MANUFACTURERS/SUPPLIERS

PLUMBING MATERIALS

S No.	Item	Specifications	Brand Name	Manufacturers / Suppliers
Water Supply				
01	PPRC Pipes	PN-20, PN-25	Hydroplast	
			Dadex	
			Formul Turkey	
			Kalde Turkey	
			RAKtherm UAE	
02	G.I Pipes	Medium Quality BS 1387	International Industries Ltd (IIL)	
			Jamal Pipes (Pvt.) Ltd	
			Karachi Pipe Mills Ltd	
03	Geysers (Gas/Electric)	Approved by an Architect	SINGER	
			Super Asia	
			CANON Electric & Gas Appliances	
			Ariston, Italy	
			Puma	
			Ambassador	
04	Valves (Gate valves, Non-return Valves, Strainers, Pump Flexible Connectors, Flow Switches)	Brass/Bronze, PN-16	Kitz Valves	
			Econosto	
			Itap Italy	
			Hattersley Valves UK	
05	Pumps (Centrifugal Pumps, Recirculating Pumps, Pressurizing Pumps)	Approved by an Architect	KSB Pumps Company Limited	
			Grundfos Pumps Limited	
			DAB Pumps Limited	
			Alarko Carrier	

SEWERAGE & RAIN WATER

06	UPVC Pipes & Fittings (Floor Traps, Roof Drains and Gully Traps, COP)	BS 4514, BS 5255 & BS 4660/BS 979	Paling Malaysia	
			Vesbo, Turkey	
			AGM KSA	
			Tetraplast	
			Dadex from Pakistan	
07	CI Gratings	A15, B125, C250, D400, E600	Teepu Pipe and Fitting	
			McAlpine	
			Jaws	
08	Submersible Pumps	Approved by an Architect	KSB Pumps Company Limited	
			Grundfos Pumps Limited	
			DAB Pumps Limited	
			Wilo Germany	
09	Sanitary Fittings (Water Closet, Wash Basin, Vanity, Sinks)	As Approved by Architect / Client	As Approved by Architect / Client	



PROPOSAL DRAWINGS

APPROVED
MANUFACTURES

PAGE NO.

03

DRAWING NO.

PL-02

DESIGN BY:

Aqib ali

CLIENT:

PROJECT :



MURREE COTTAGE HOUSE

DRAWN BY:


Eshan

DATE:


20.08.2024

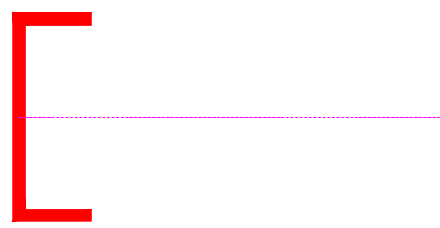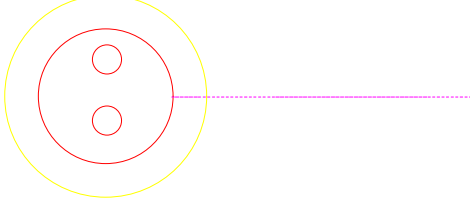DRAINAGE LEGENDS		
SYMBOL	DESCRIPTION	
	SP	SOIL WATER PIPE
	WP	WASTE WATER PIPE
	RP	RAIN WATER PIPE
	VP	VENT WATER PIPE
	FD	FLOOR DRAIN
	COP	CLEAN OUT PLUG (ABOVE CEILING)
	COP	CLEAN OUT PLUG (FLOOR LEVEL)


SYMBOL	DESCRIPTION
F/A	FROM ABOVE
F/B	FROM BELOW
T/A	TO ABOVE
T/B	TO BELOW

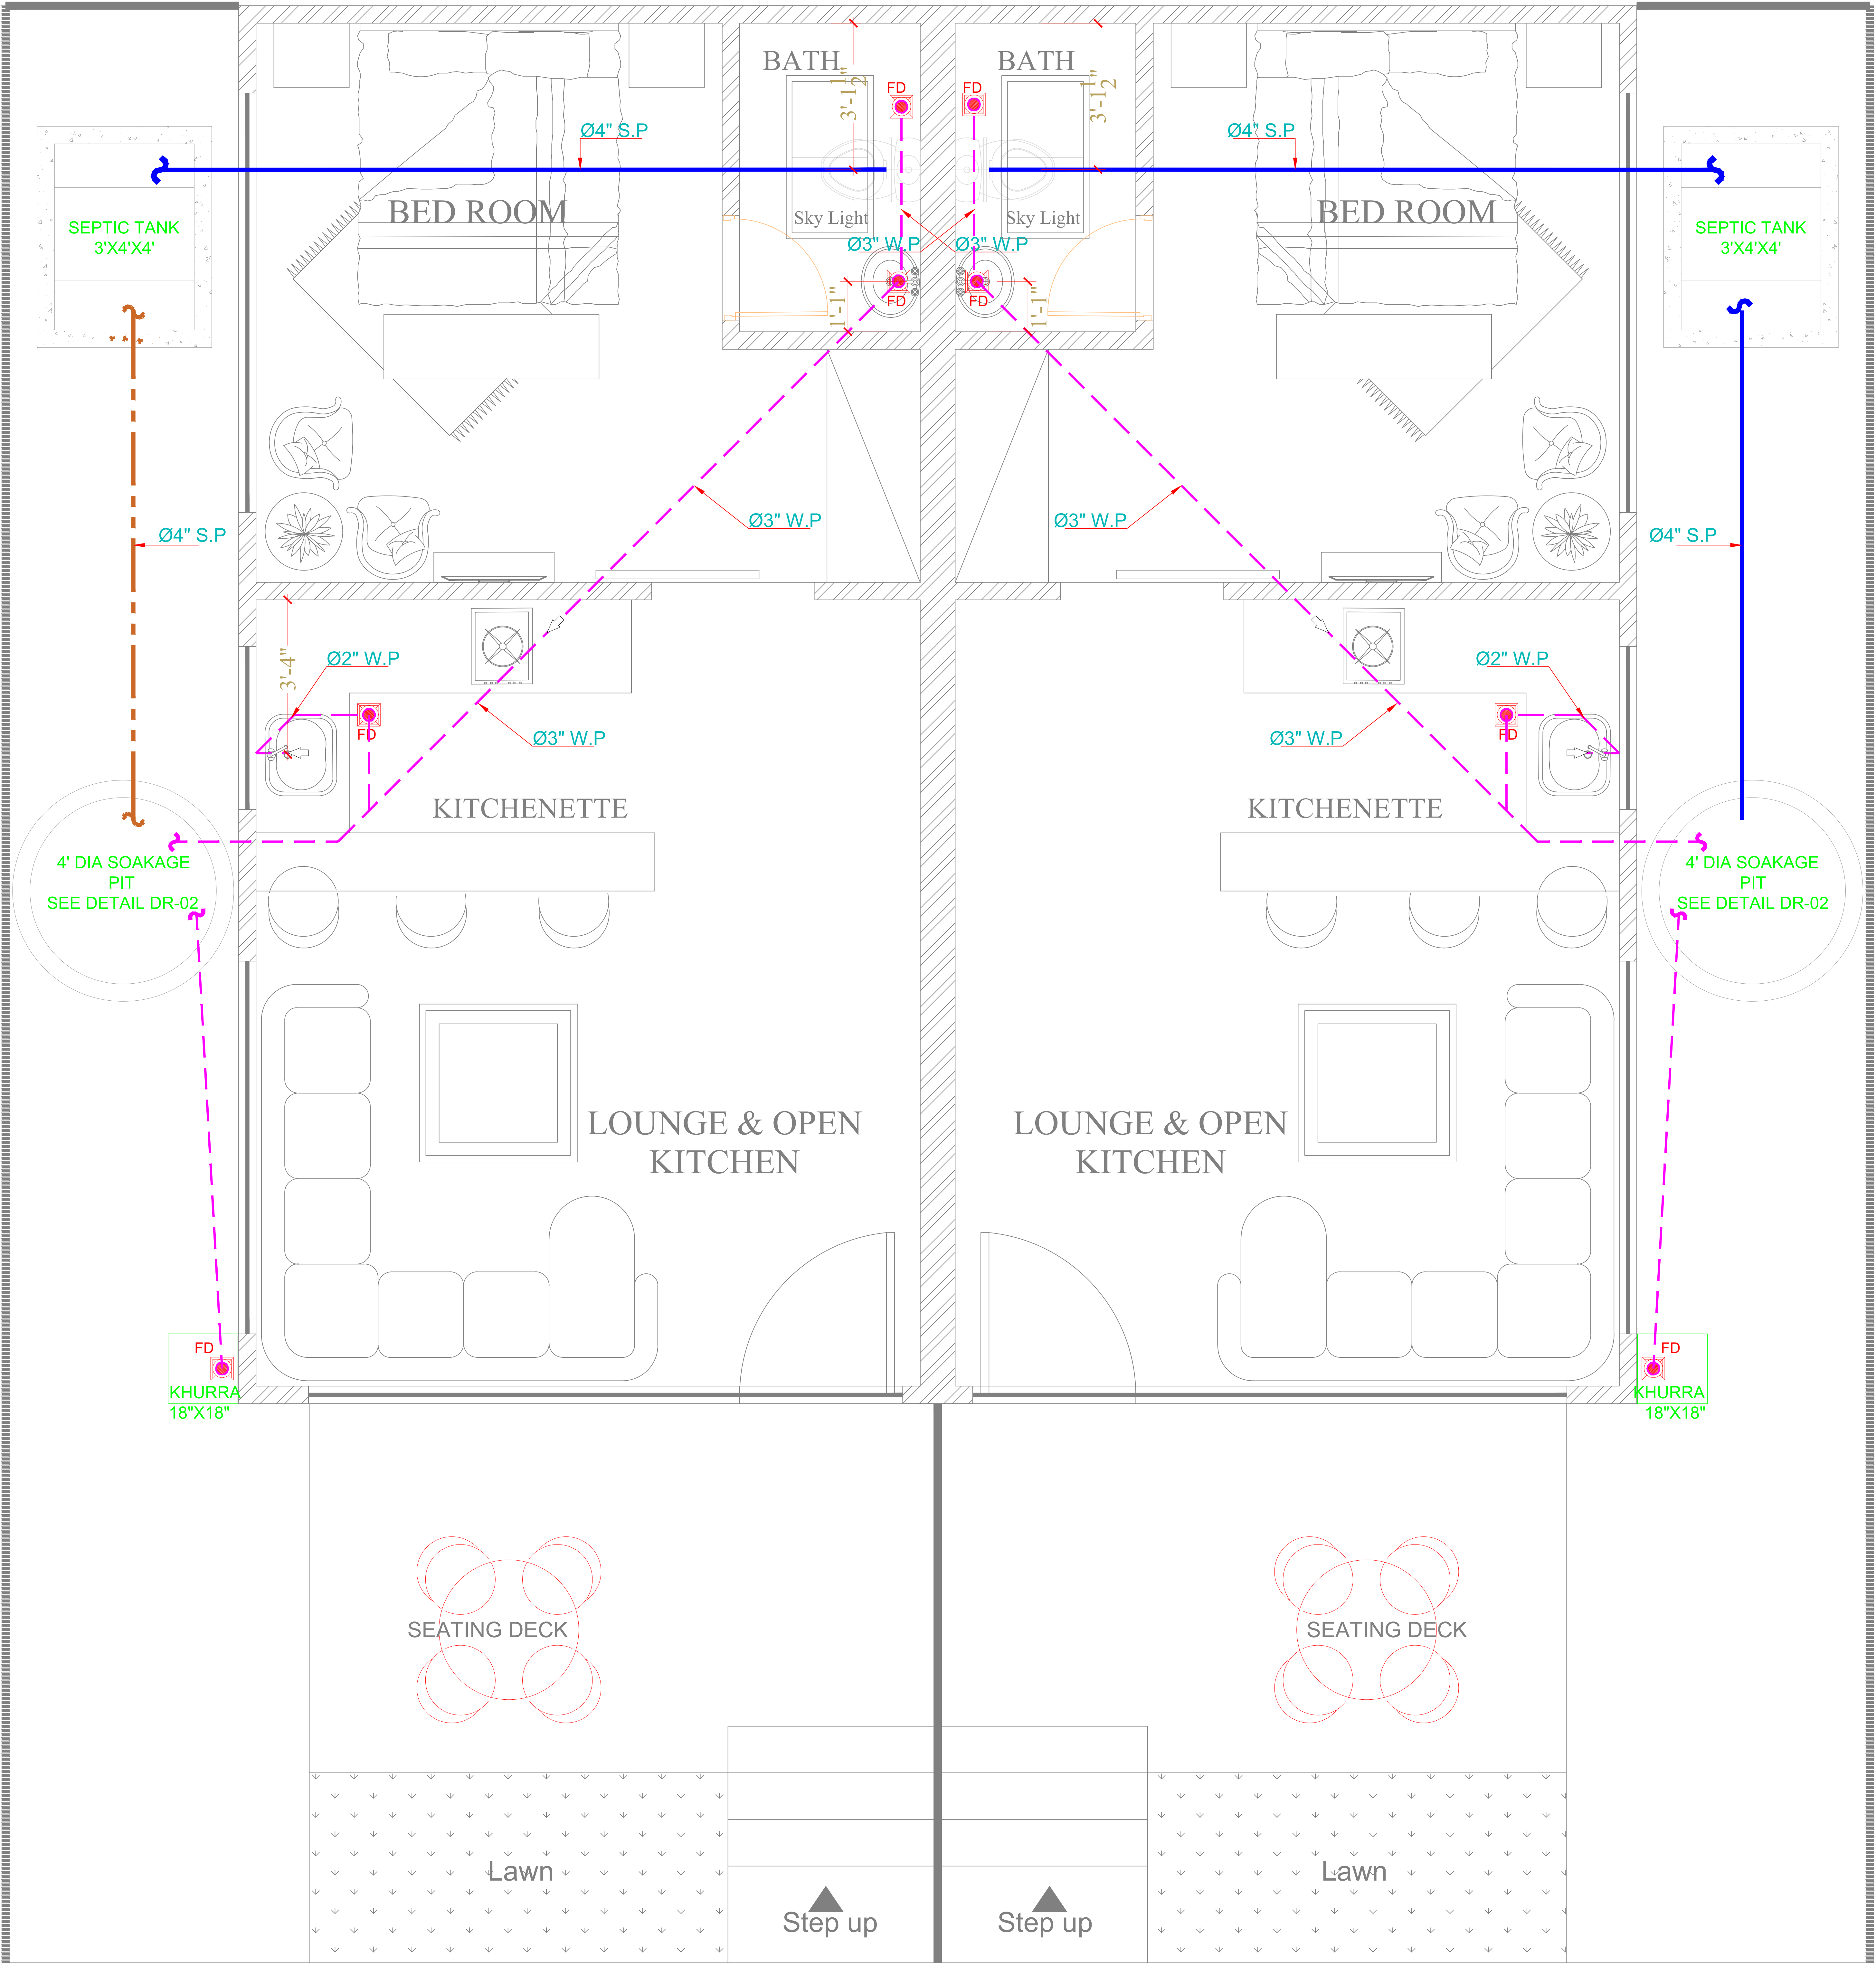

DRAINAGE GROUND FLOOR


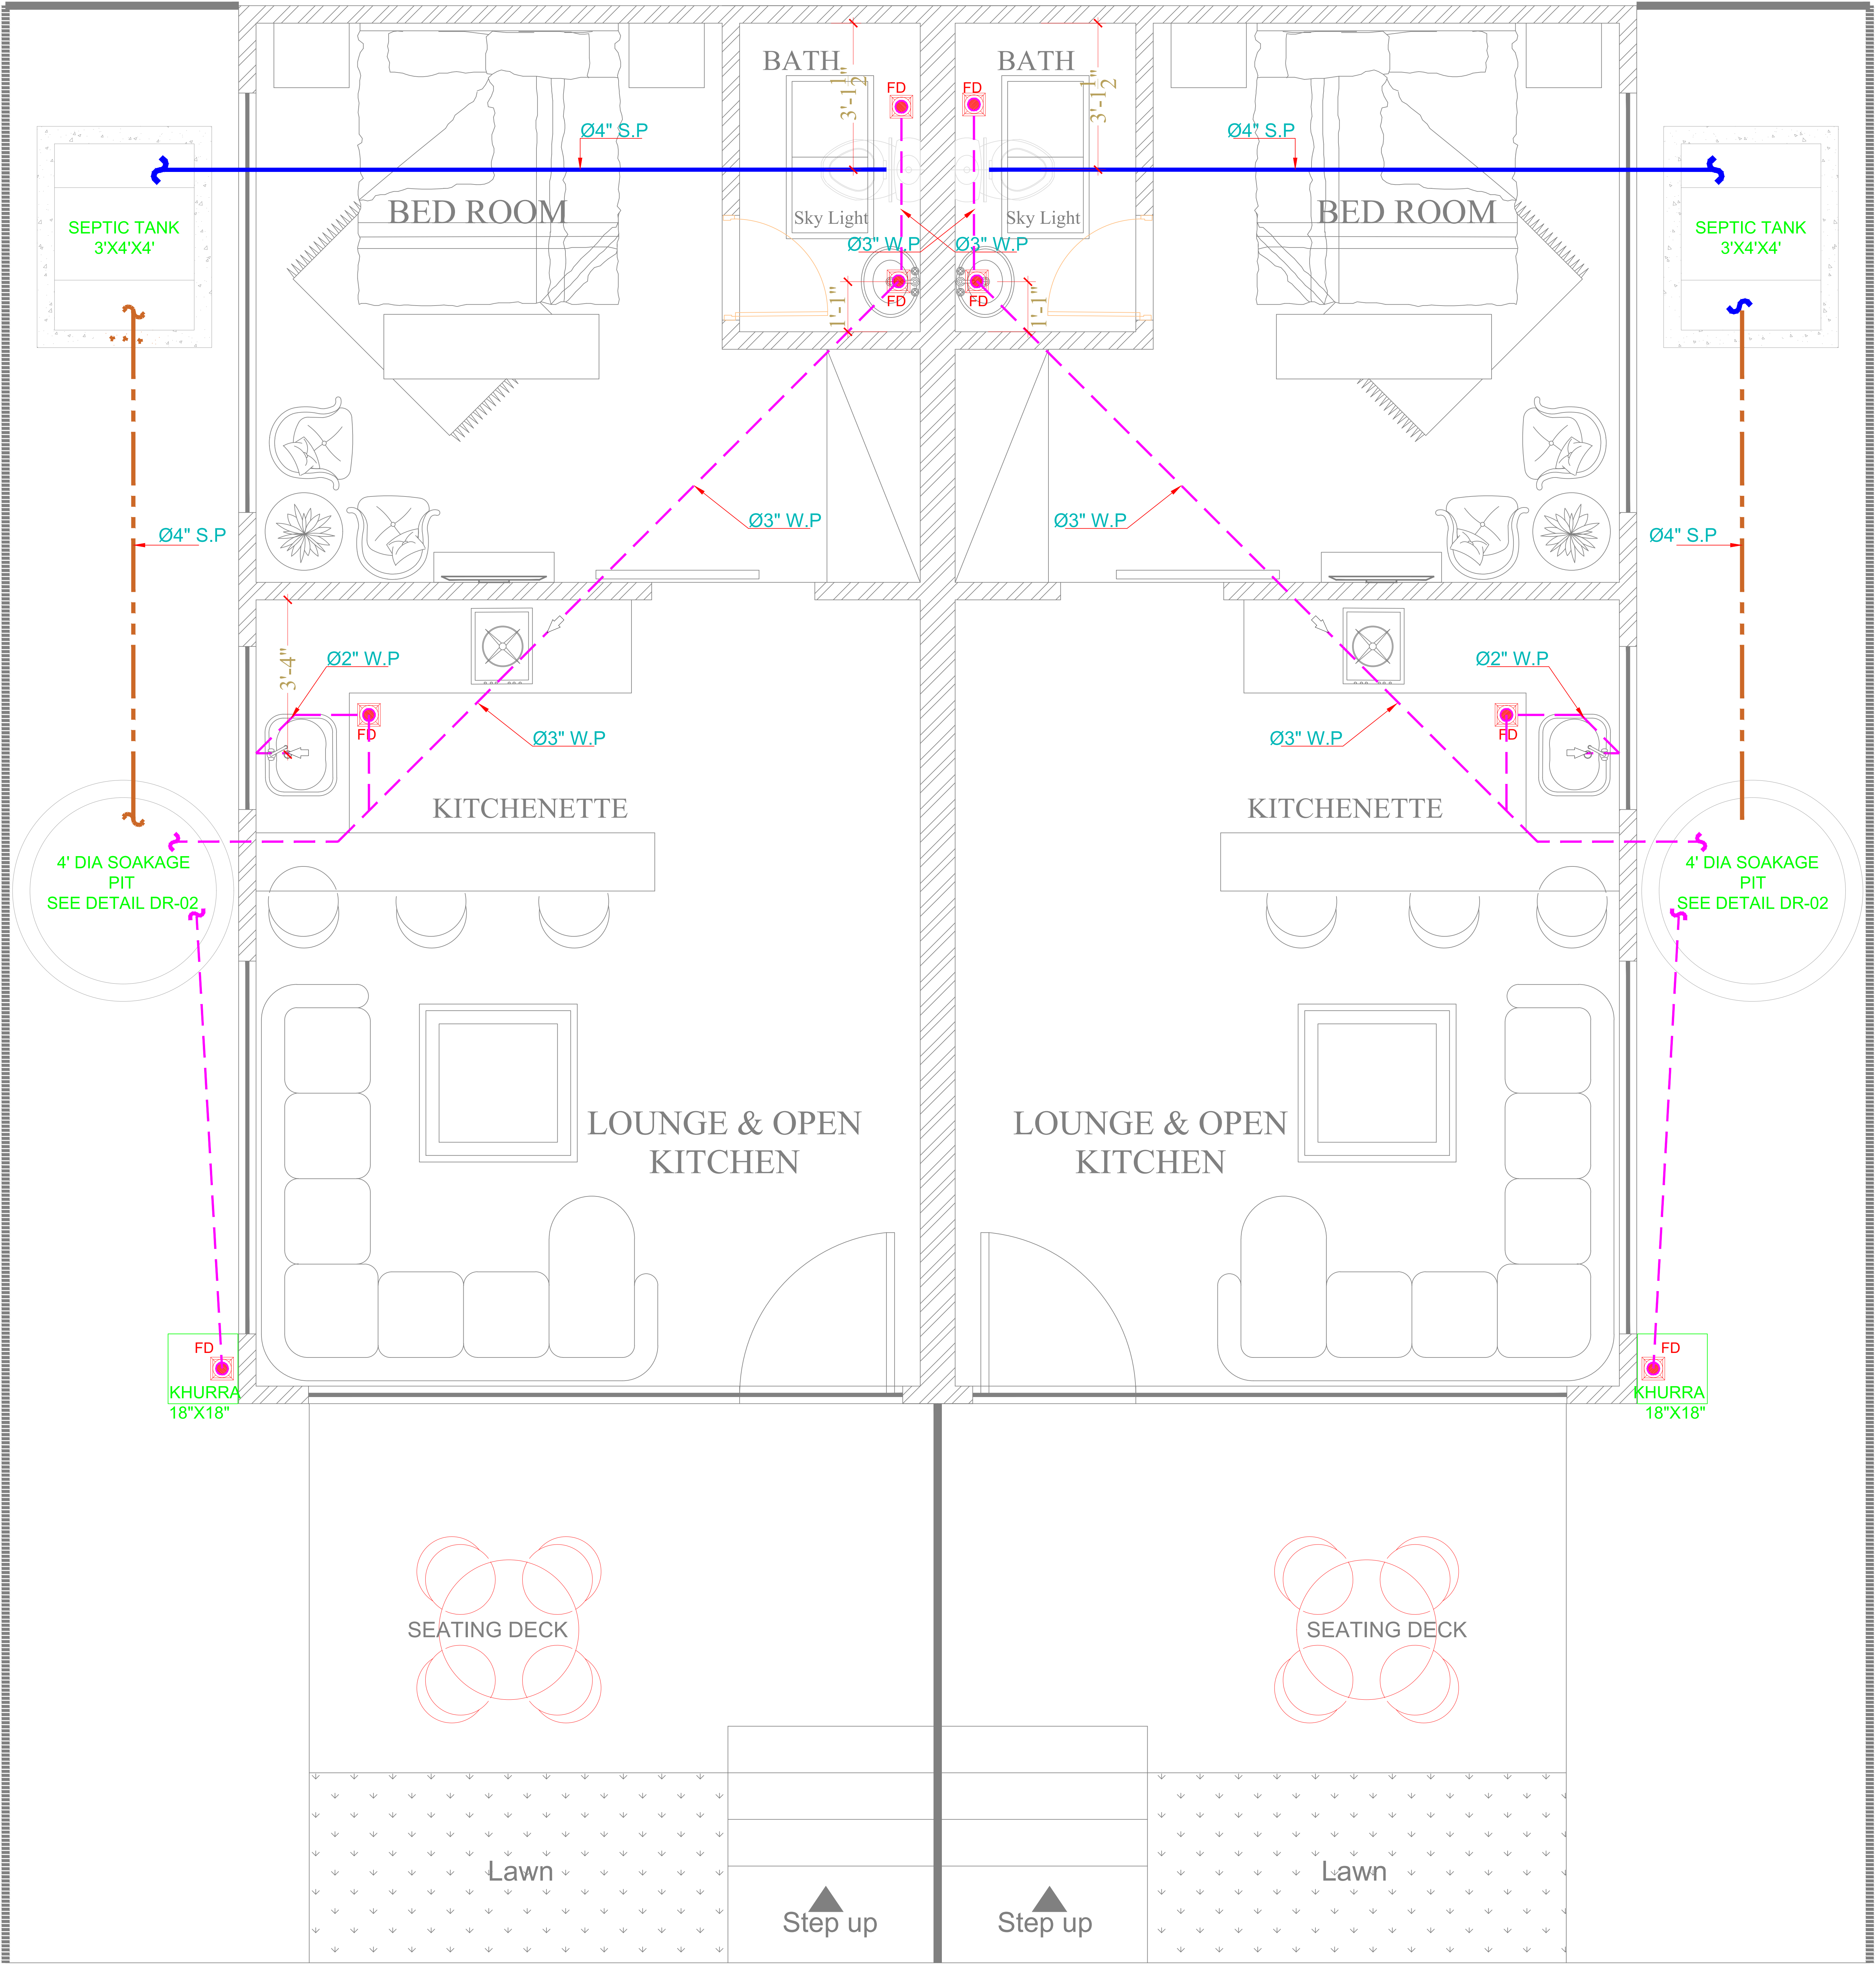











DRAINAGE GROUND FLOOR

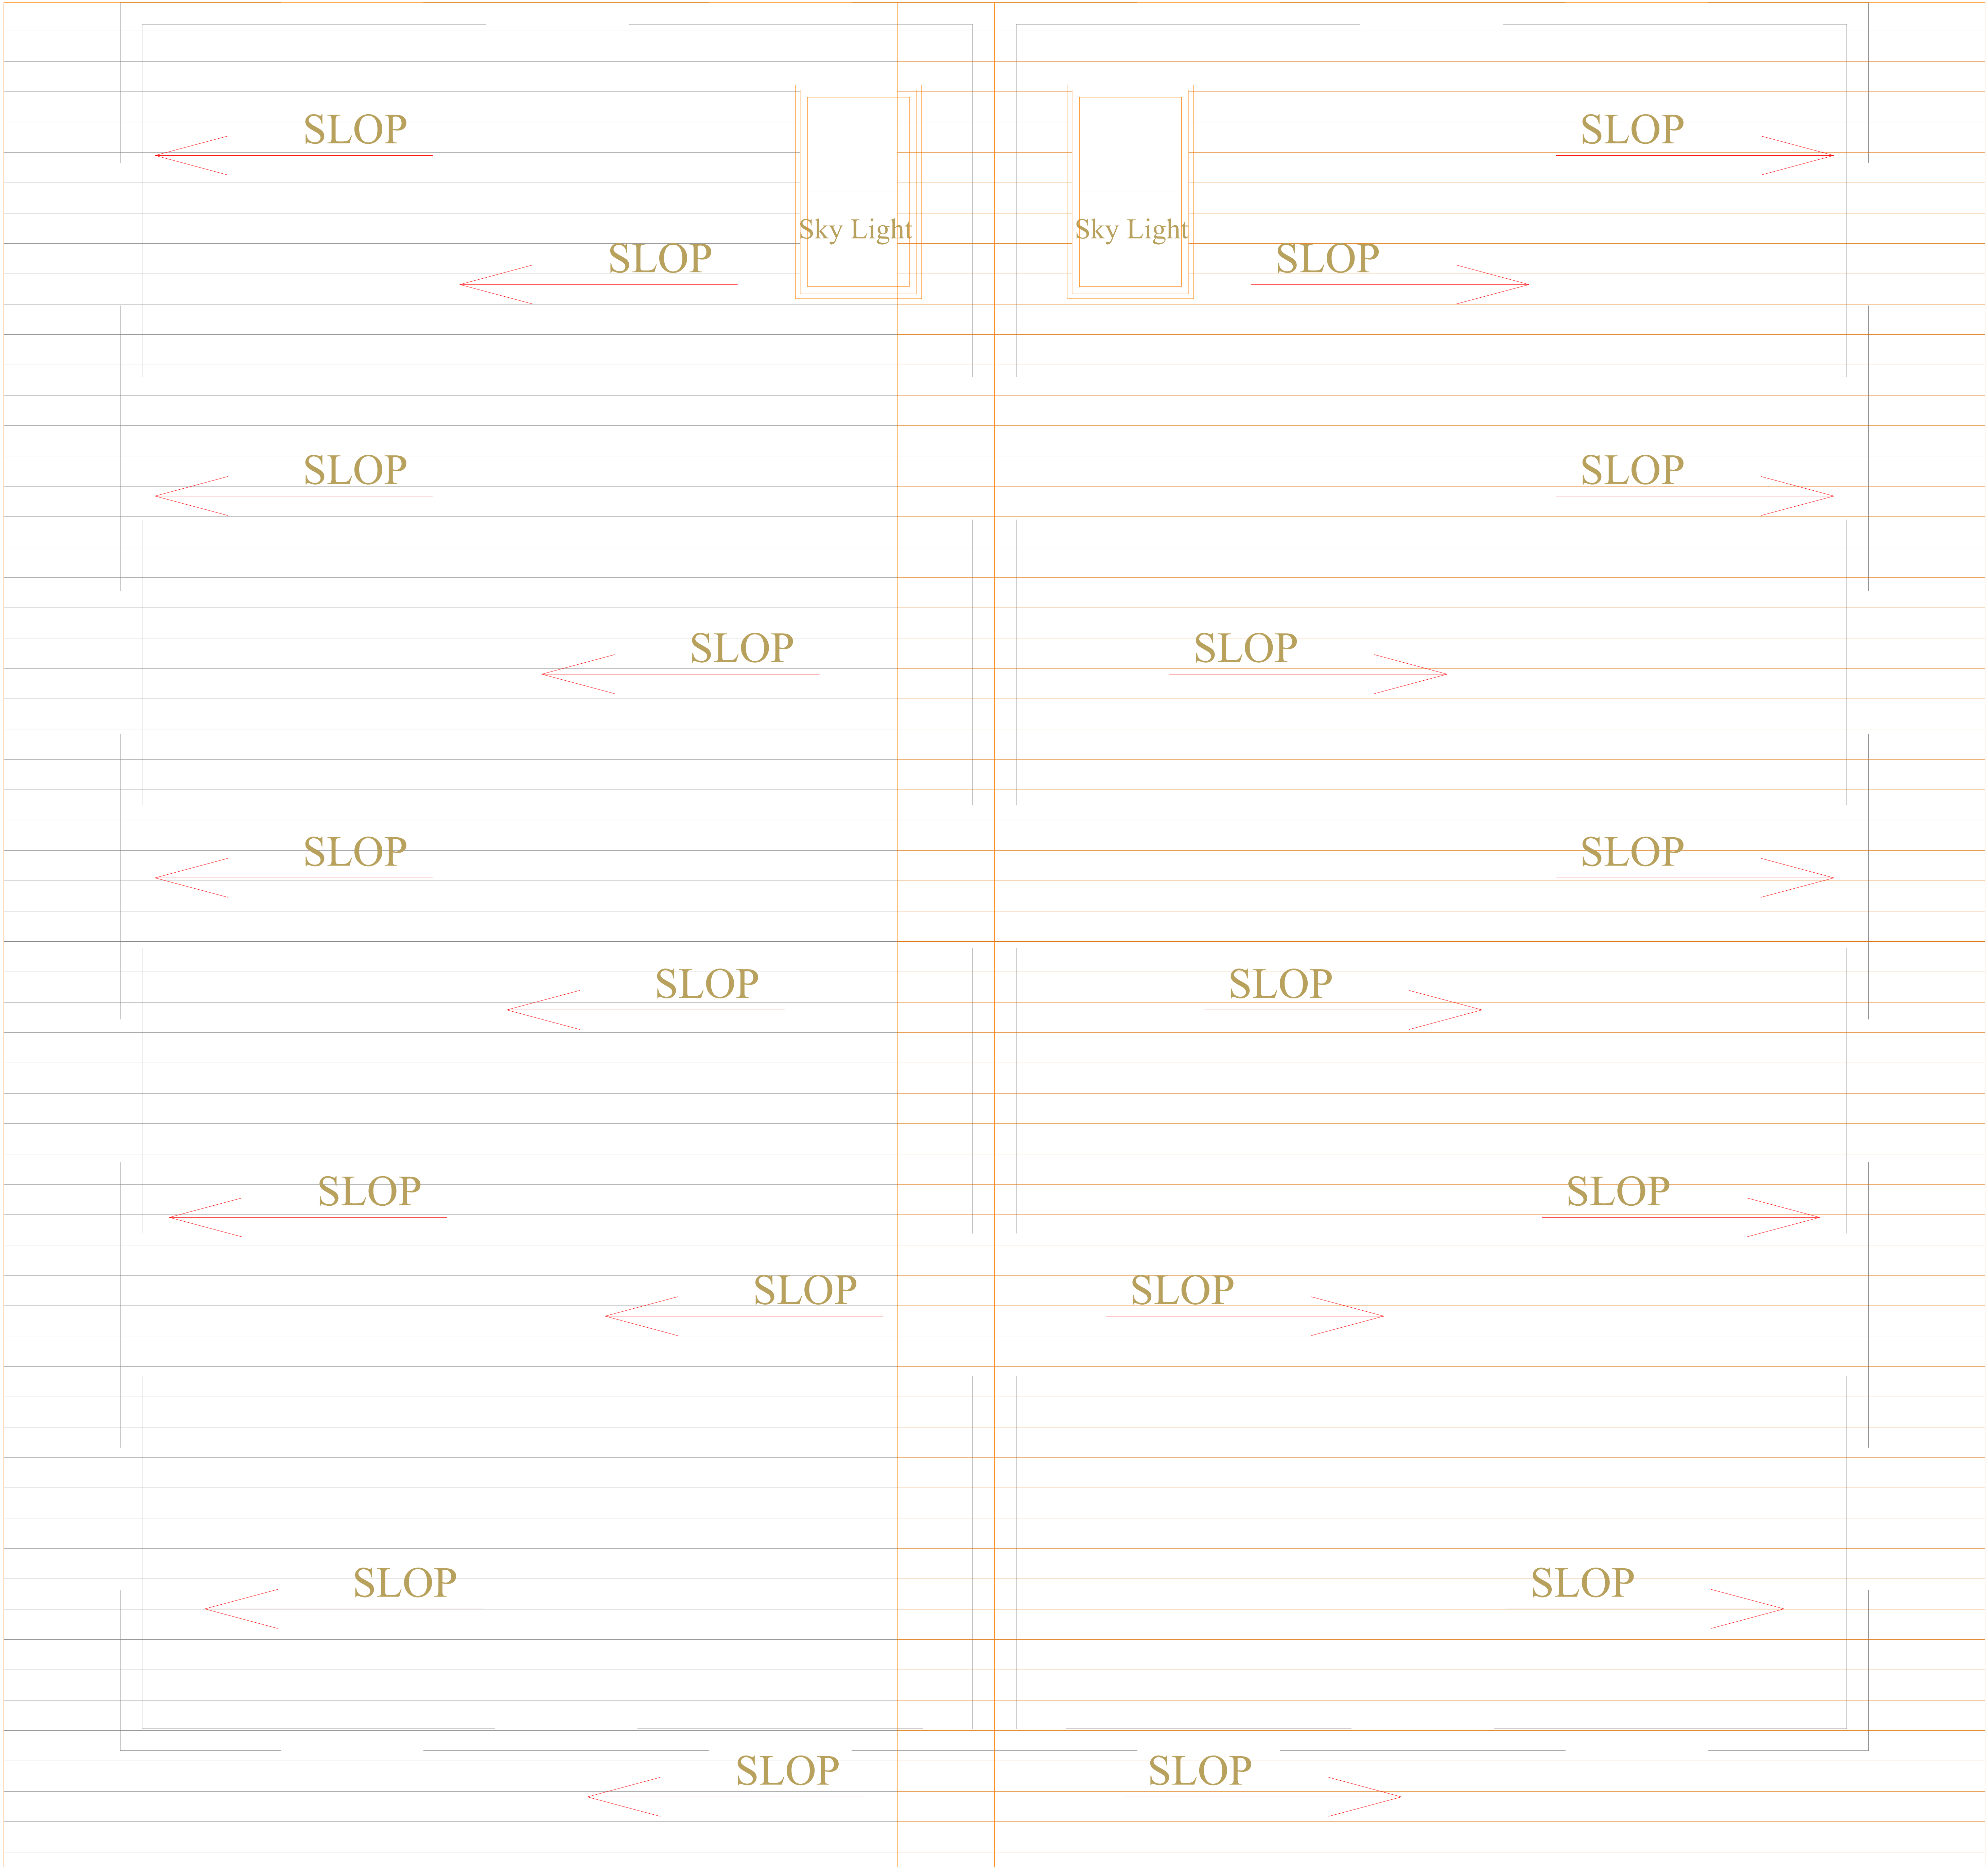


TOP ROOF PLAN

NOTE:-
SOAKAGE PIT STRUCTURE SHALL BE DESIGNED
BY CIVIL ENGINEER.


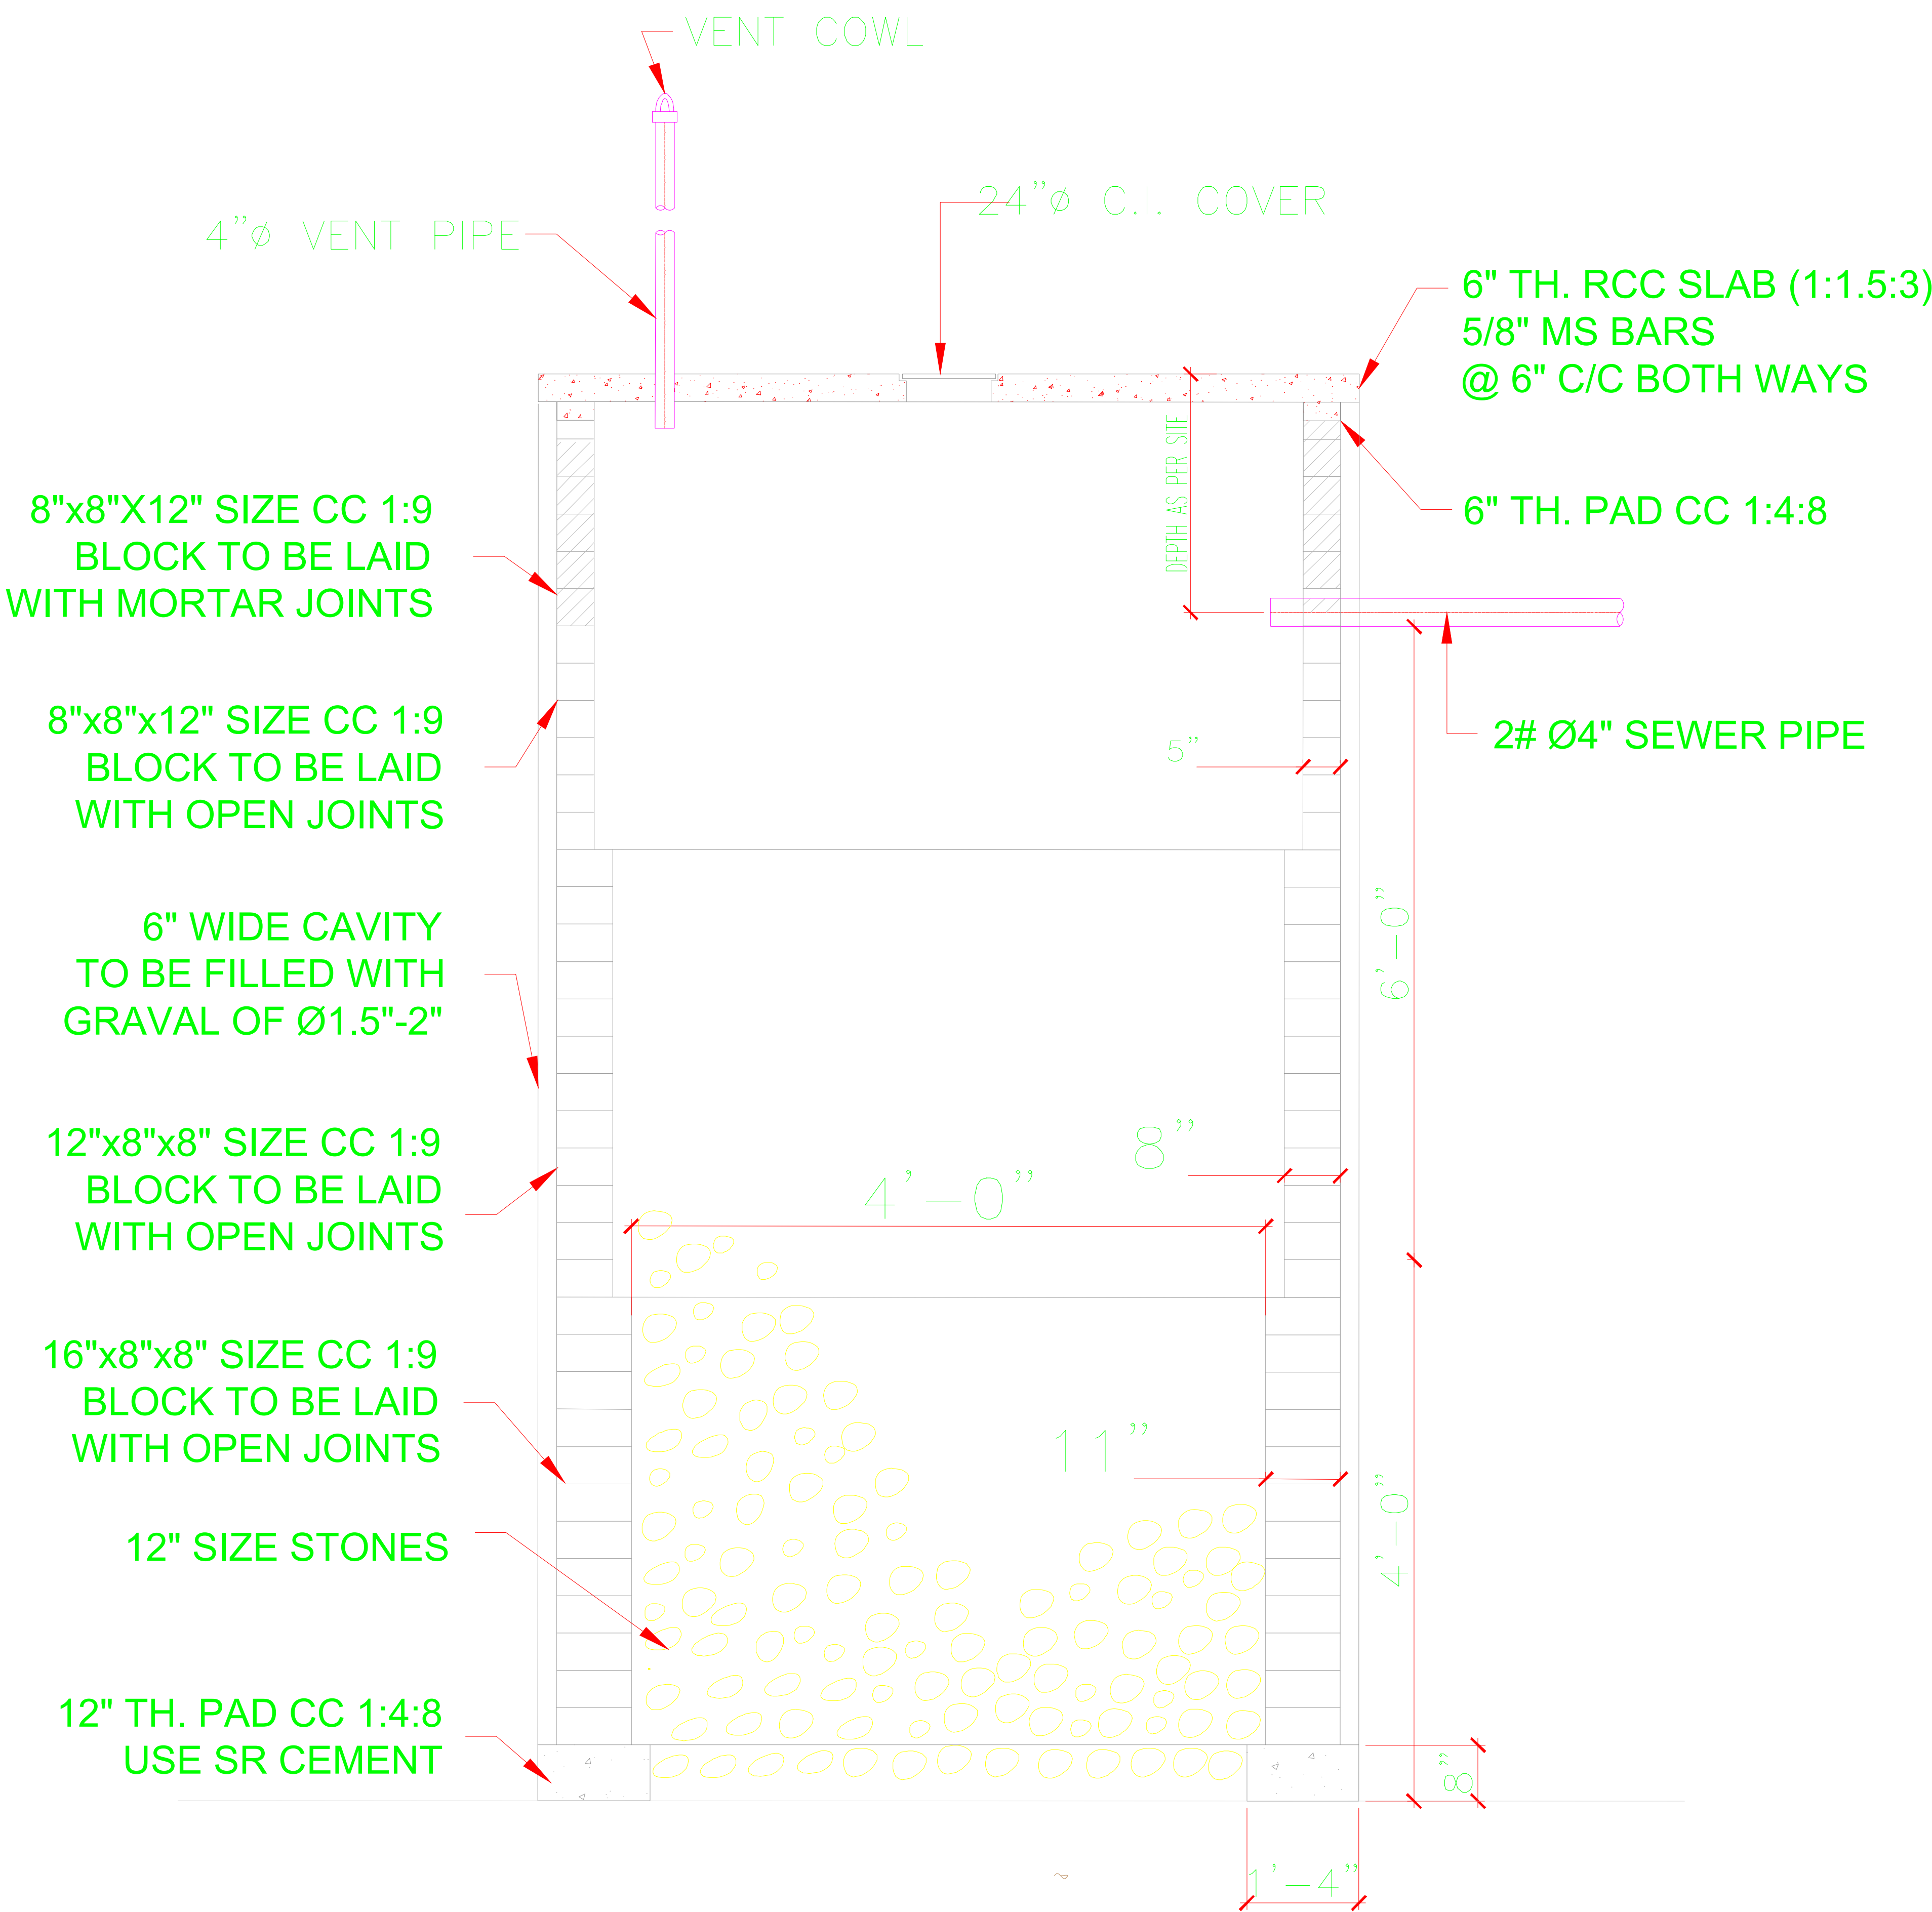
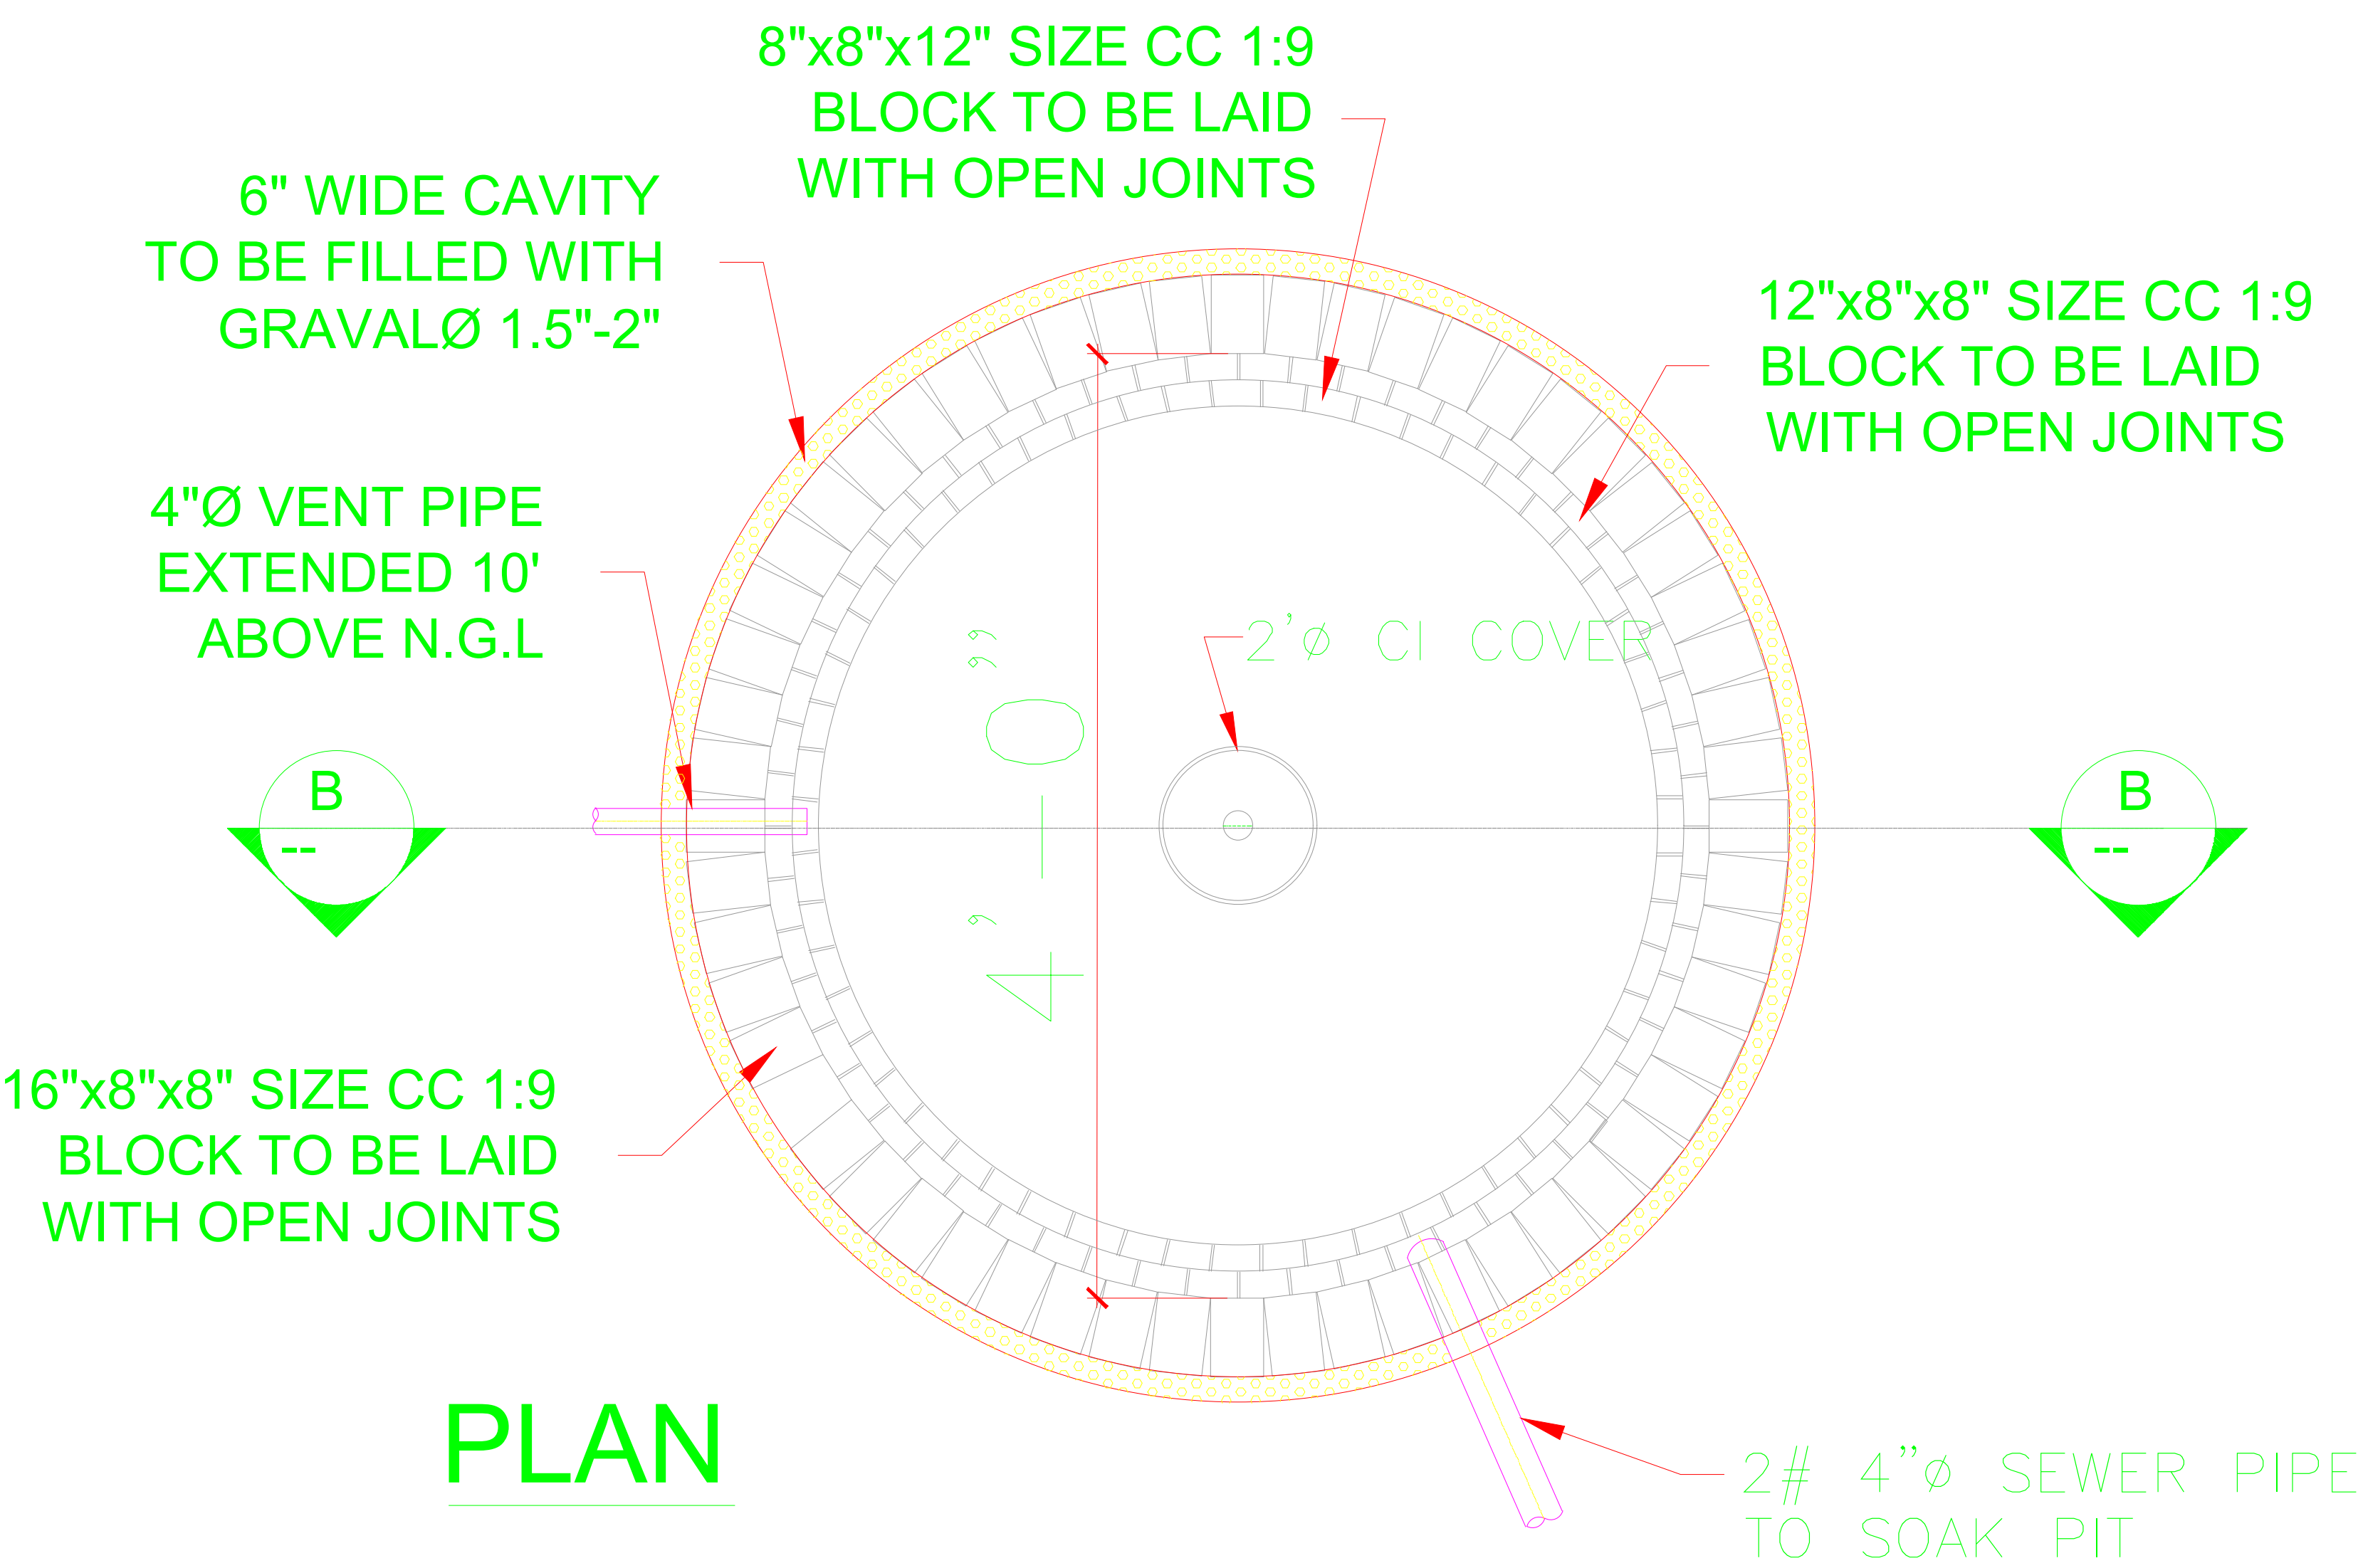


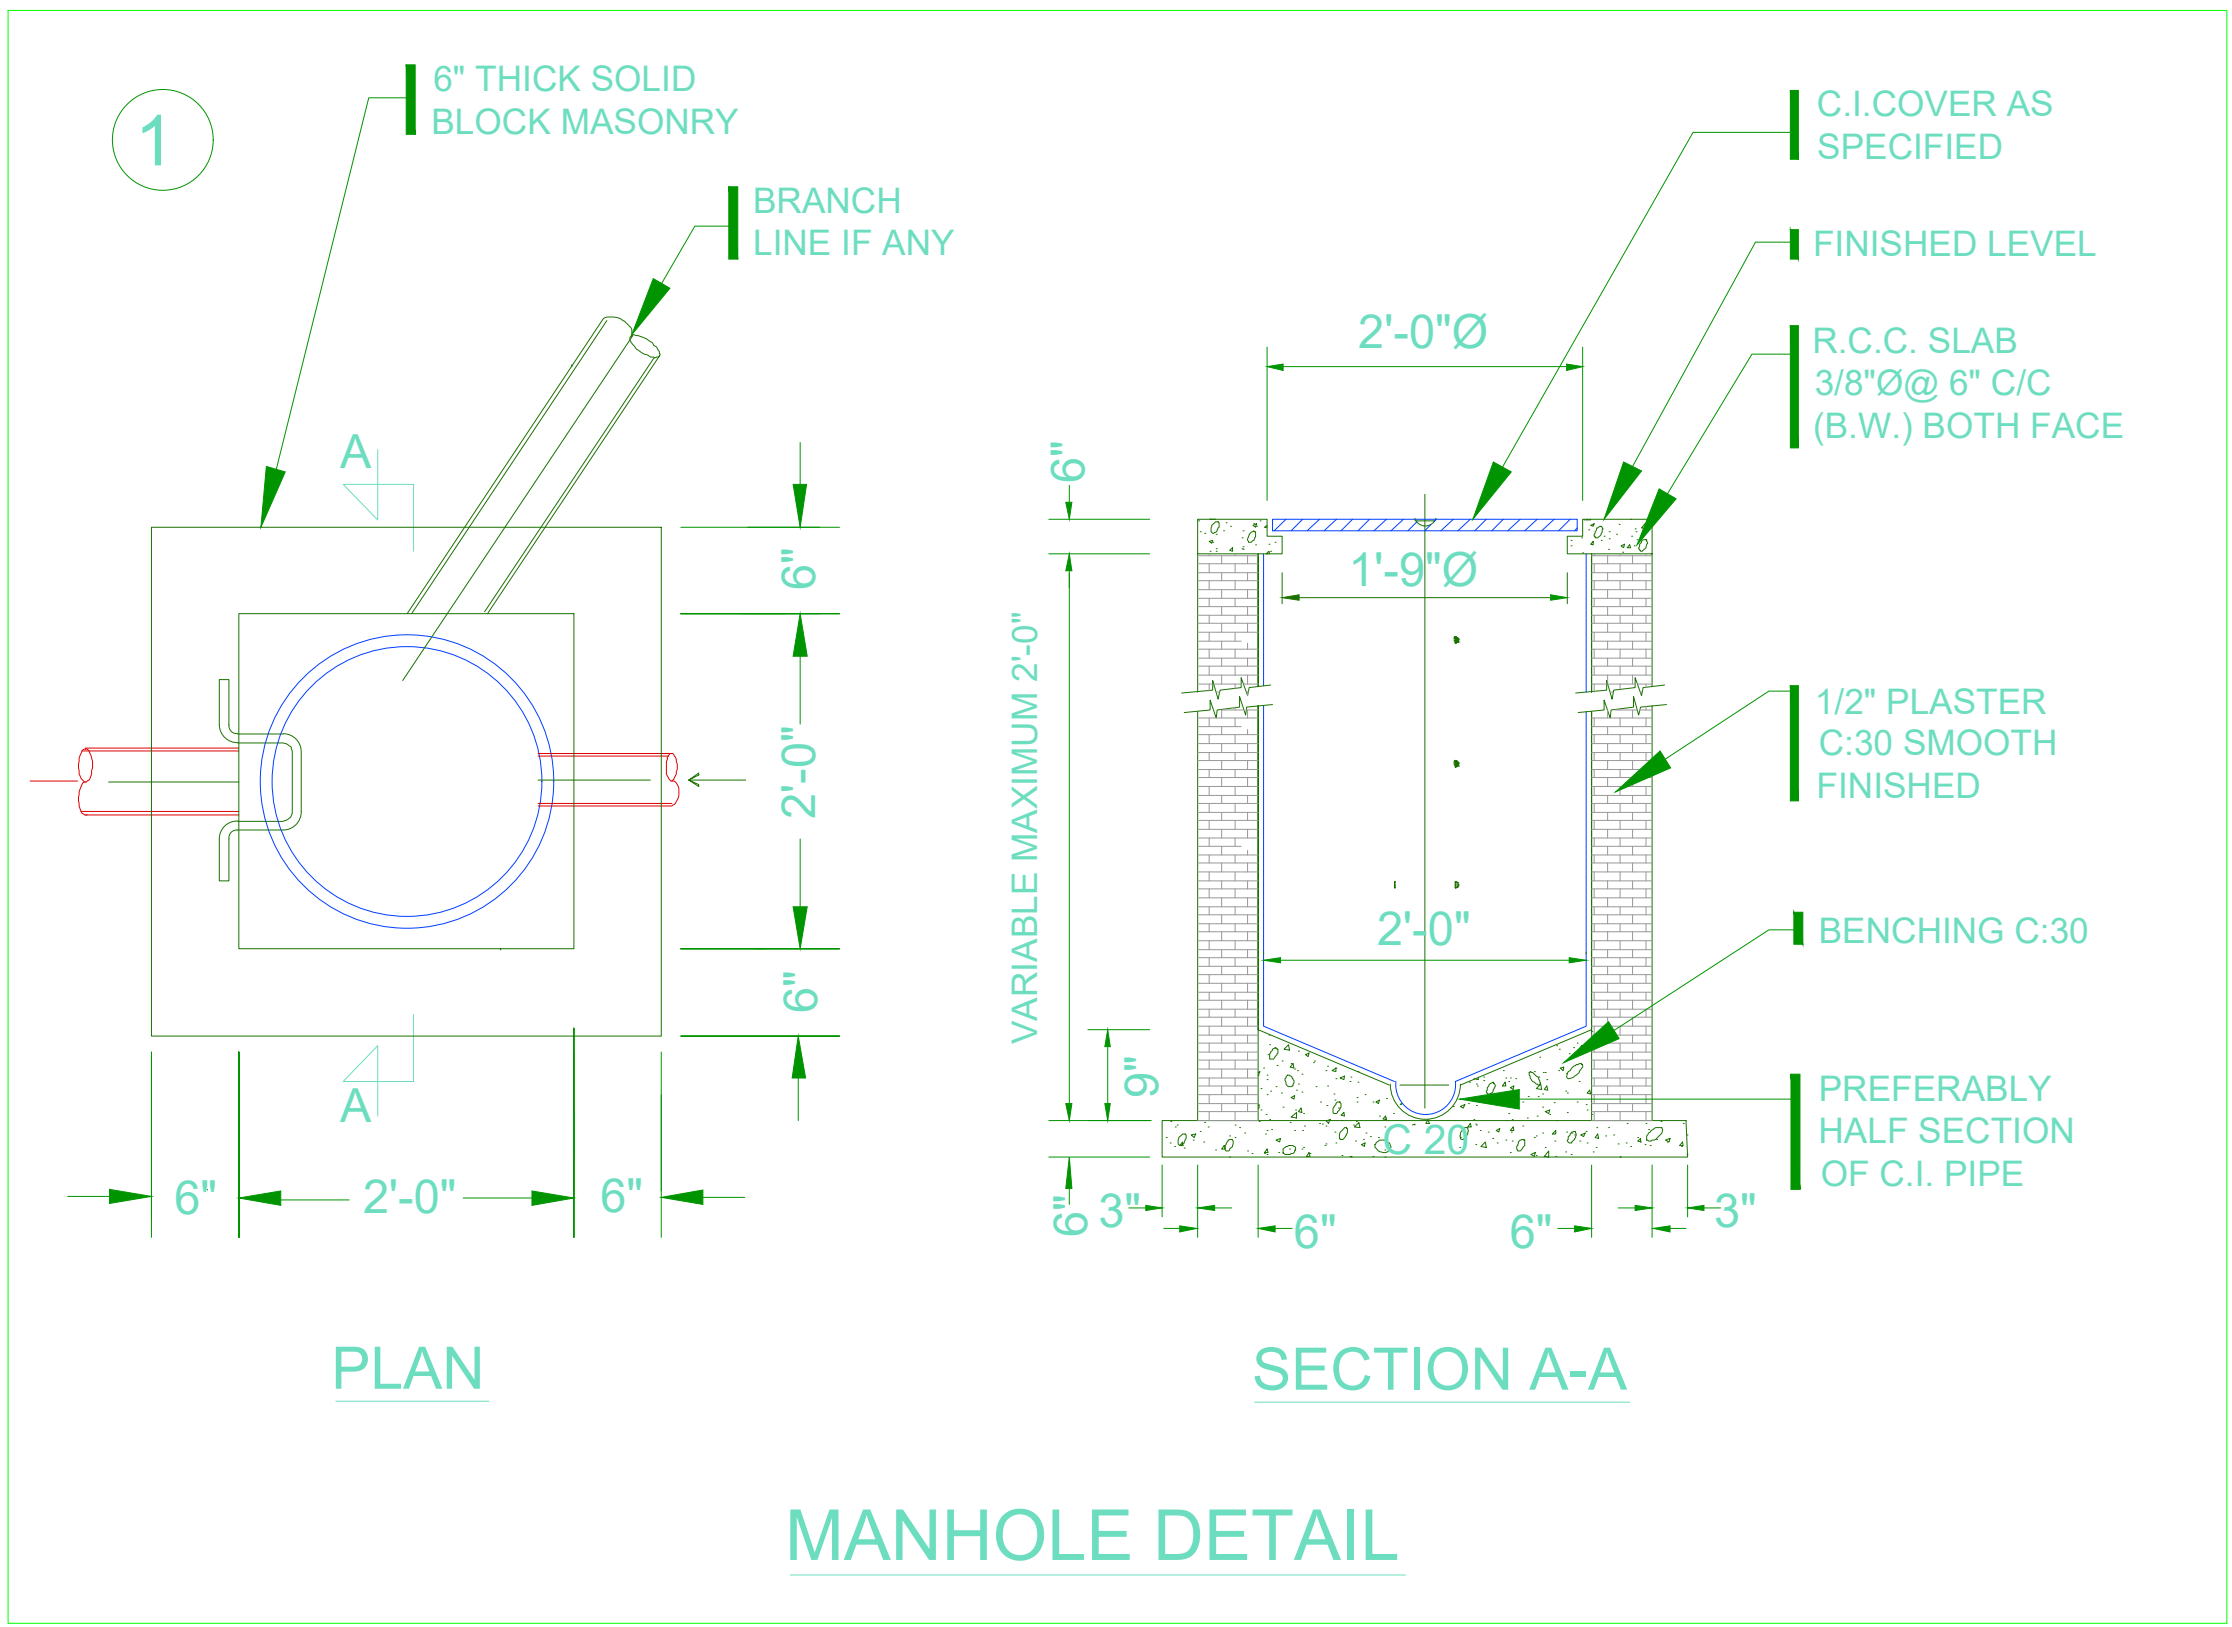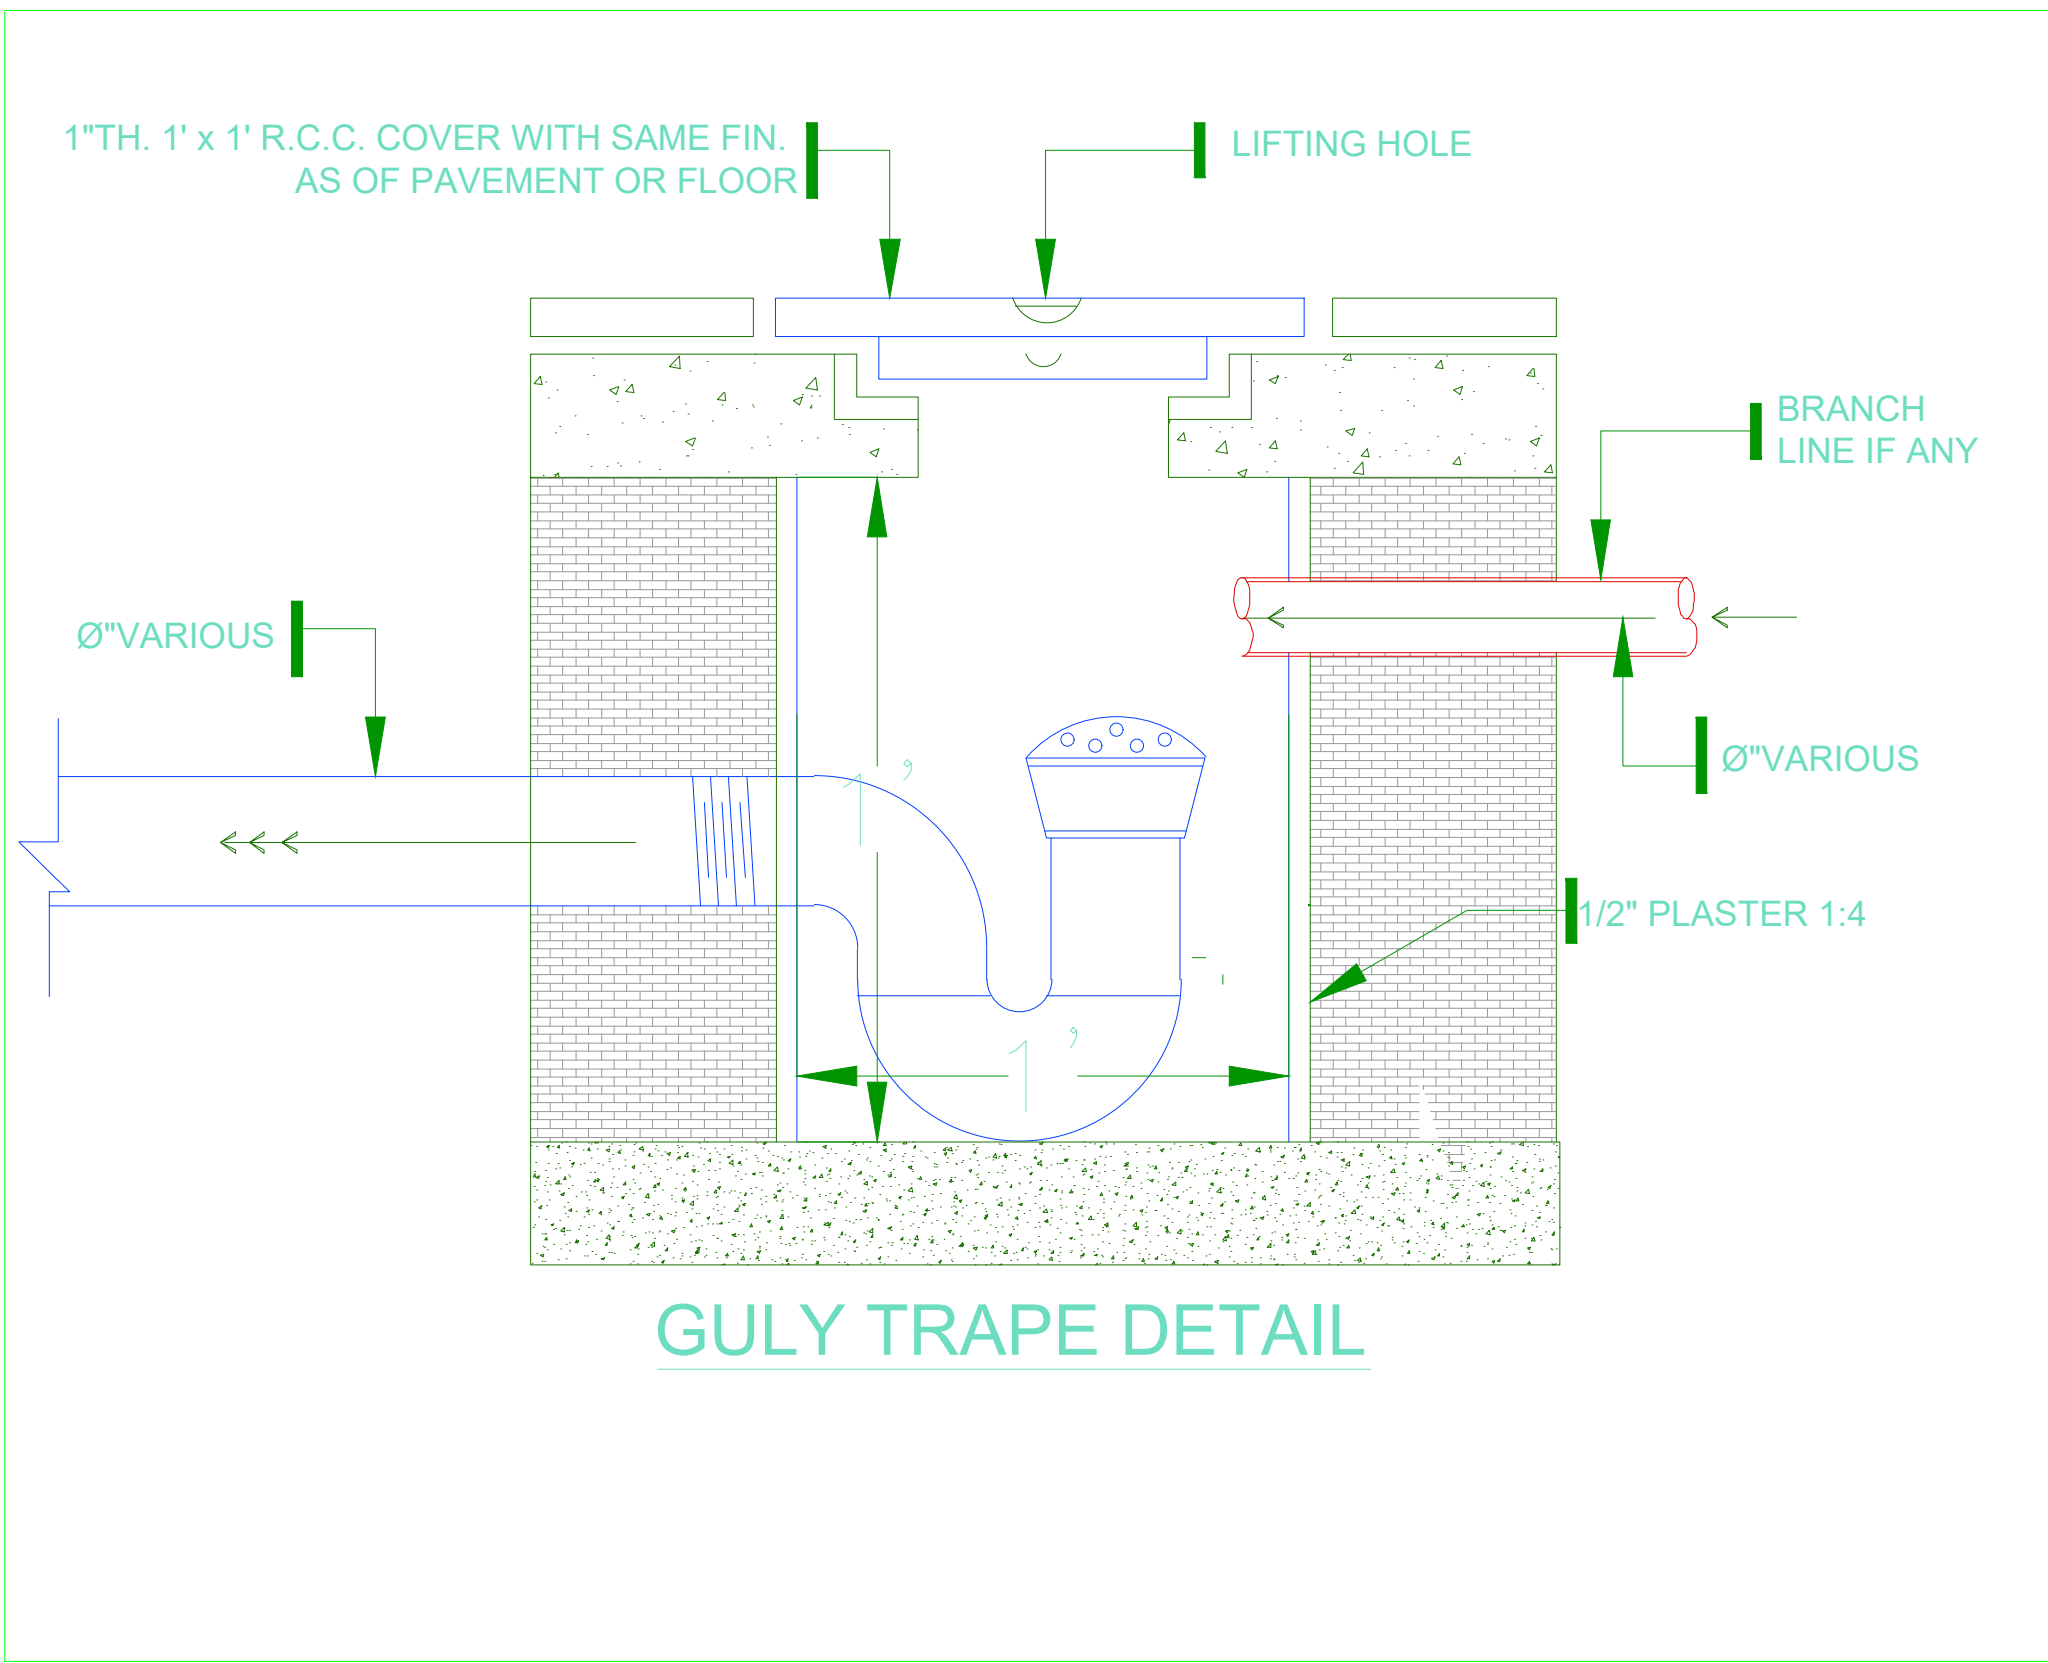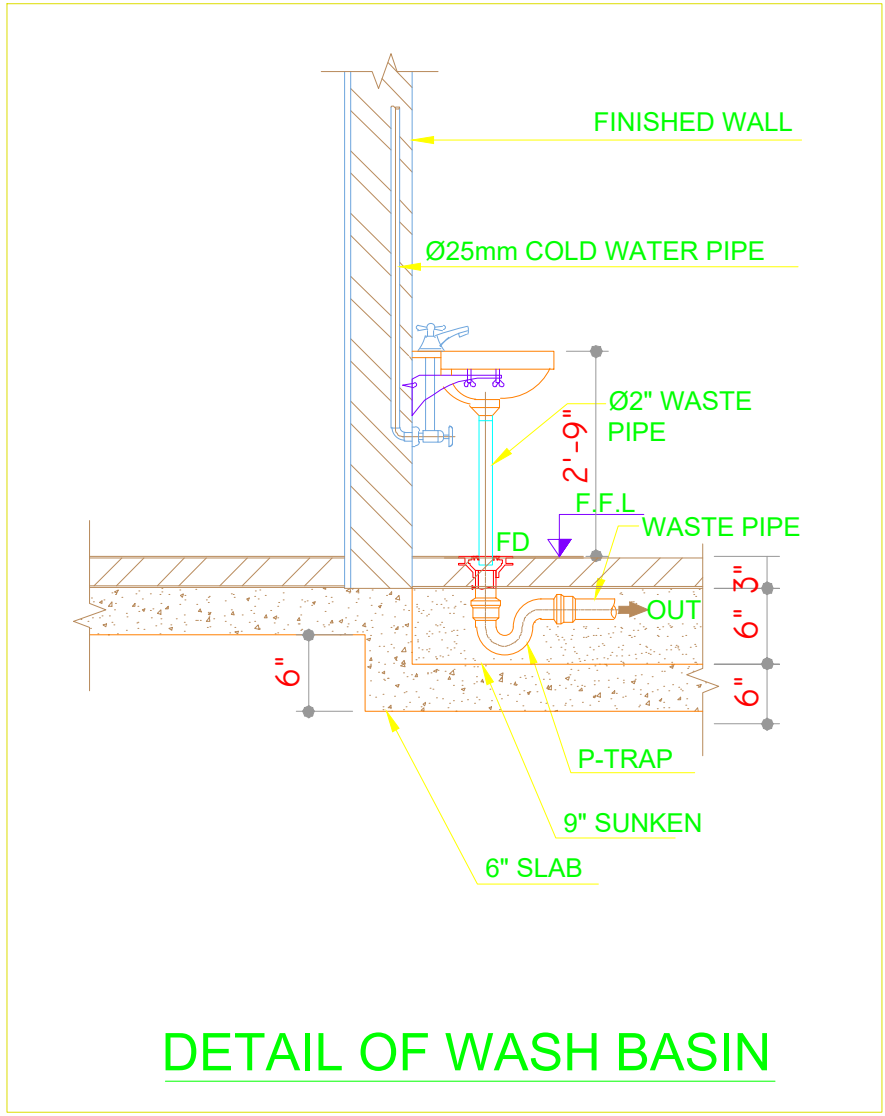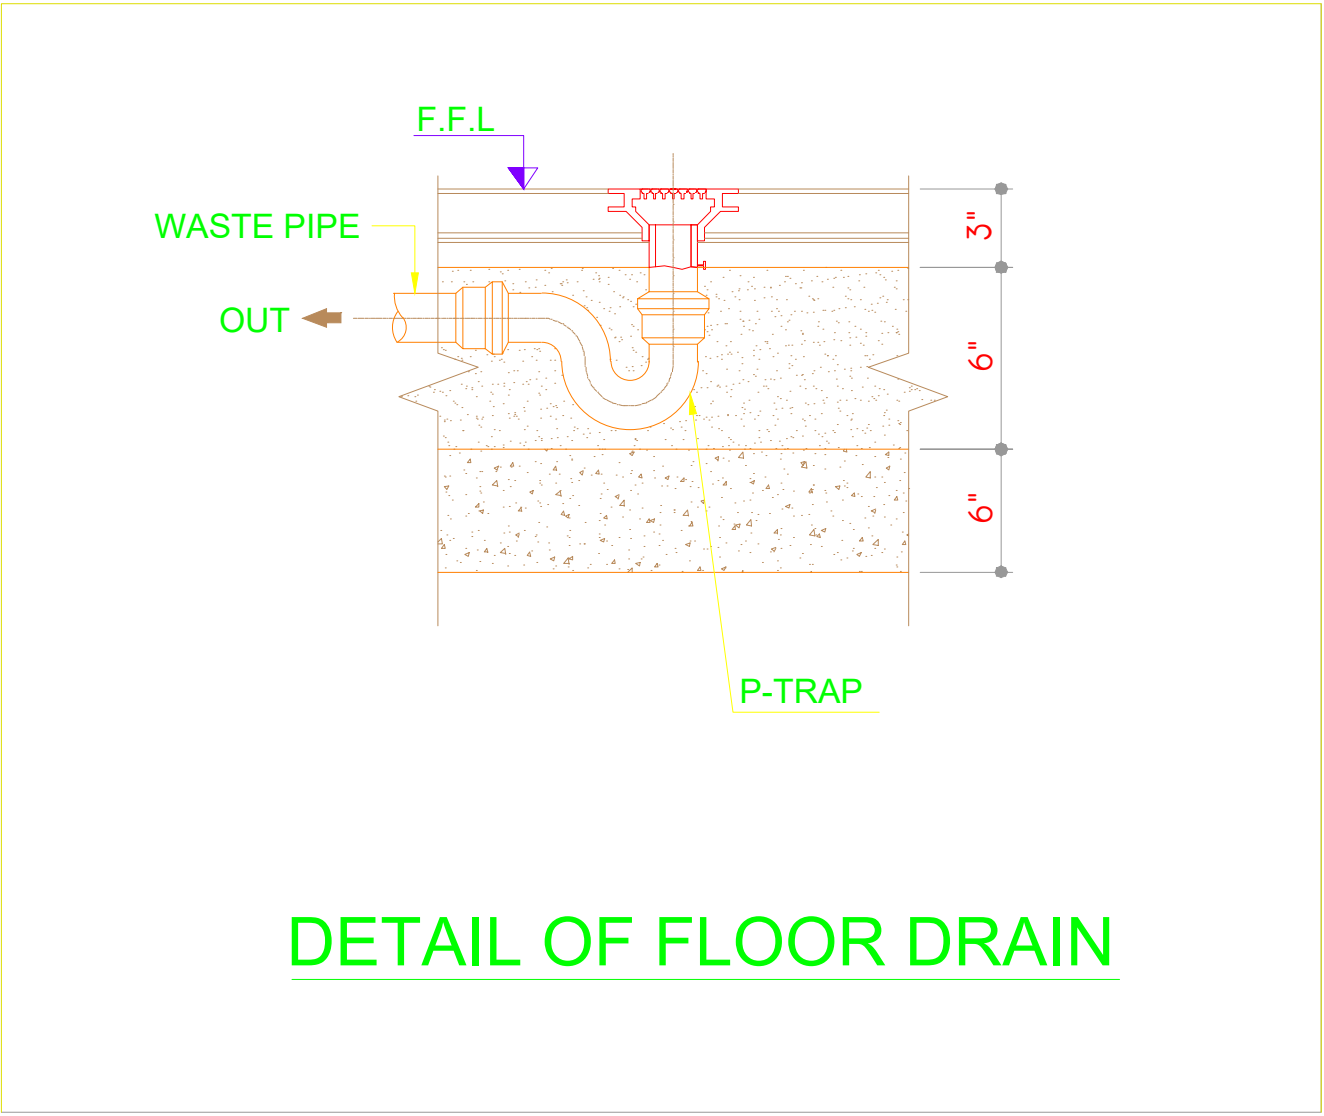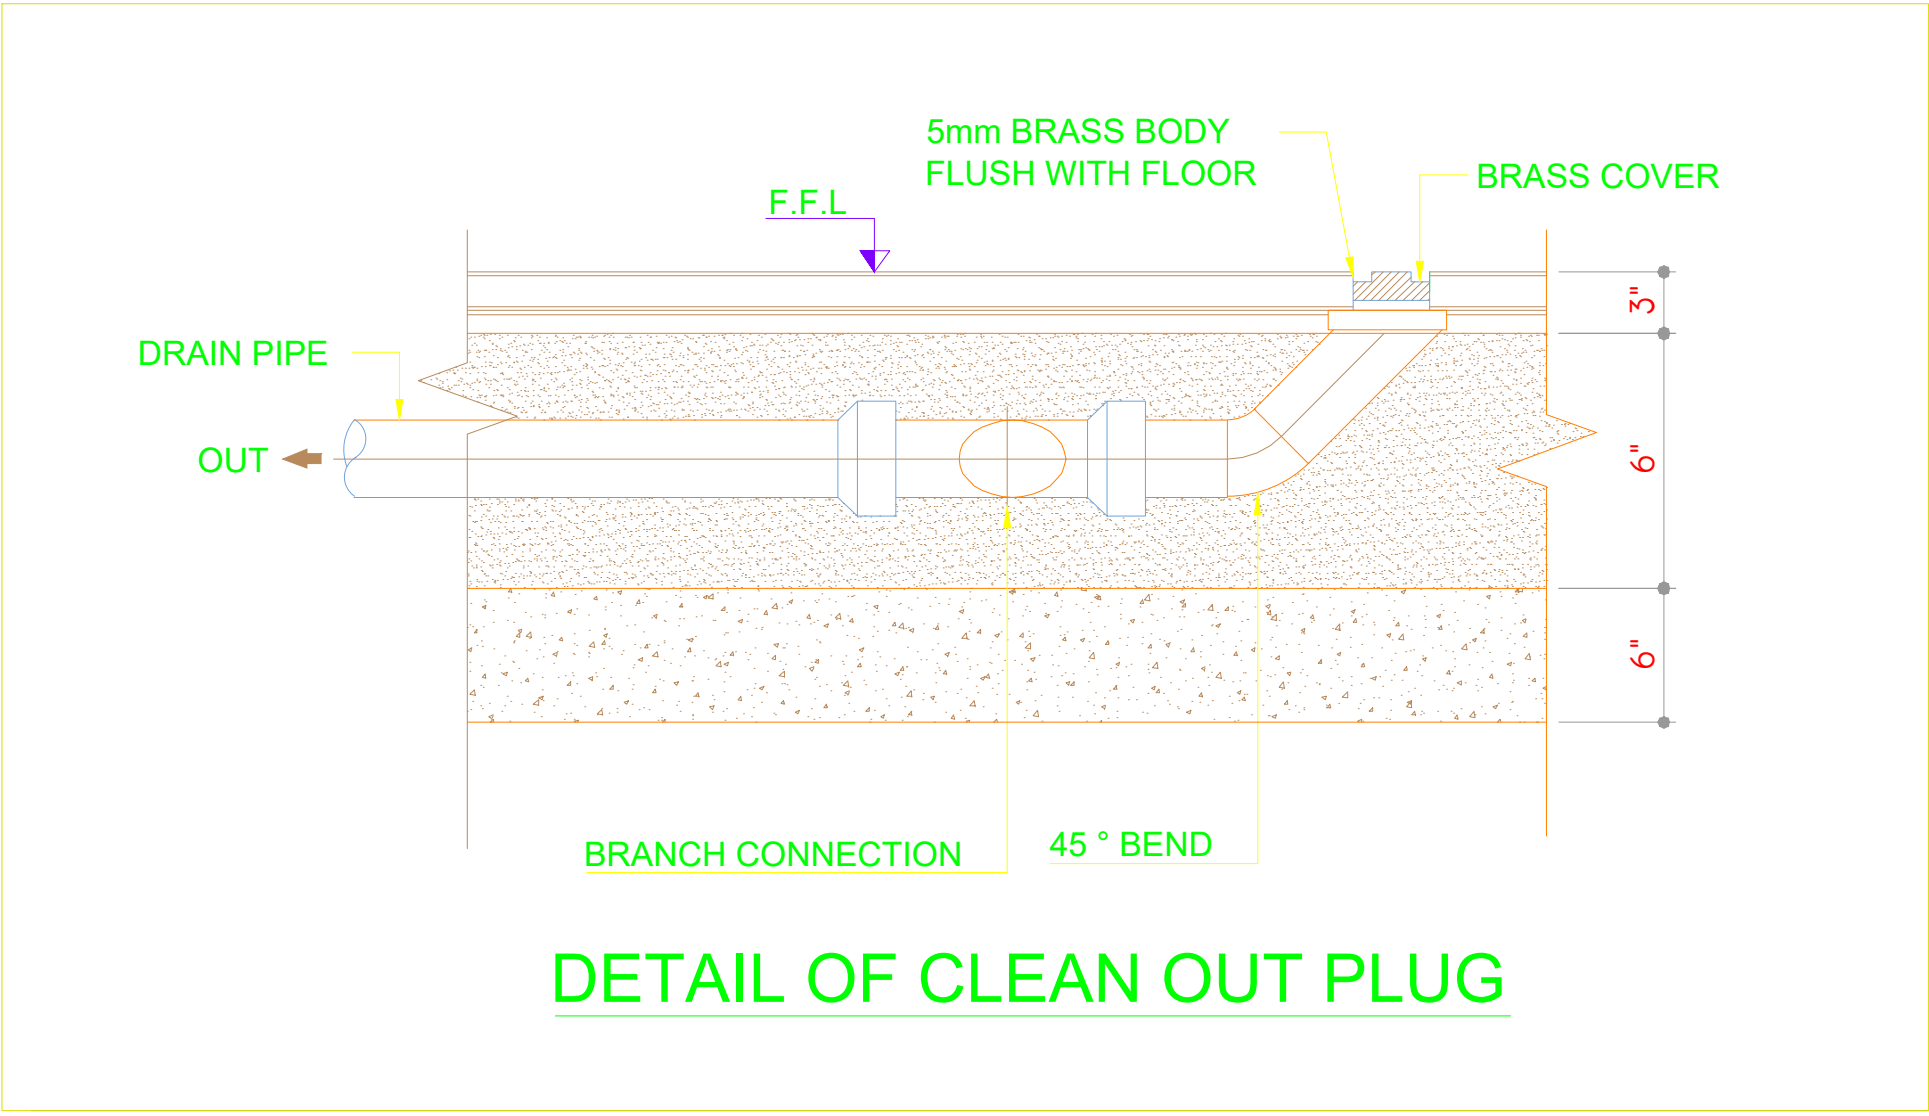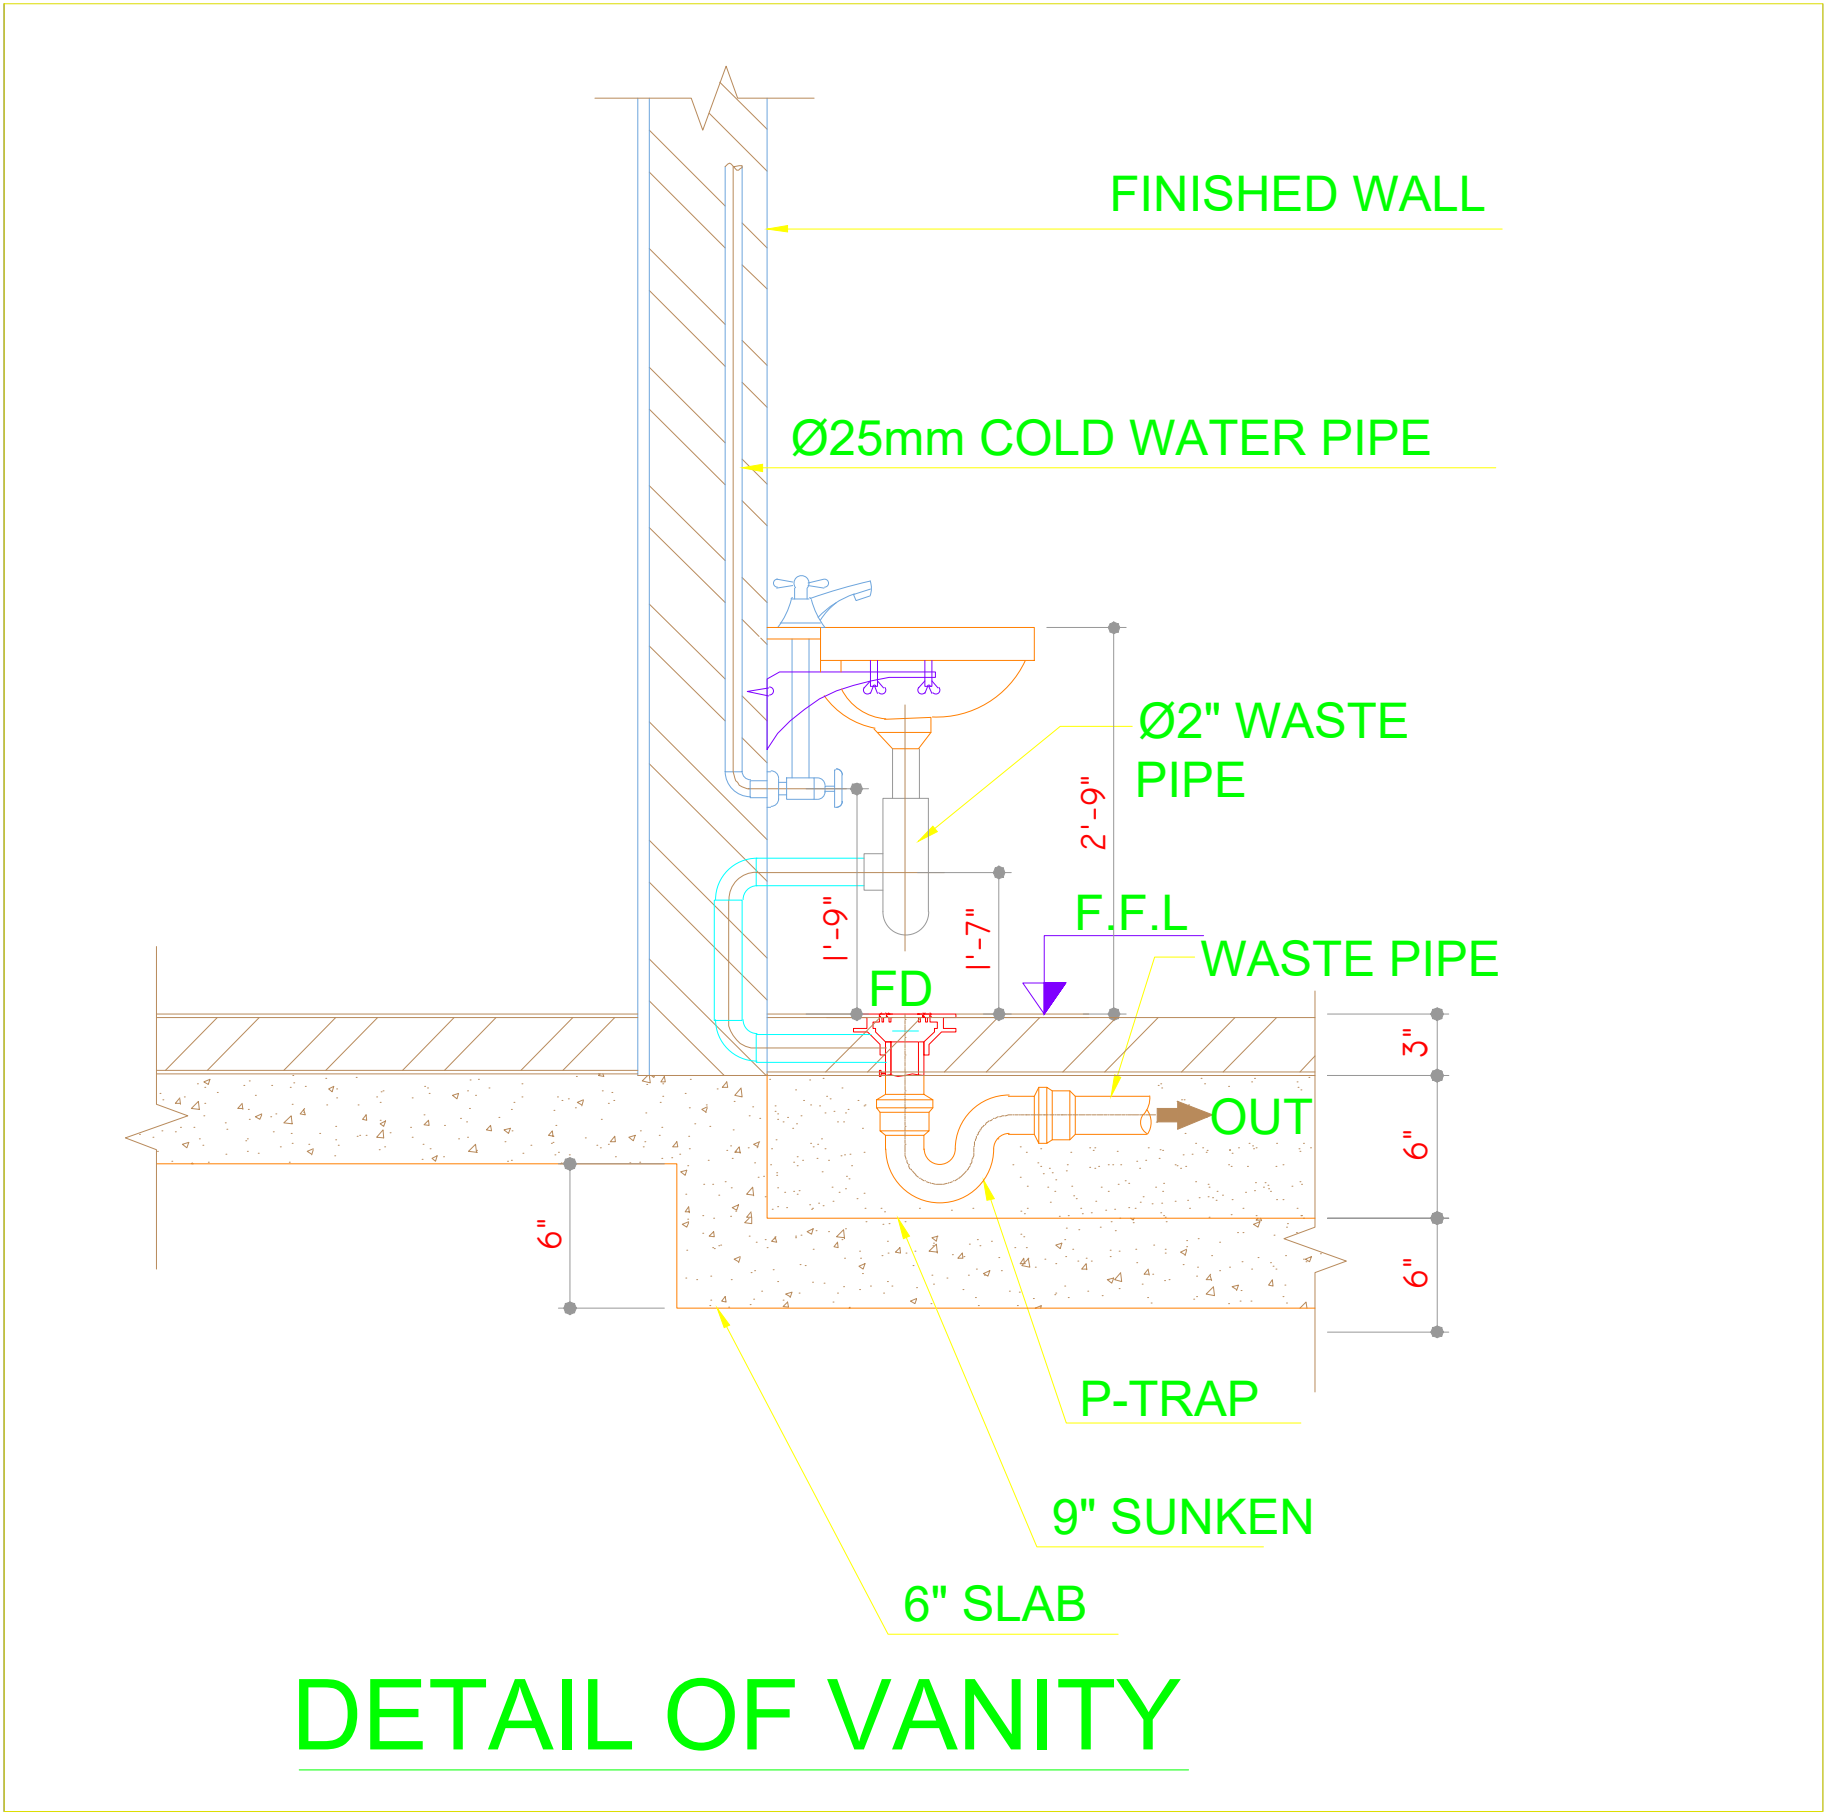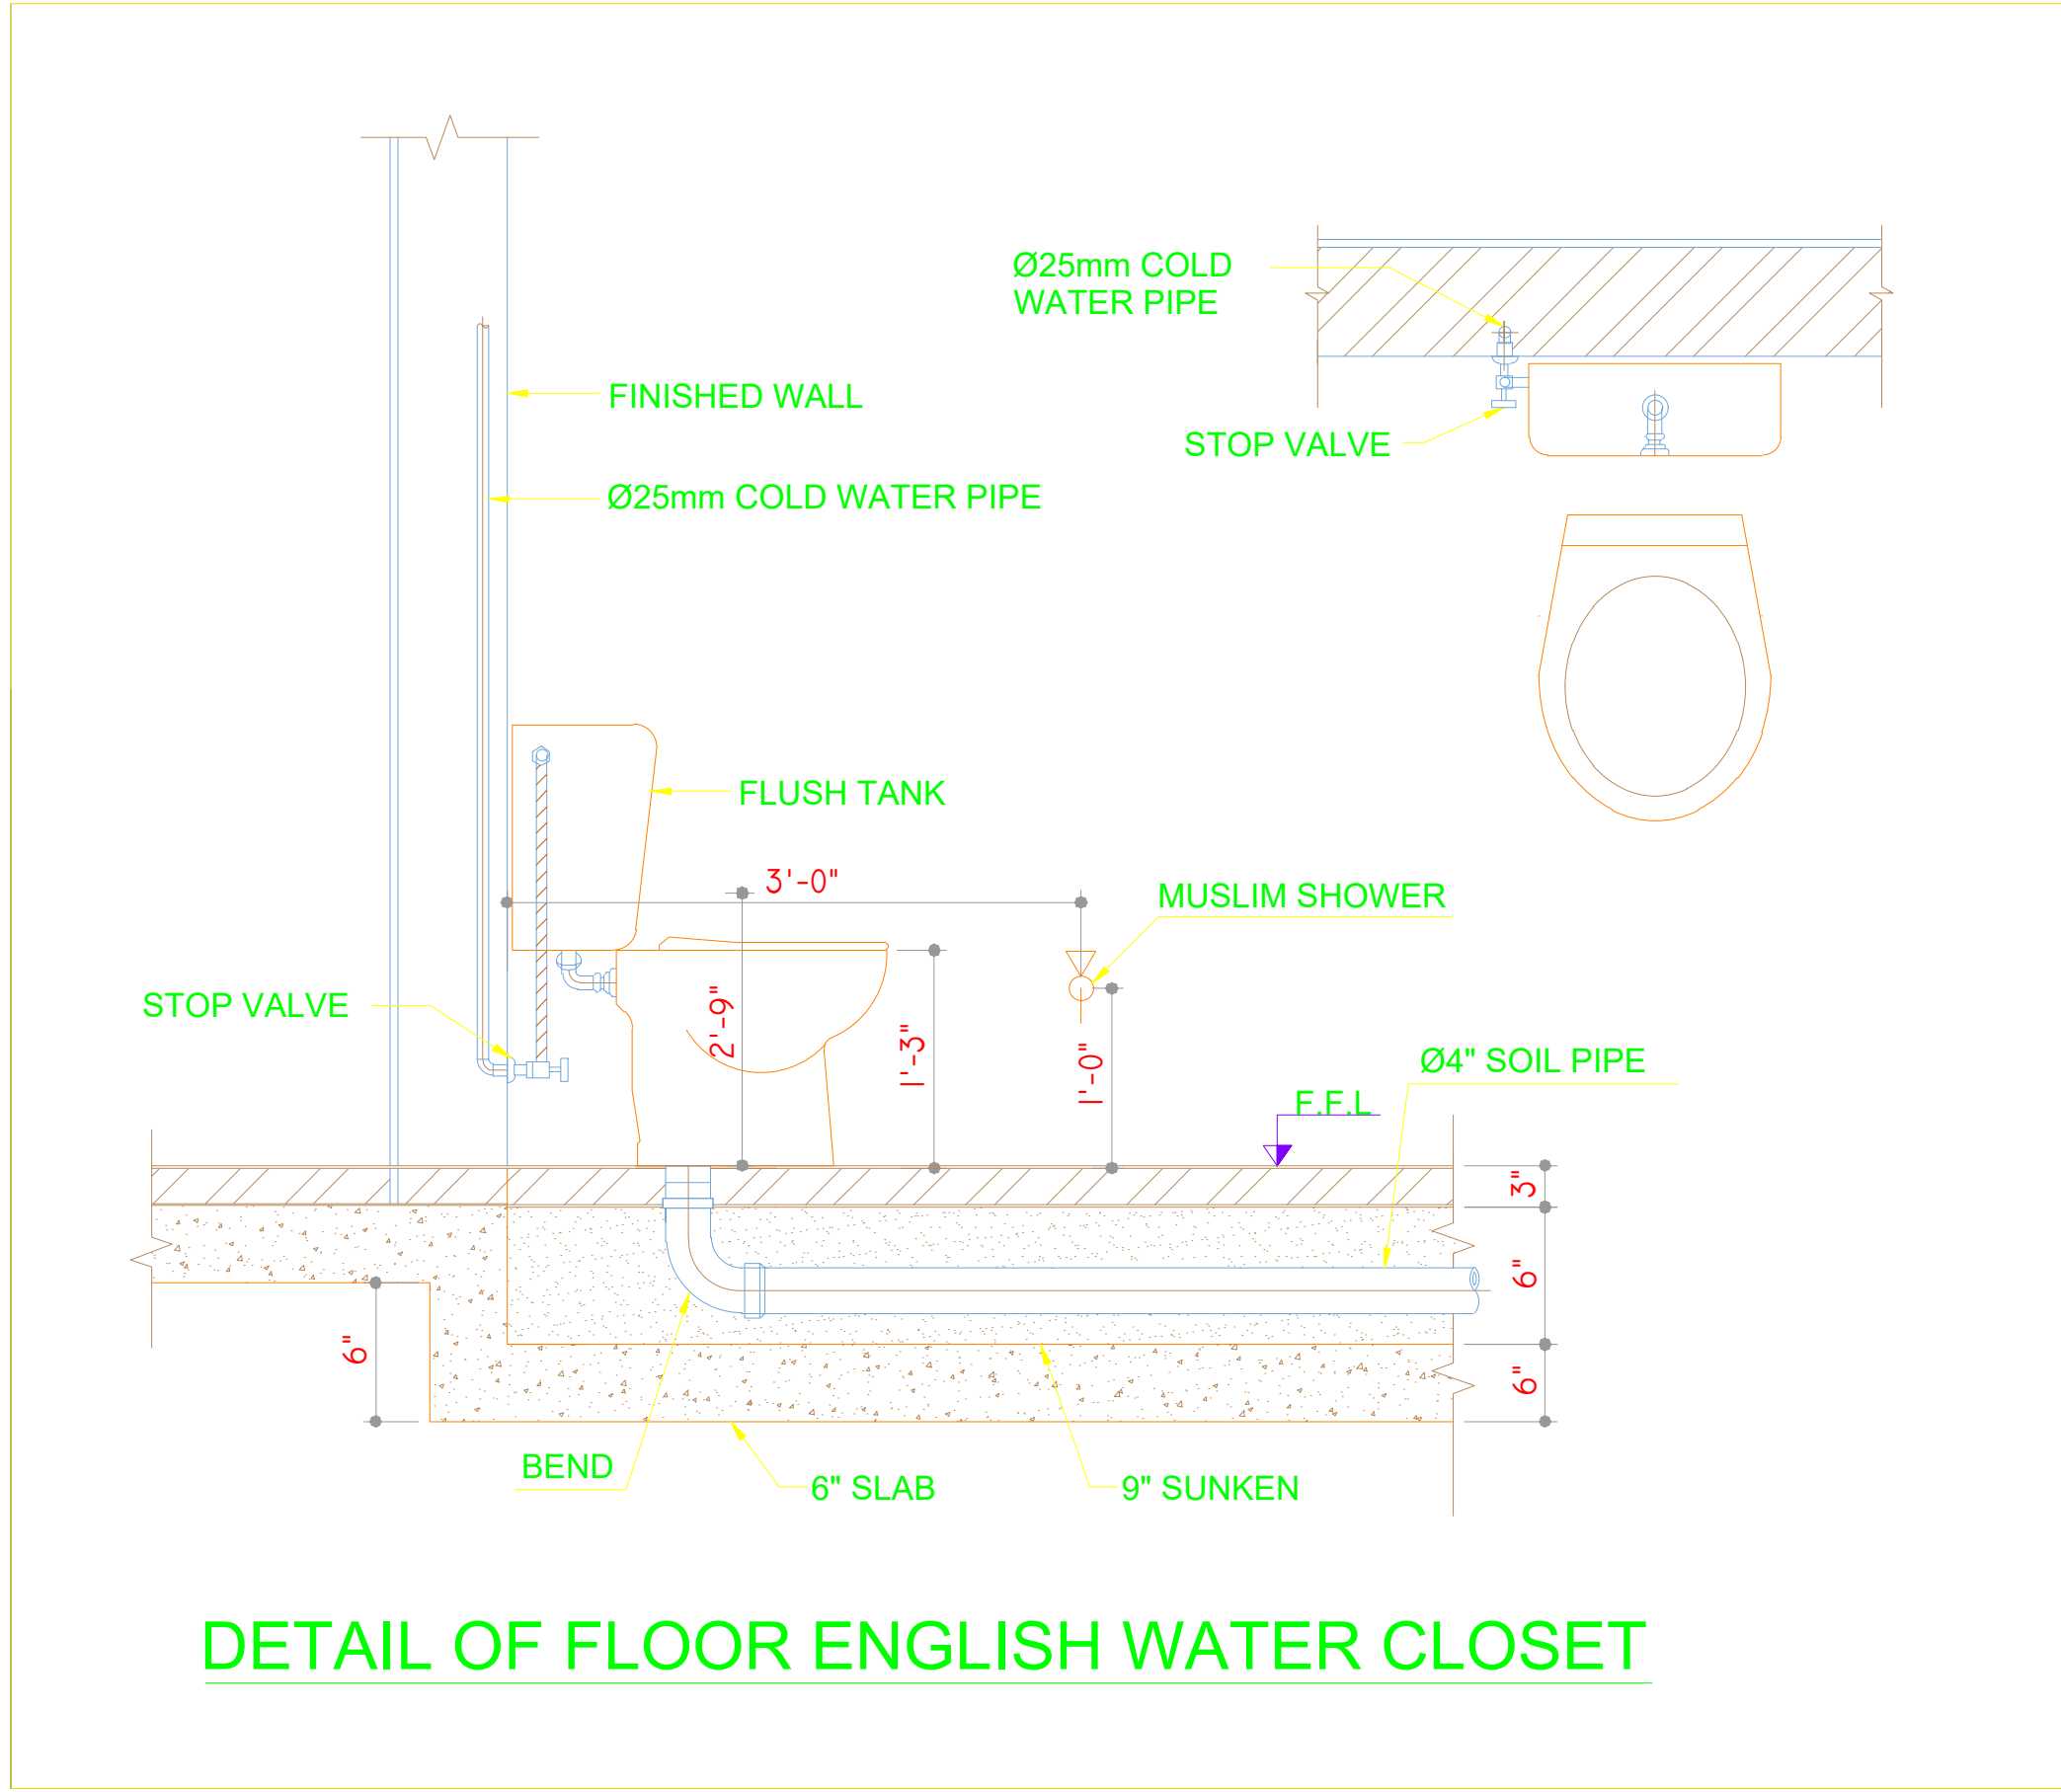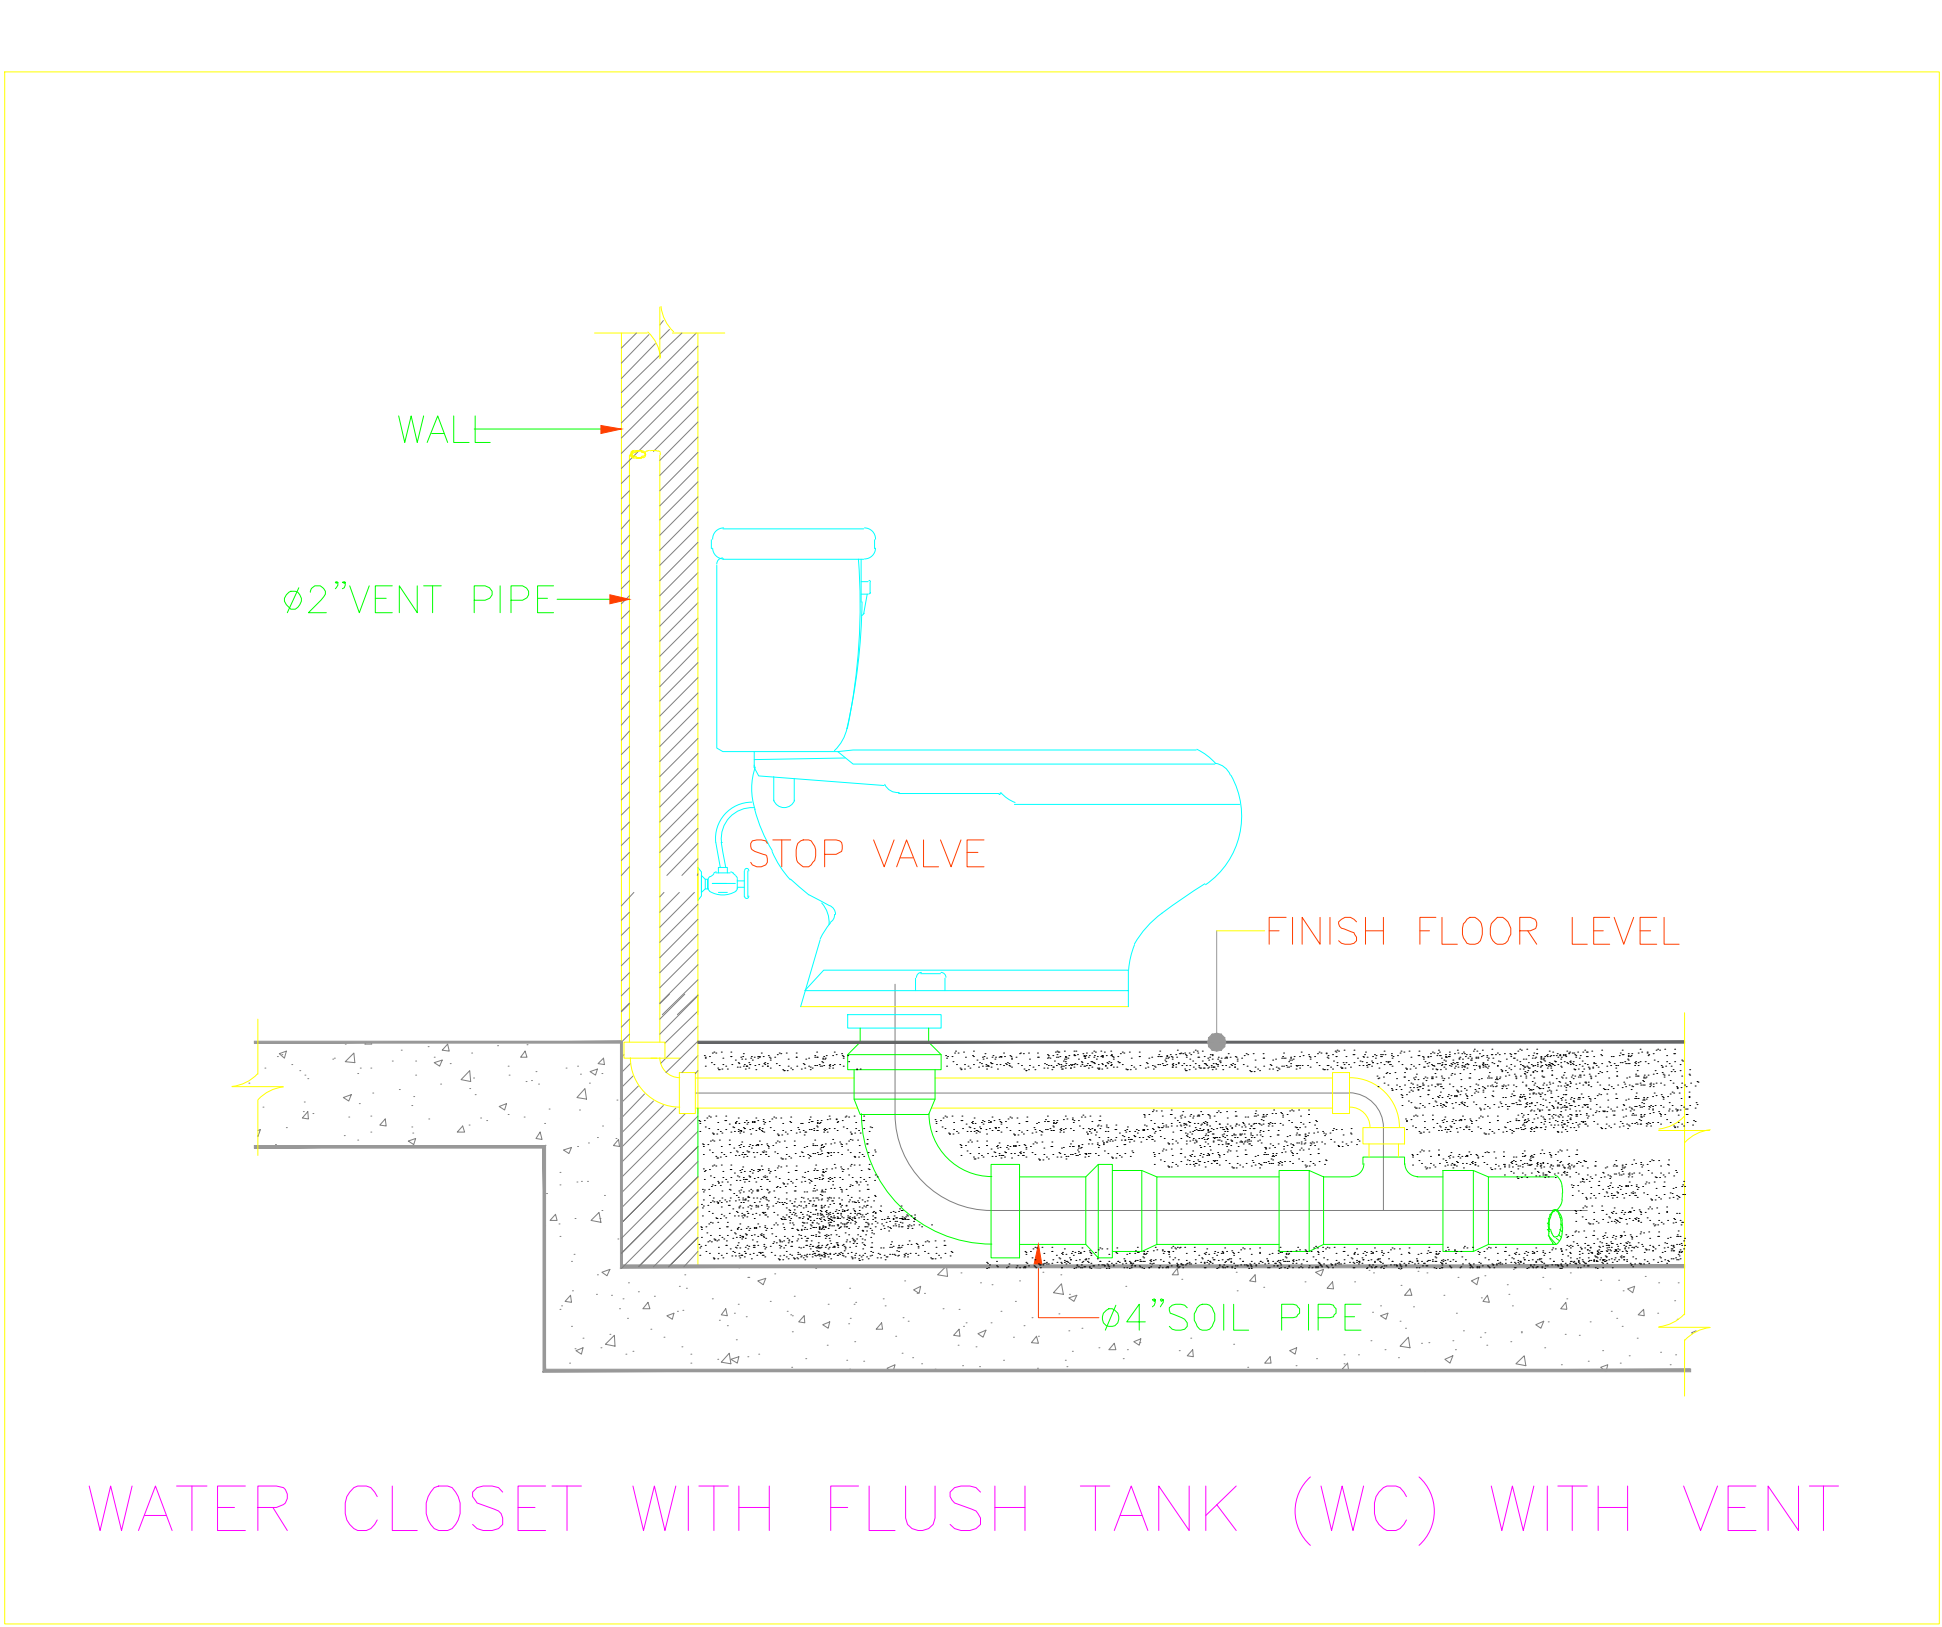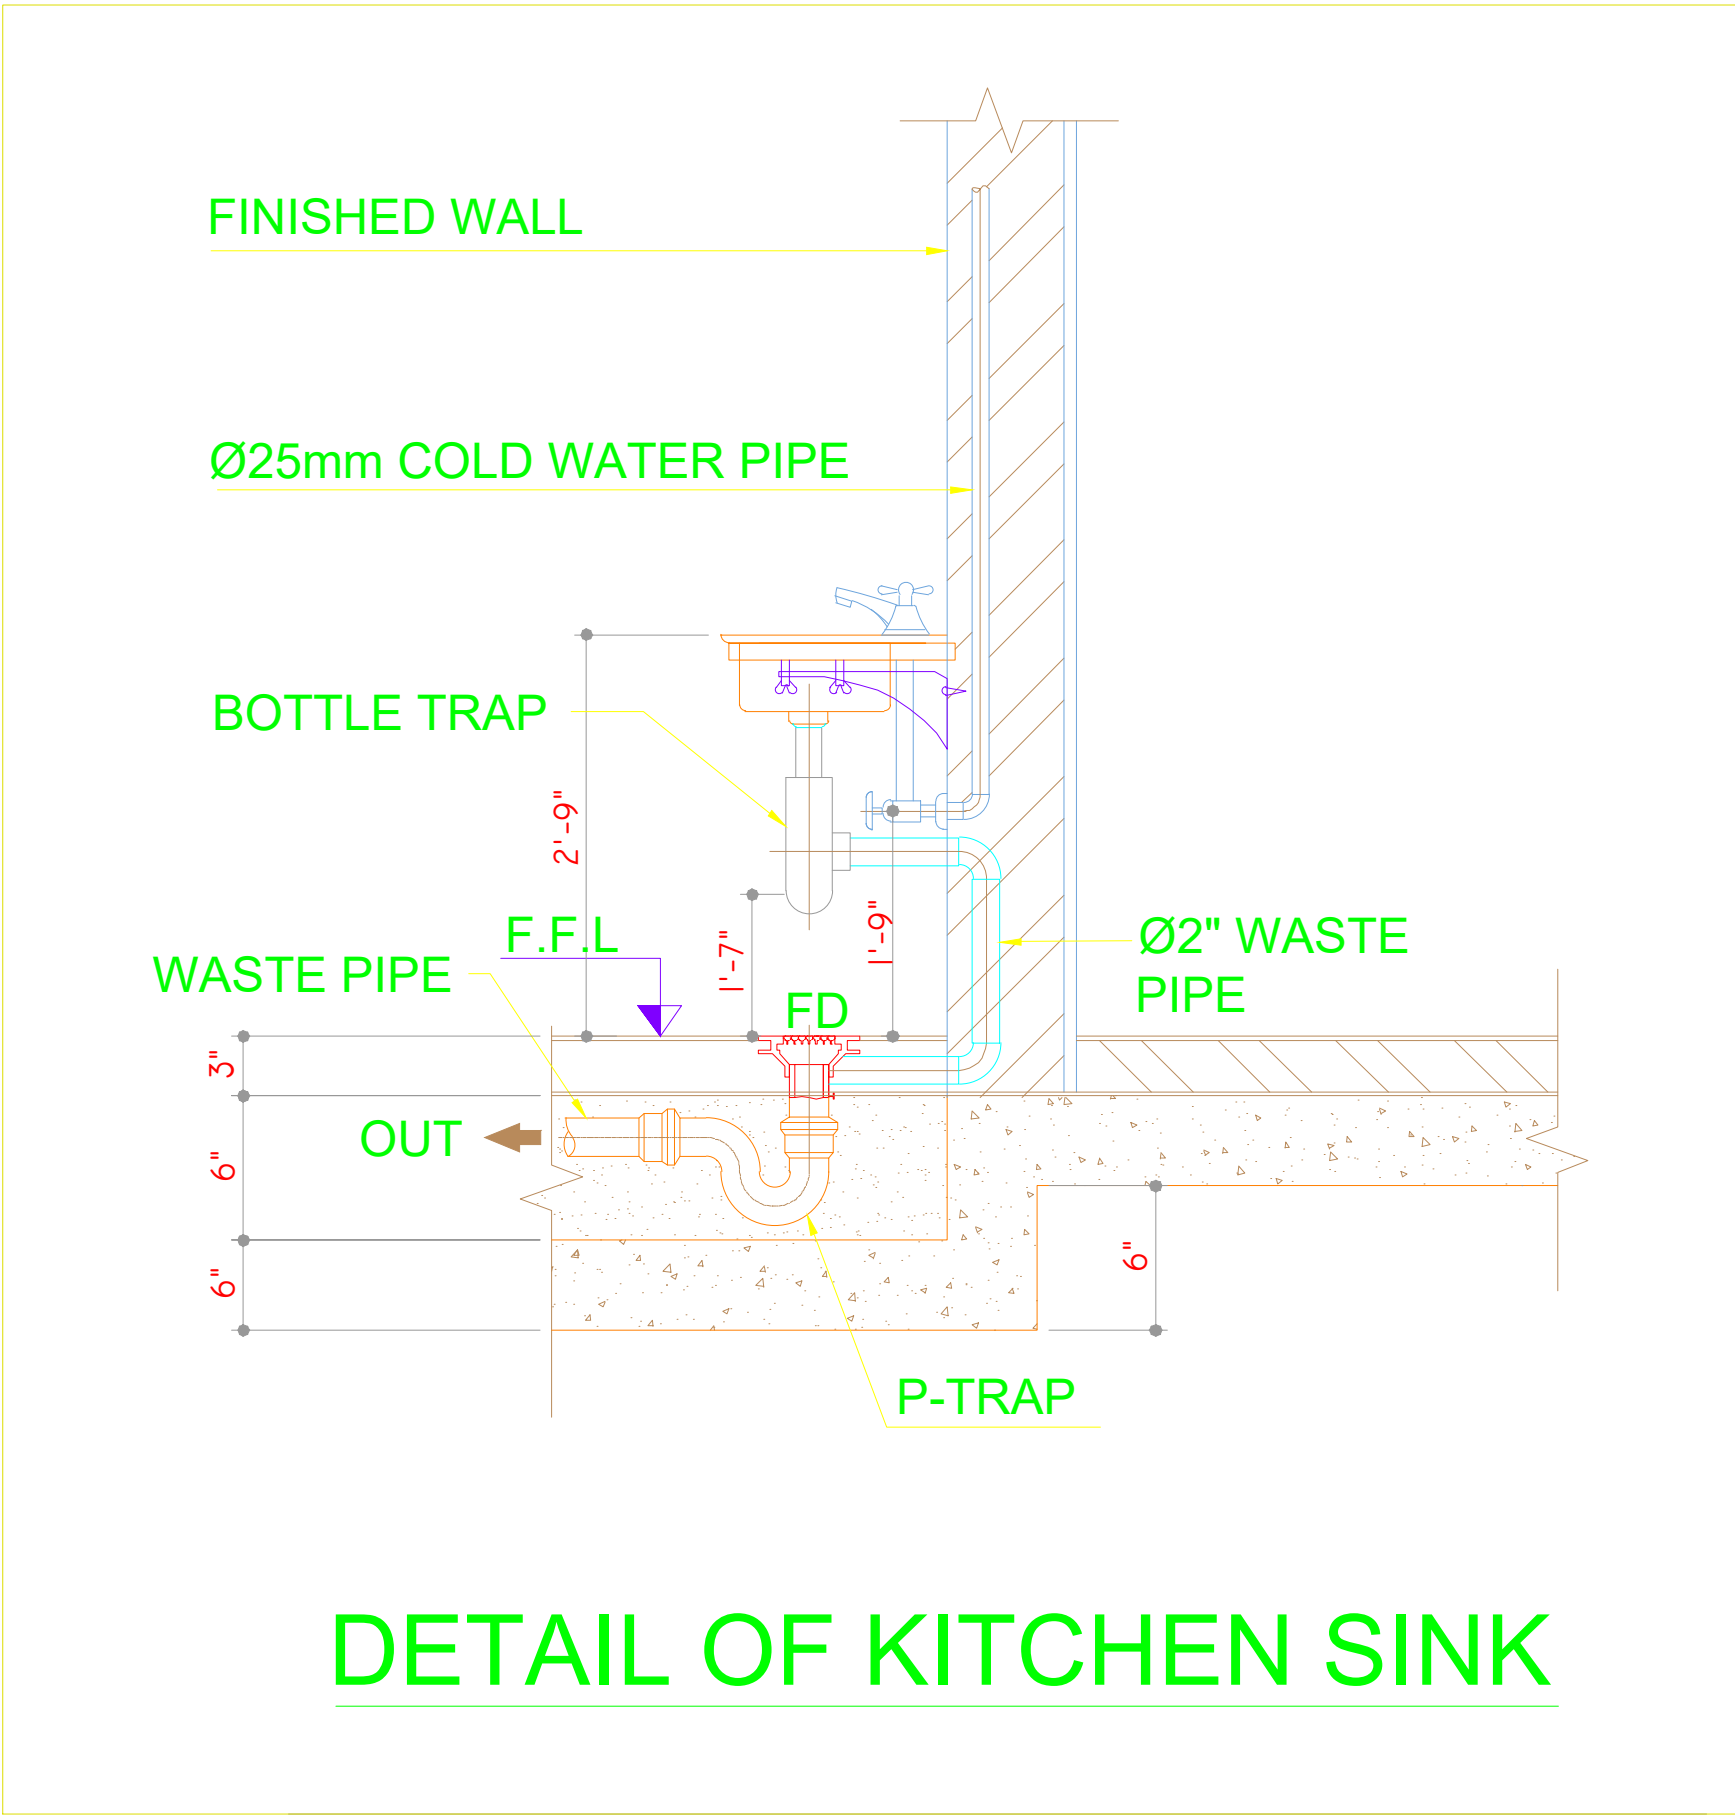

WATER SUPPLY LEGENDS

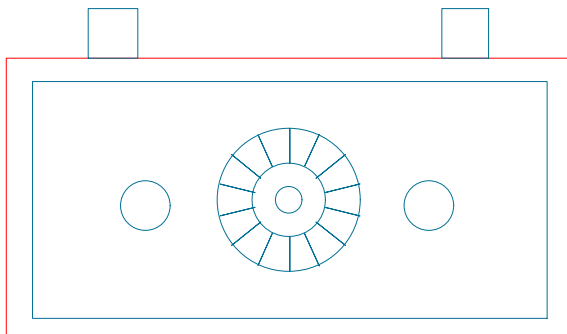
SYMBOL	DESCRIPTION	
	CW	COLD WATER SUPPLY PIPE
	HW	HOT WATER SUPPLY PIPE
		ELETRICAL WATER HEATER


FITTINGS & VALVES

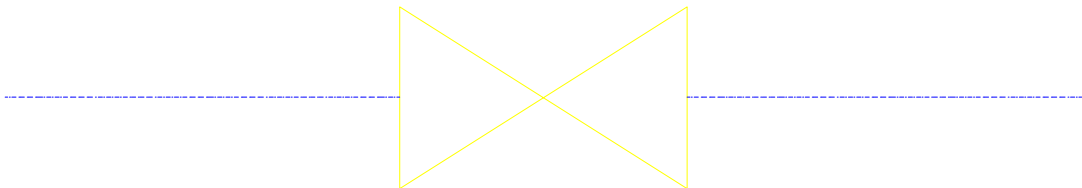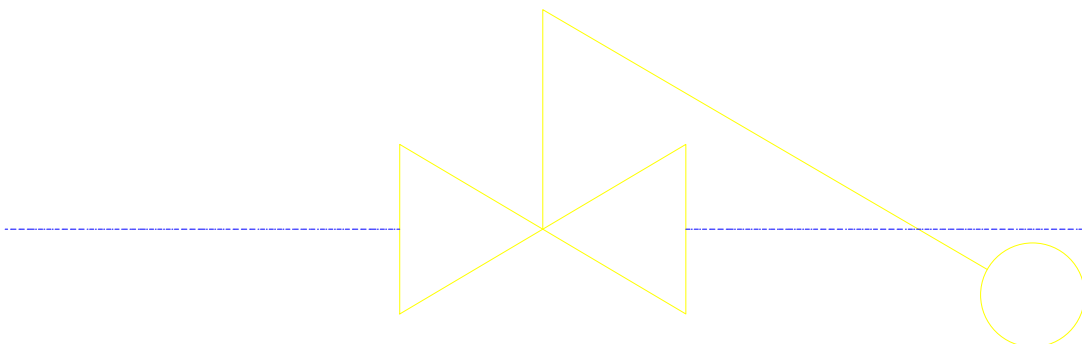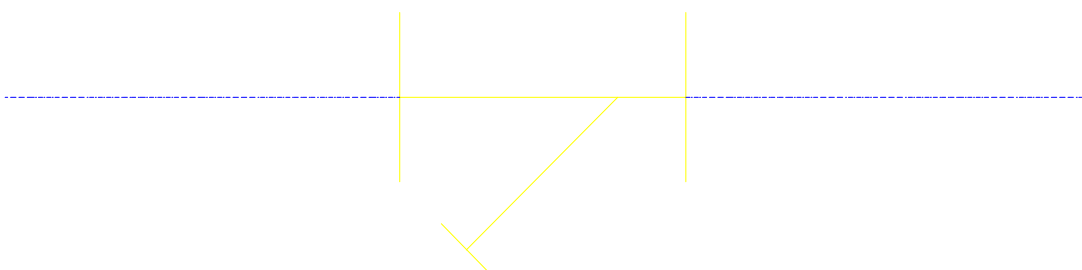	GATE VALVE
	FLOAT VALVE
	STRAINER

SYMBOLDESCRIPTION

MU	MAKE UP PIPE
F/A	FROM ABOVE
F/B	FROM BELOW
T/A	TO ABOVE
T/B	TO BELOW

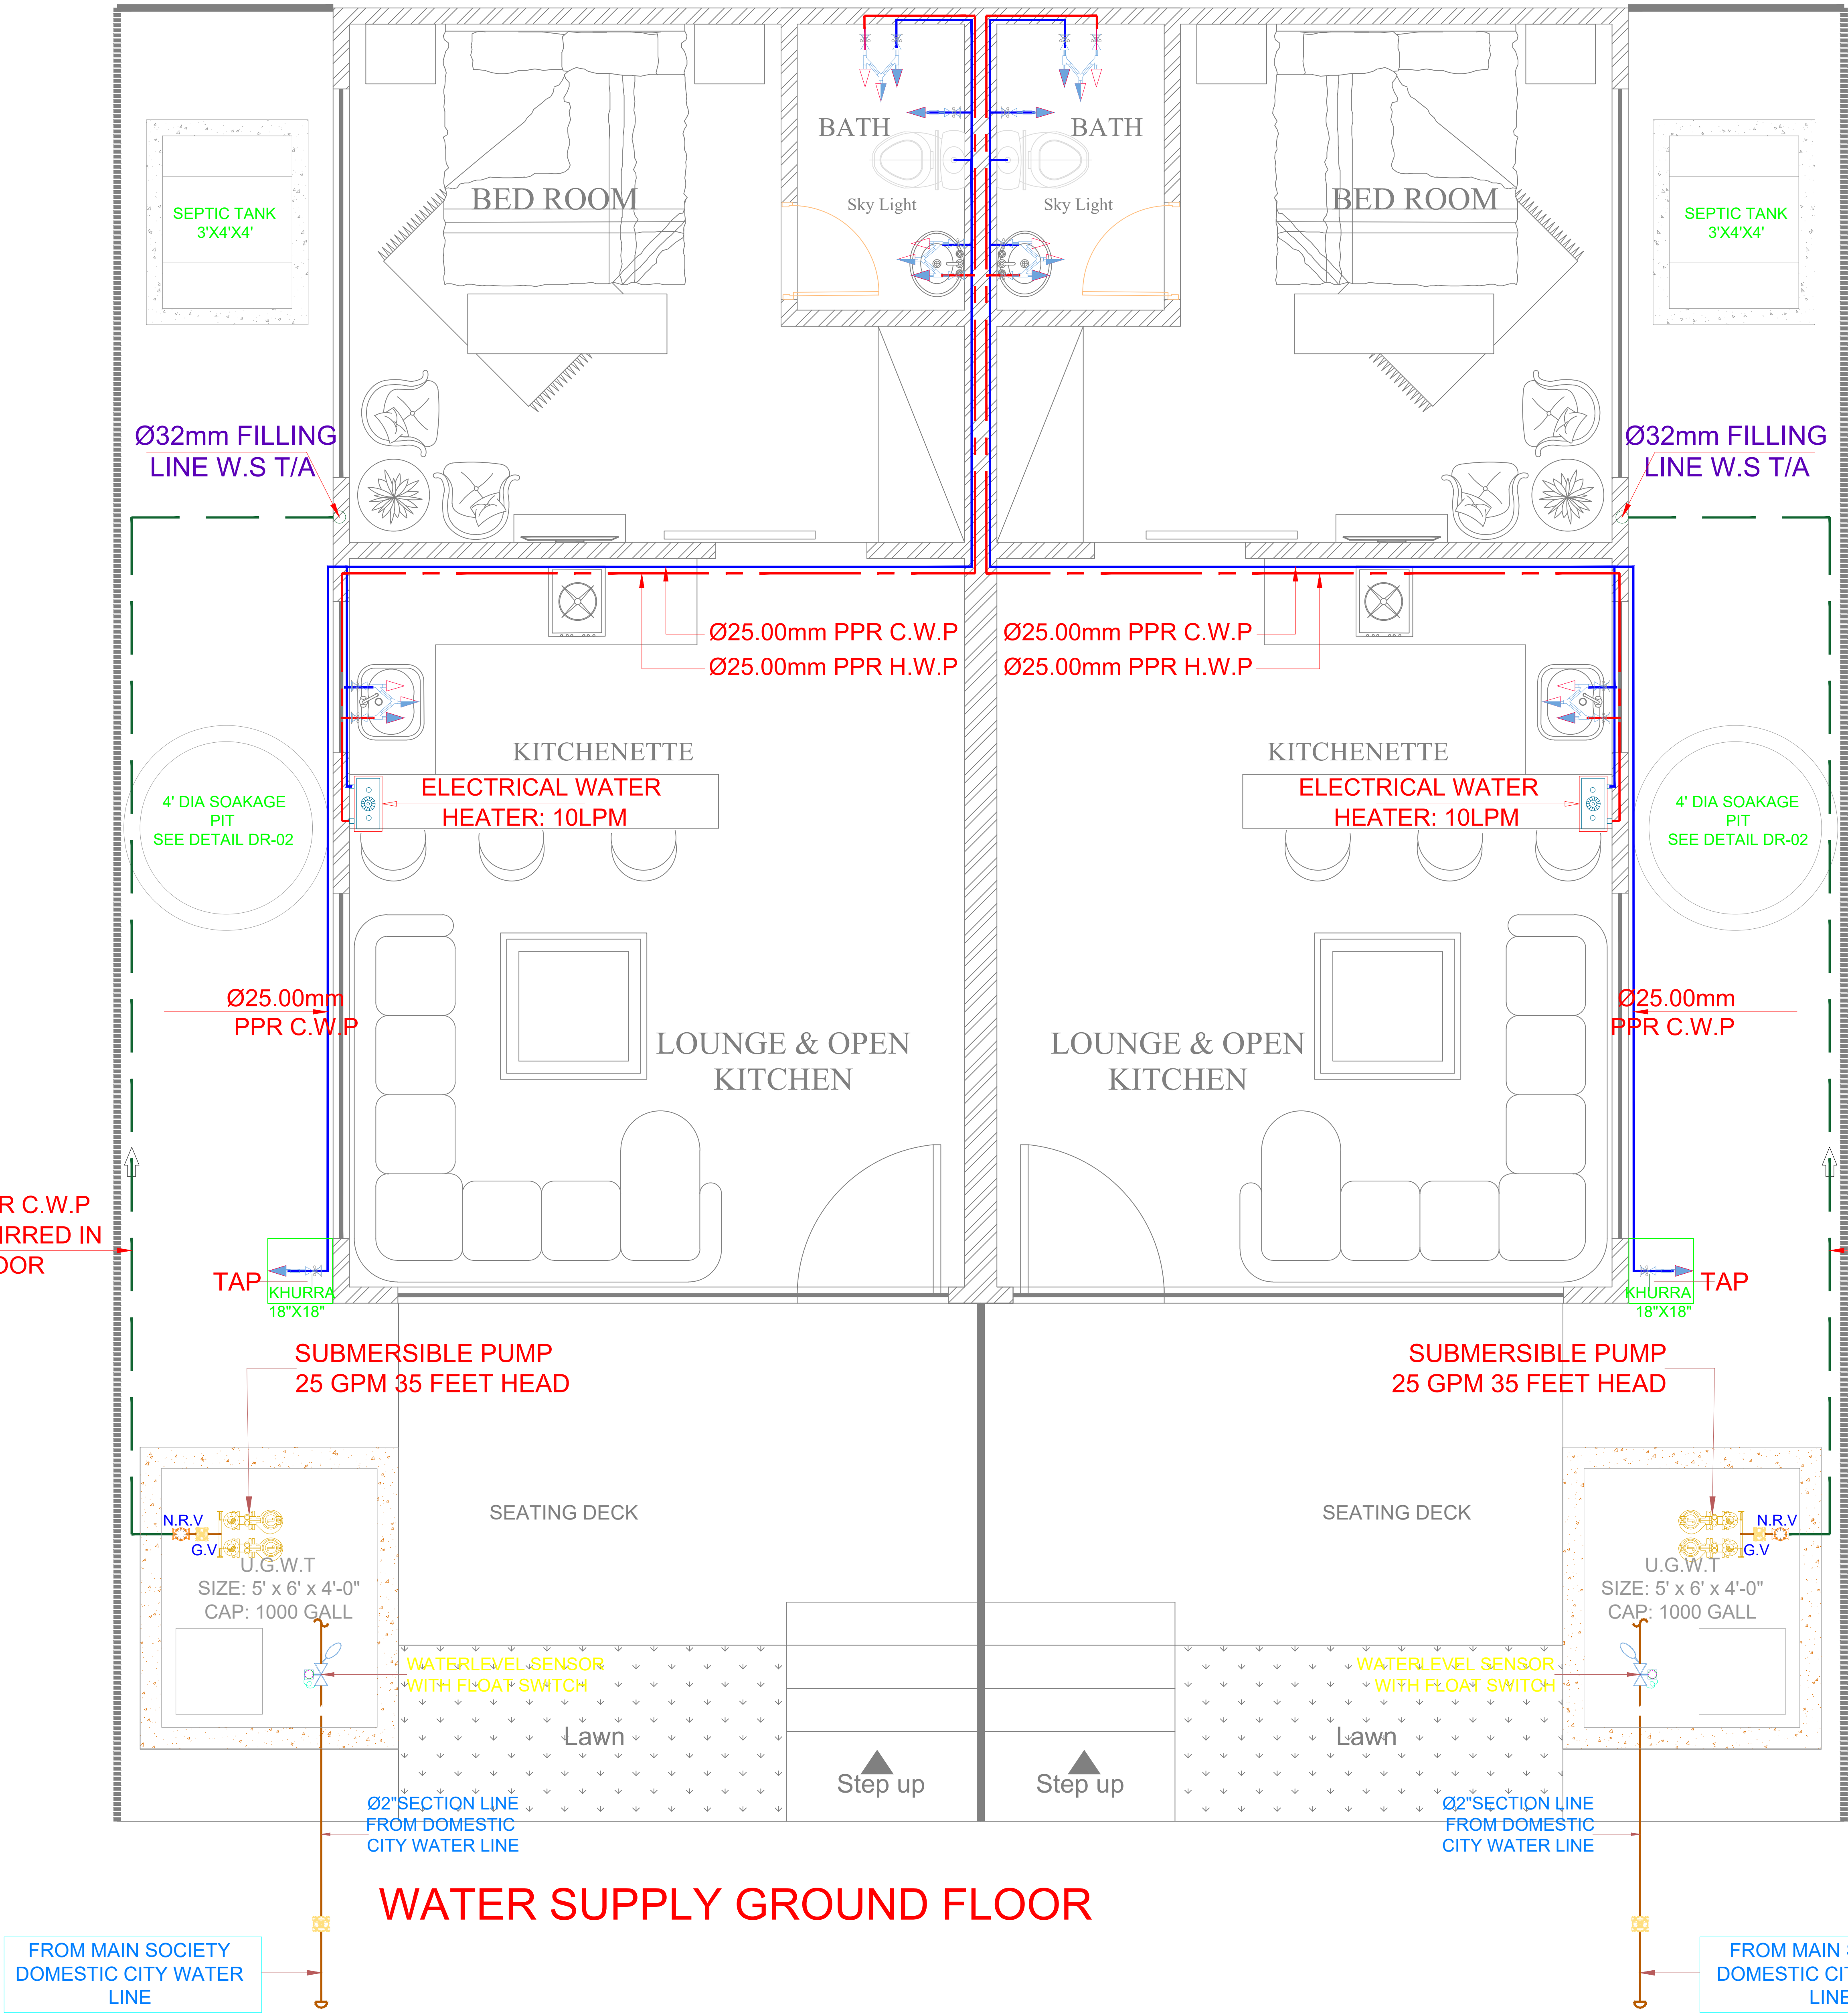

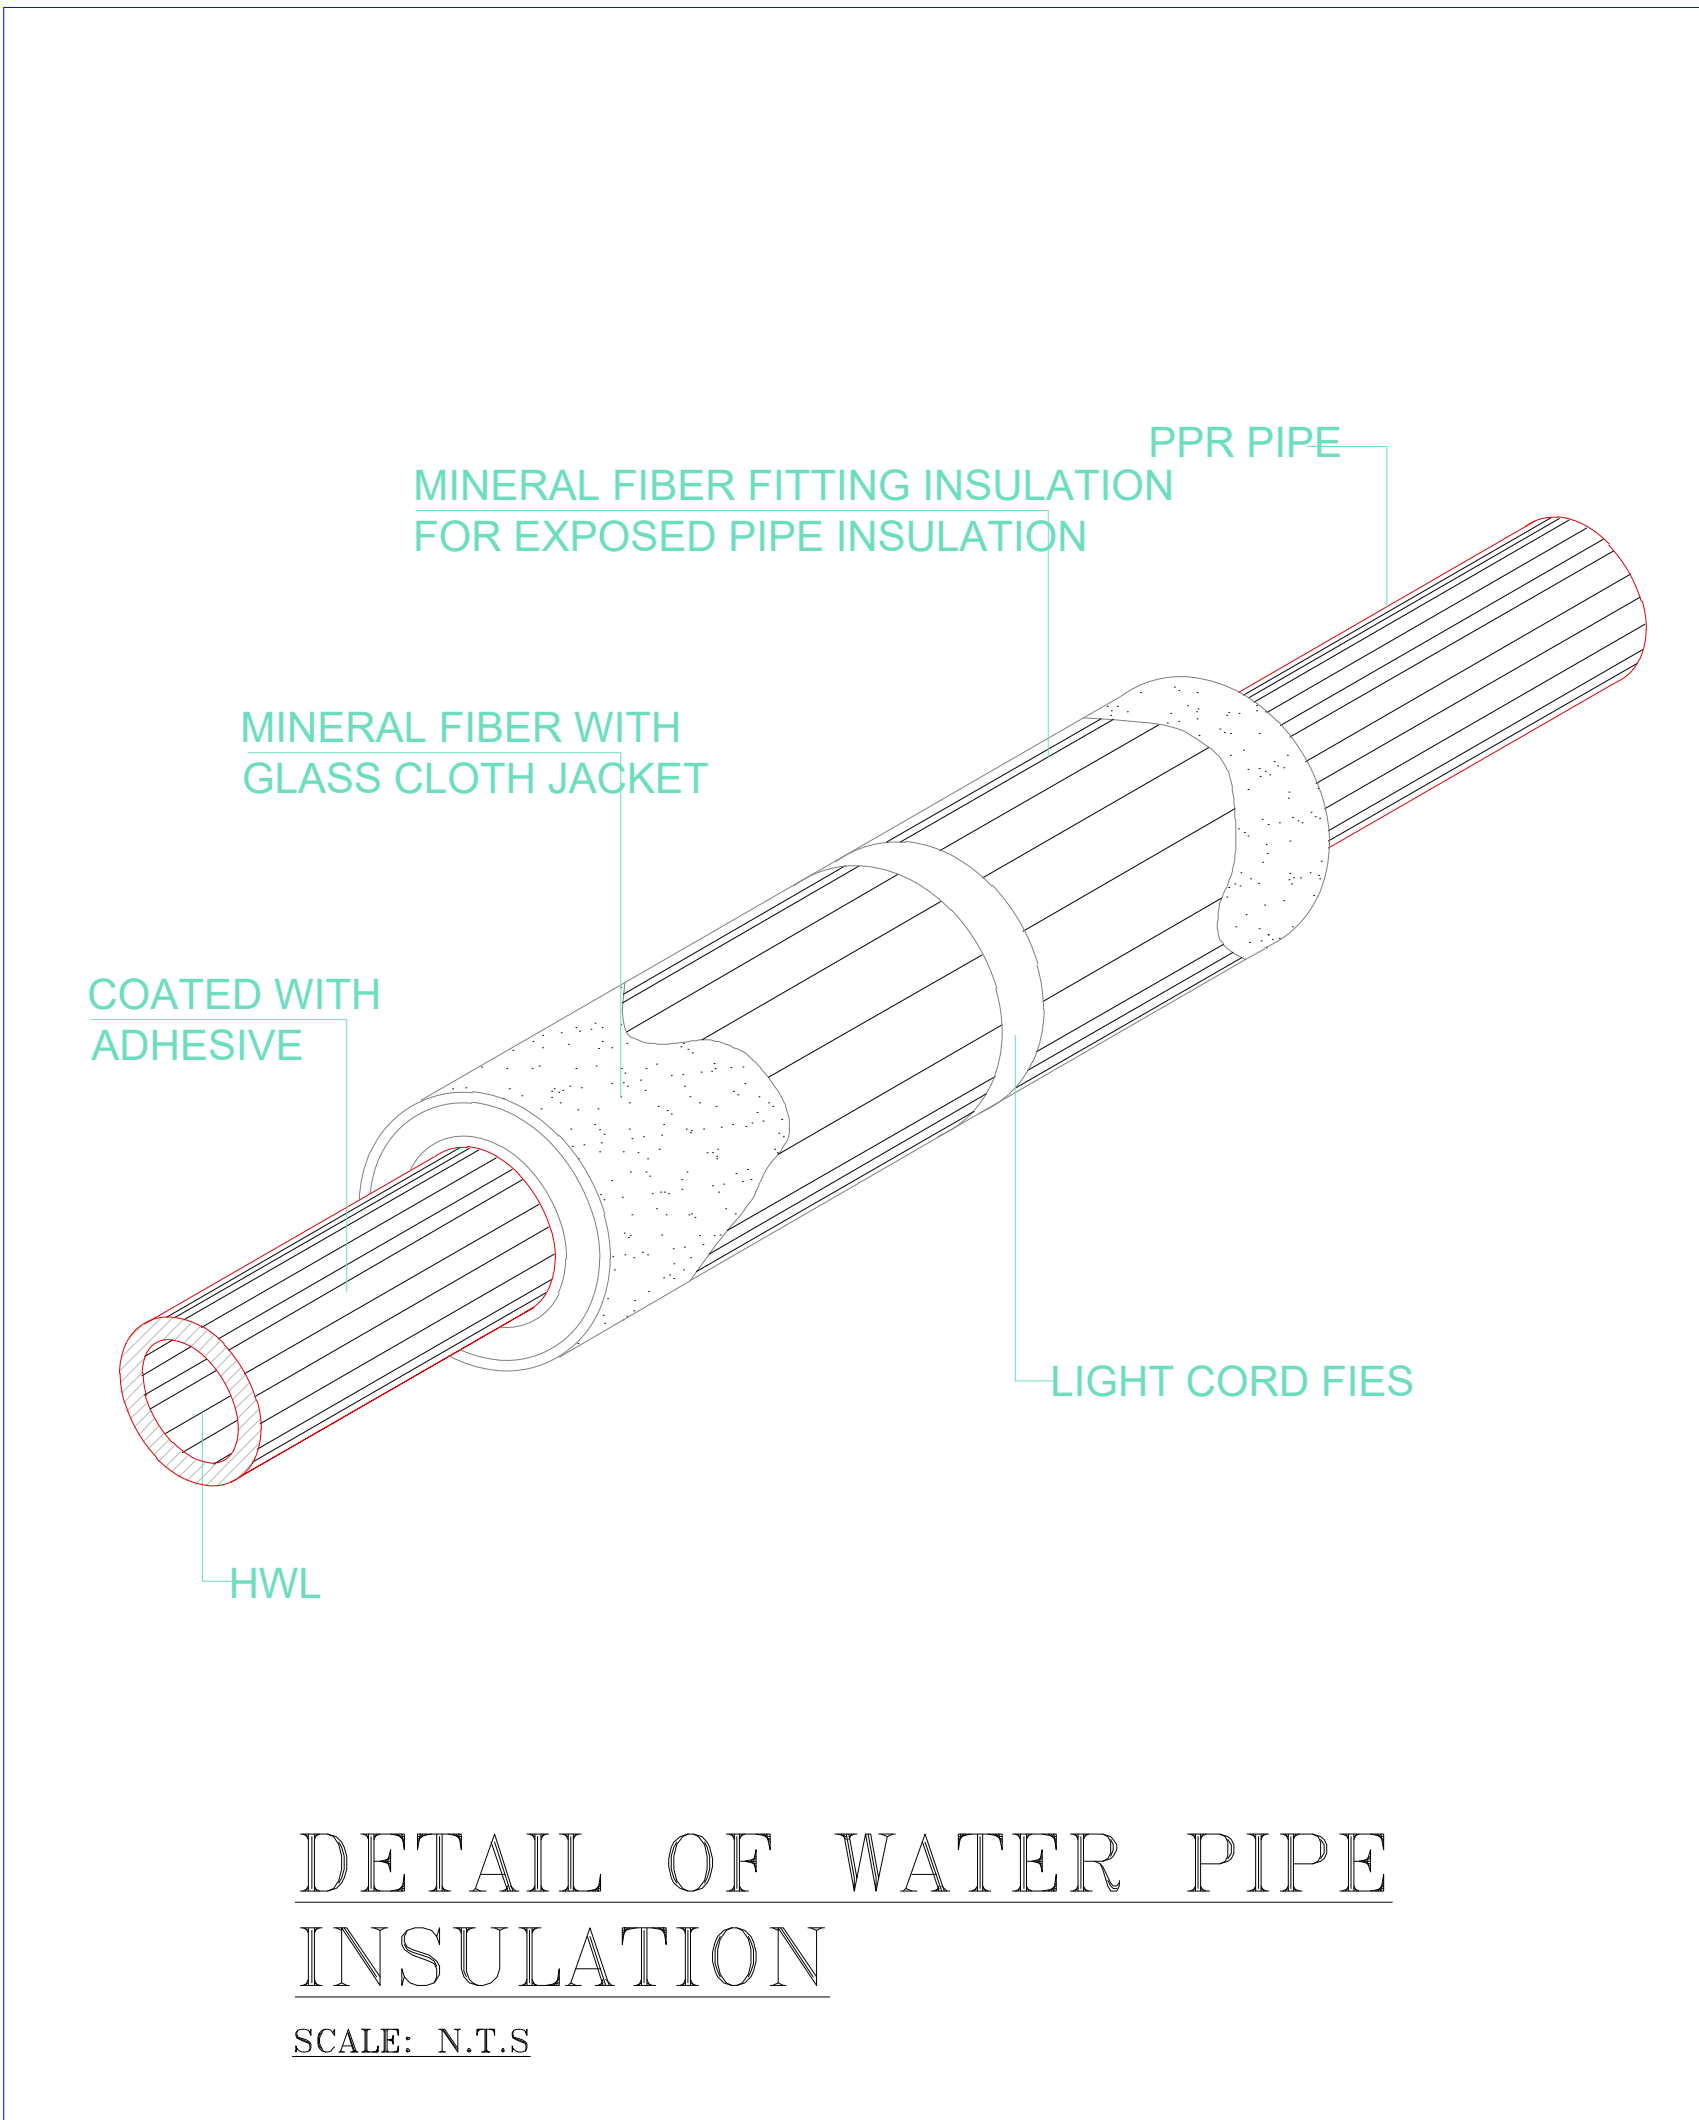


DETAIL OF WATER PIPE INSULATION

SCALE: N.T.S


PIPE HANGER SCHEDULE				
PIPE SIZE mm	MAX. SPACING mm	ROD SIZE mm	RAWL BOLT mm	
20 — 50	200	10	6 x 62	
62 — 75	250	13	10 x 62	
100 — 125	300	16	13 x 62	
125 — 150	350	20	16 x 76	
200 — 300	400	22	16 x 76	

DETAIL OF PIPE HANGER & INSULATION

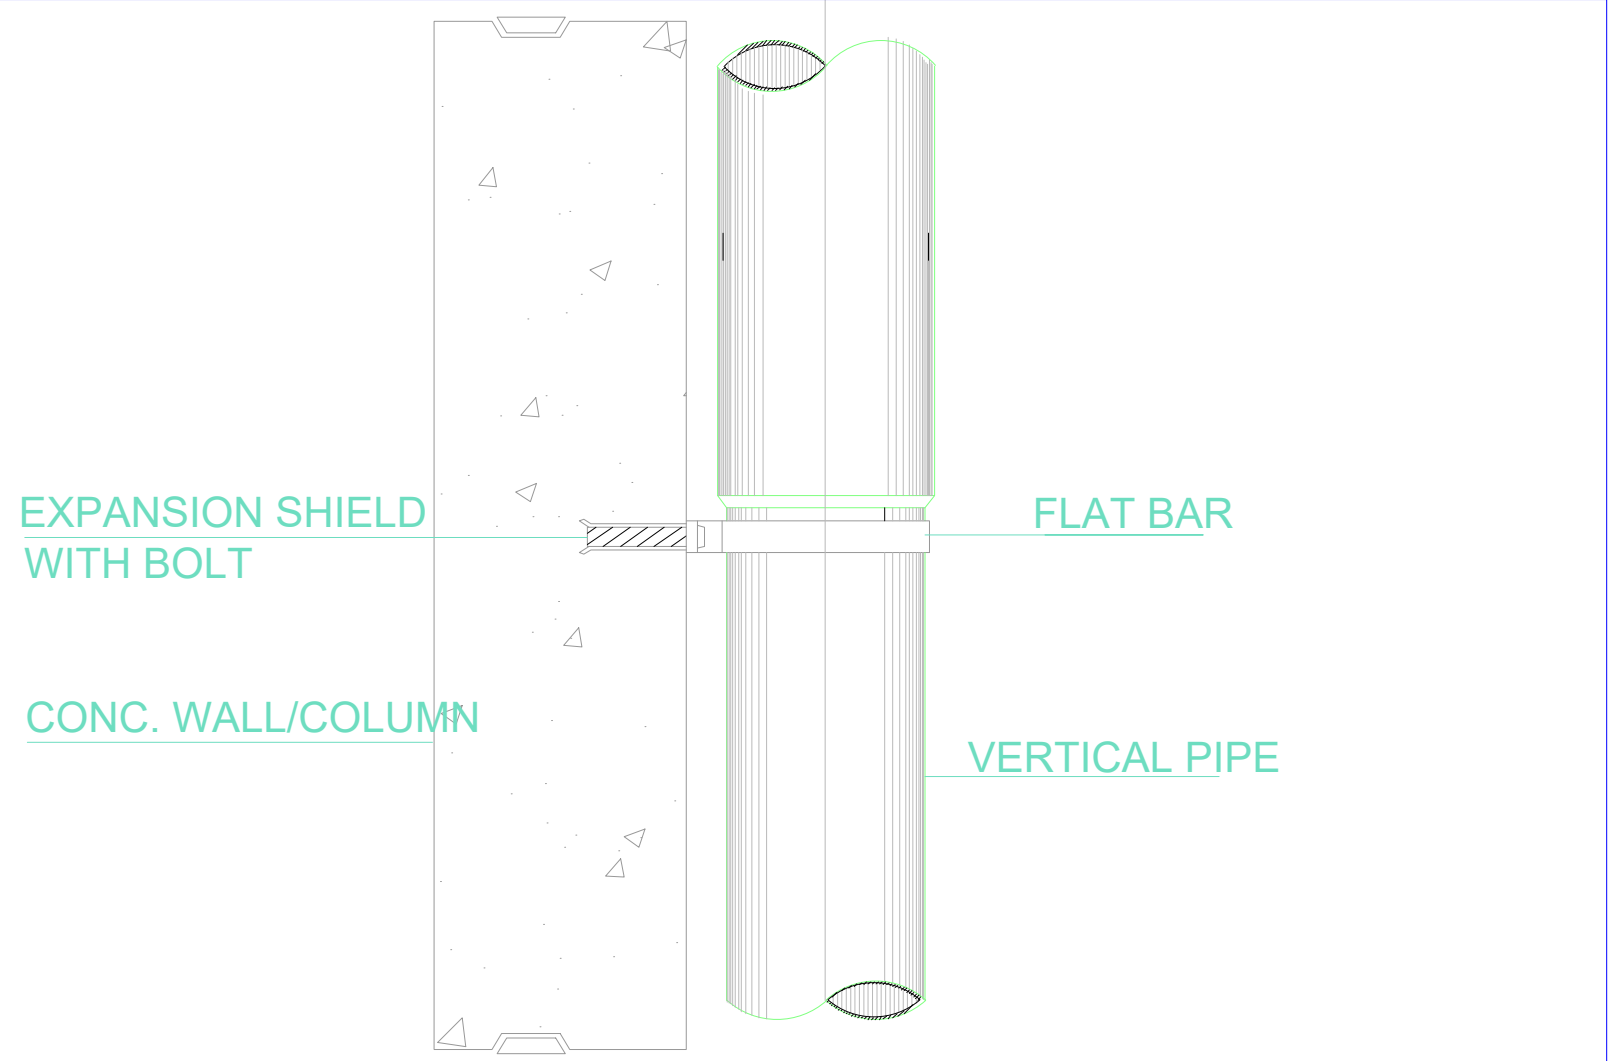


DETAIL OF VERTICAL PIPE HANGER

SCALE: N.T.S

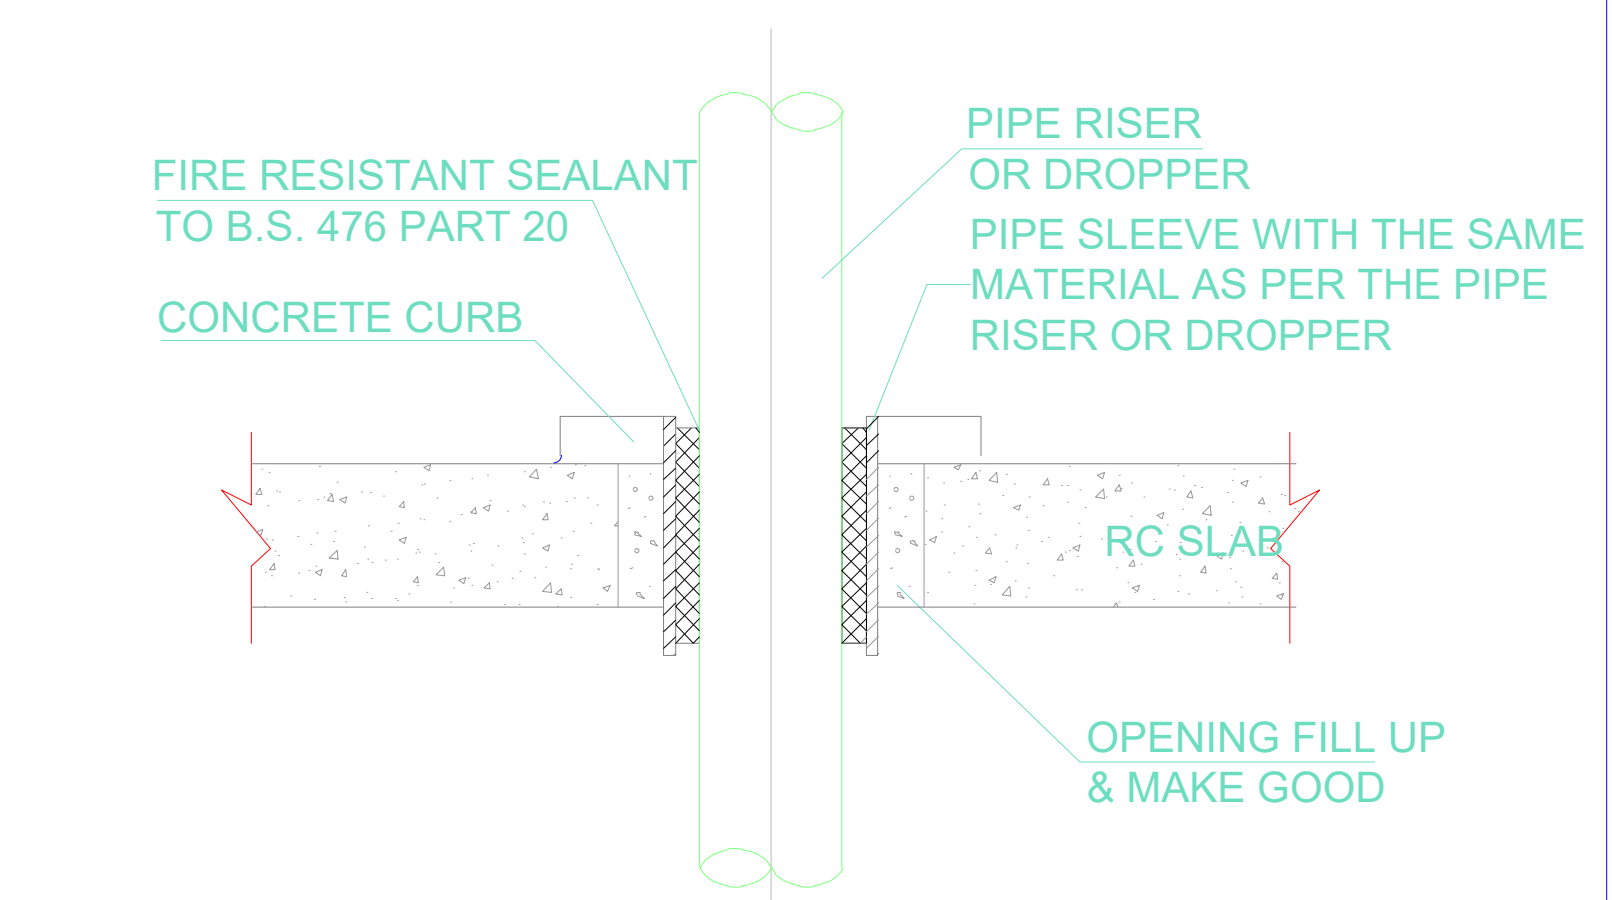


DETAIL OF PIPE SLEEVE FOR PIPES THROUGH SLABS

SCALE: N.T.S

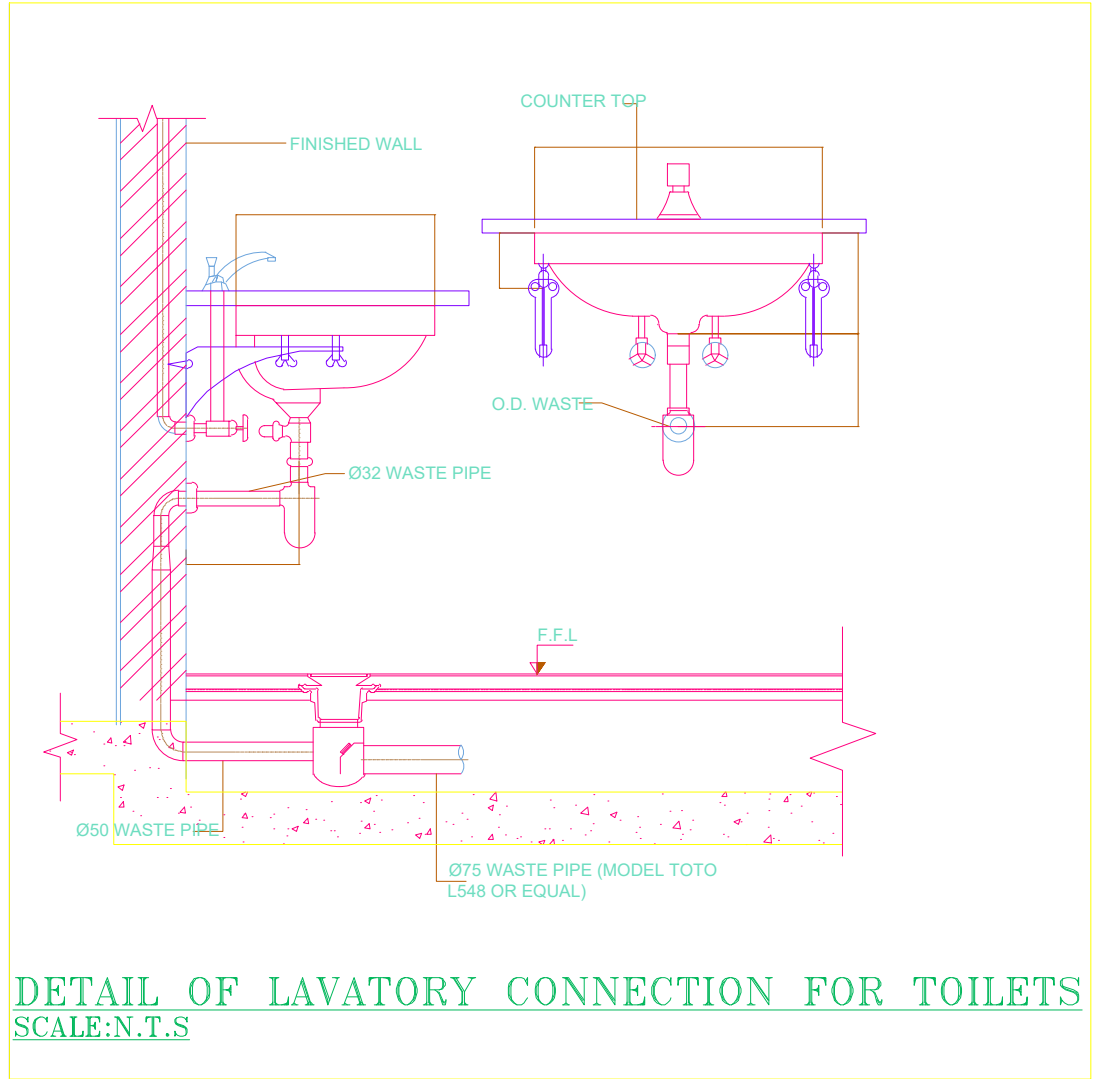


DETAIL OF LAVATORY CONNECTION FOR TOILETS

SCALE: N.T.S

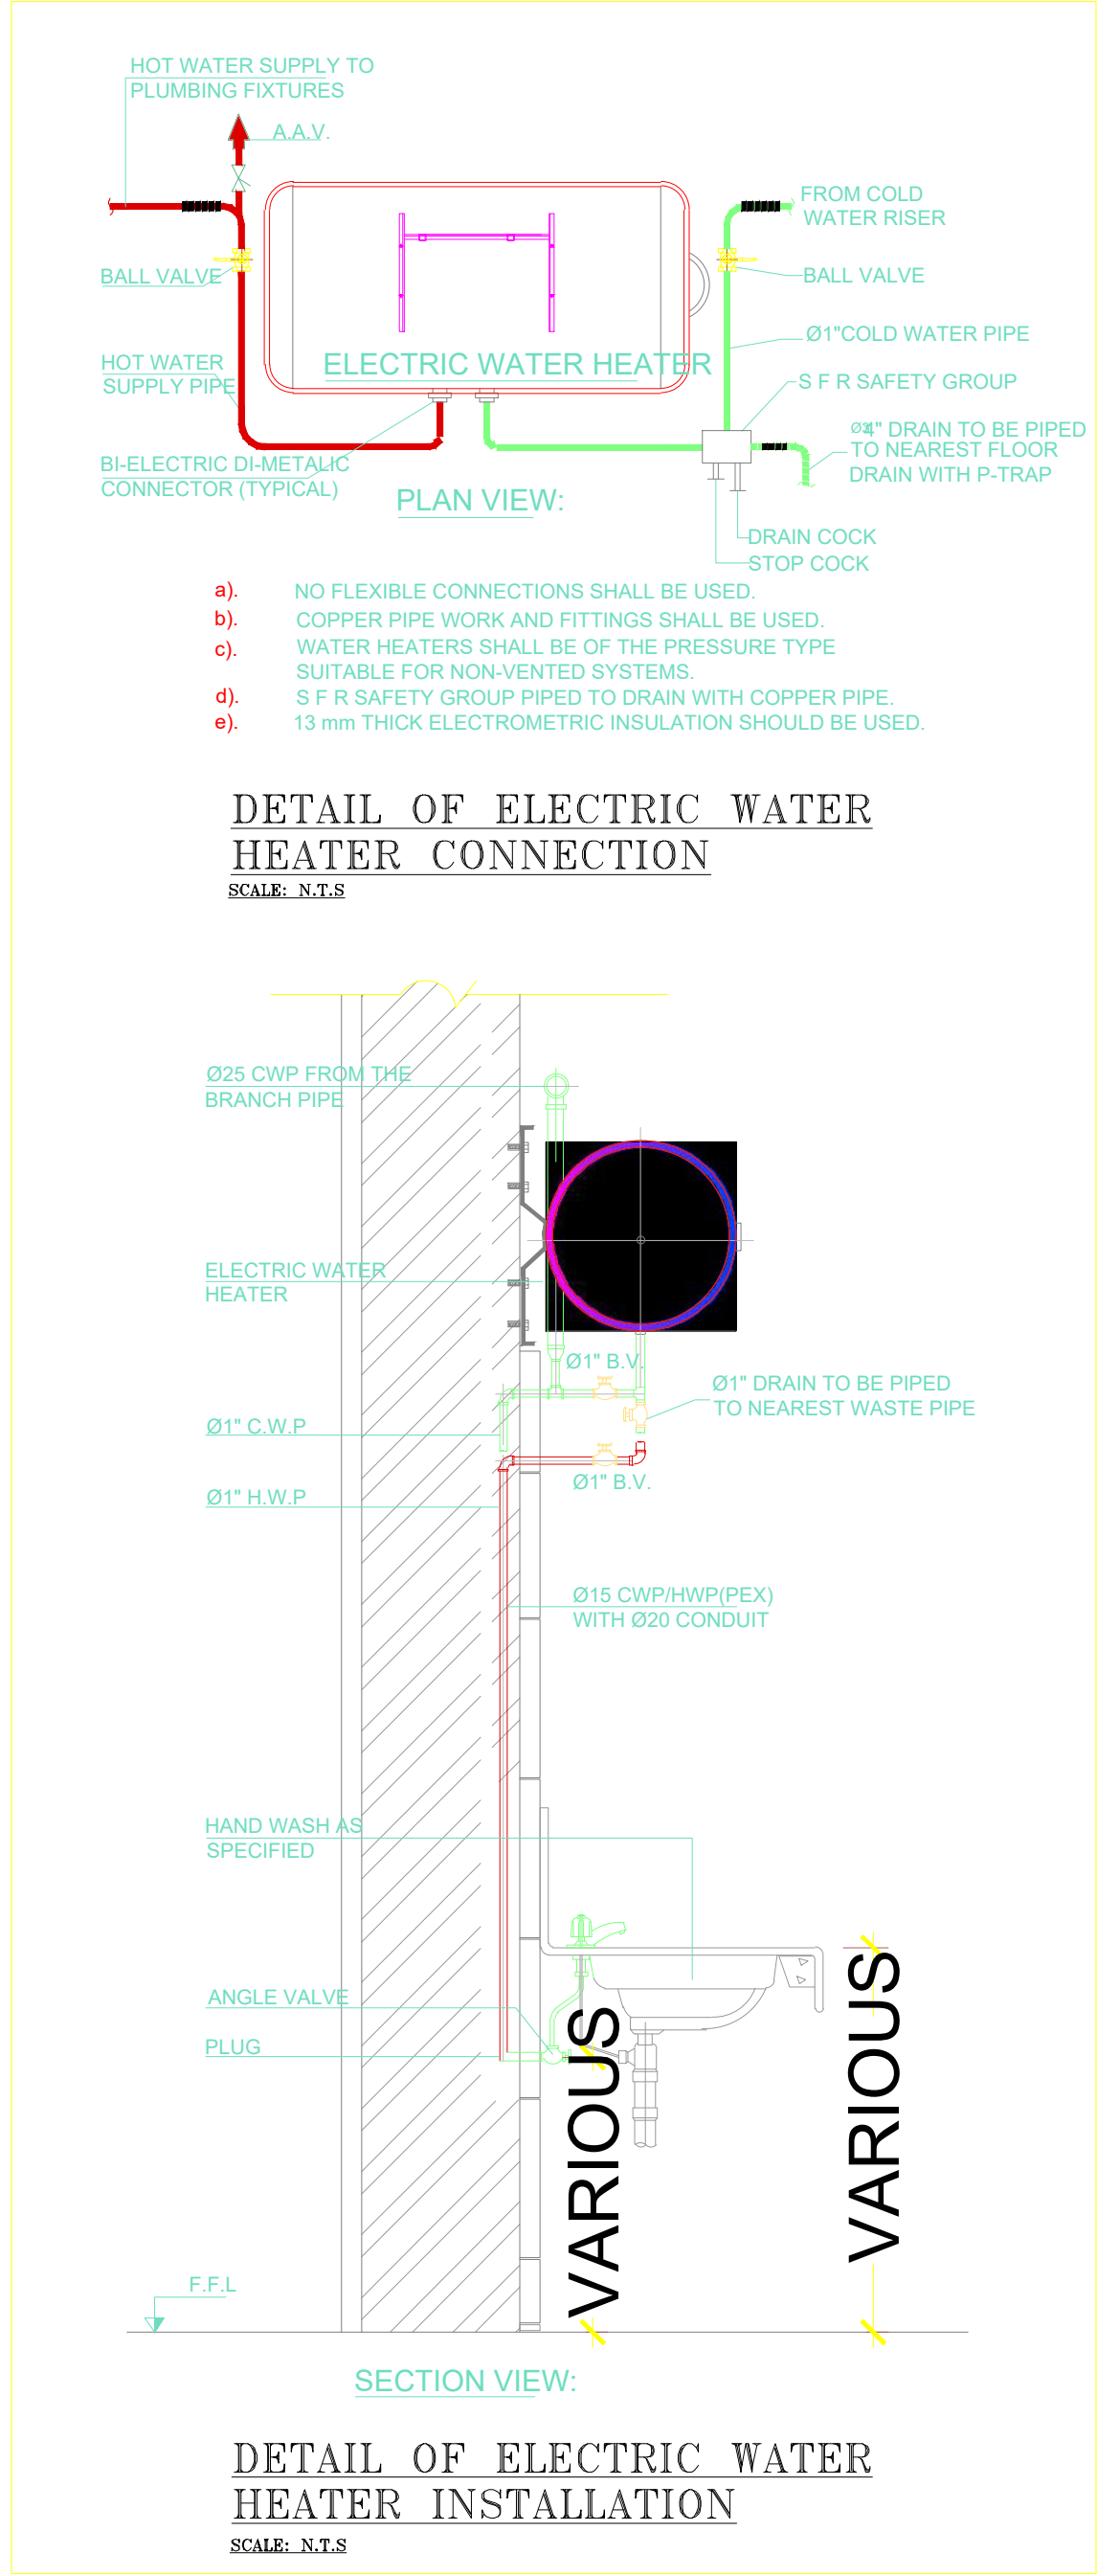

DETAIL OF ELECTRIC WATER HEATER INSTALLATION

SCALE: N.T.S

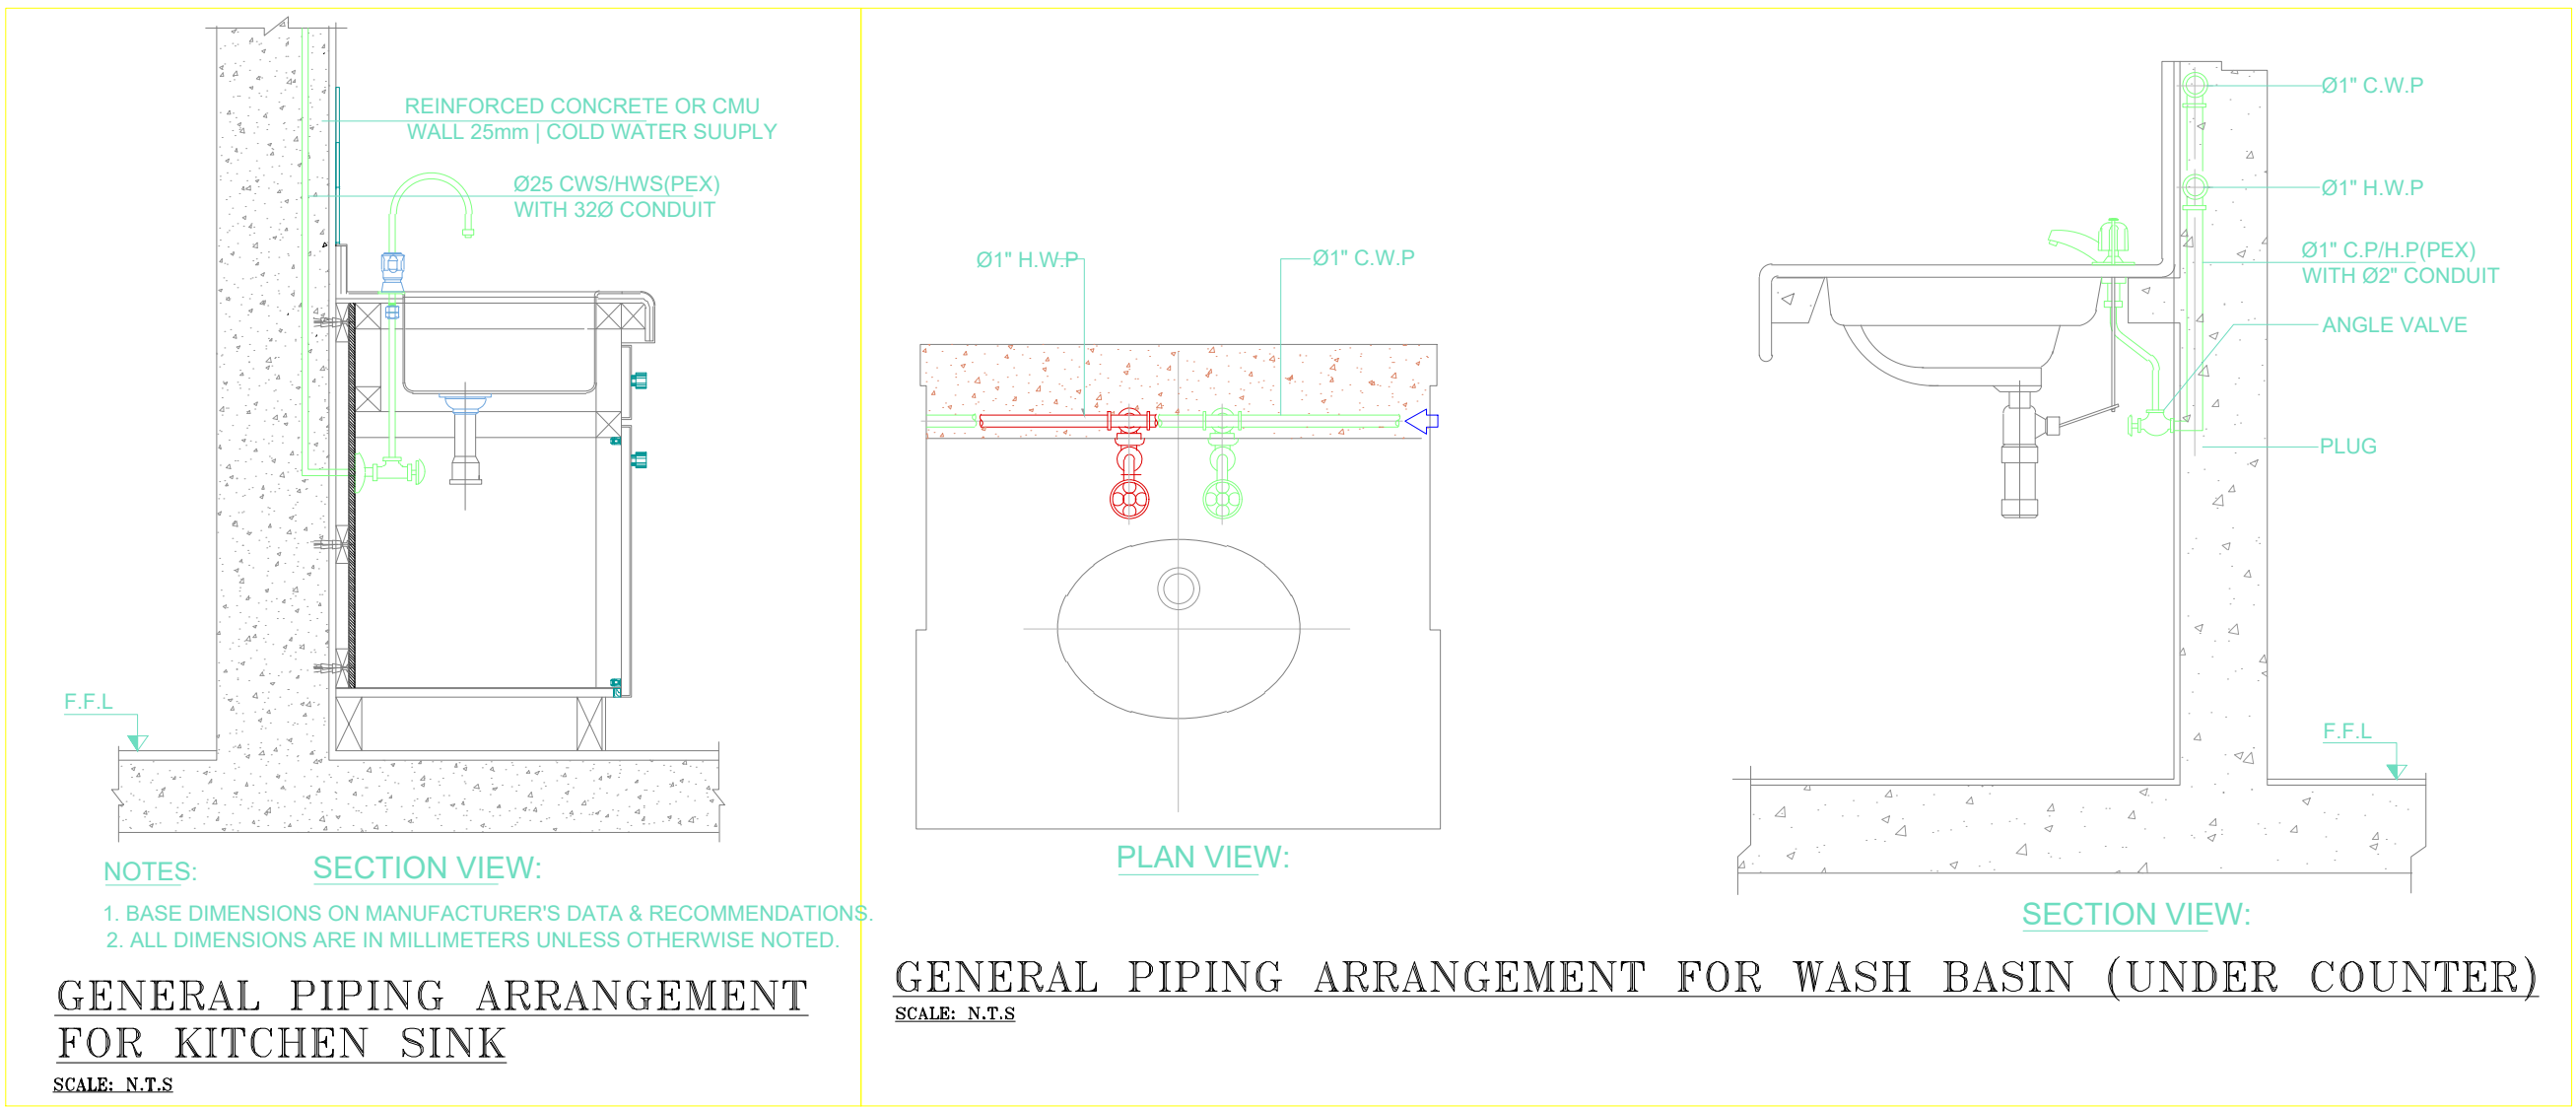


GENERAL PIPING ARRANGEMENT FOR KITCHEN SINK


SCALE: N.T.S

GENERAL PIPING ARRANGEMENT FOR WASH BASIN (UNDER COUNTER)

SCALE: N.T.S

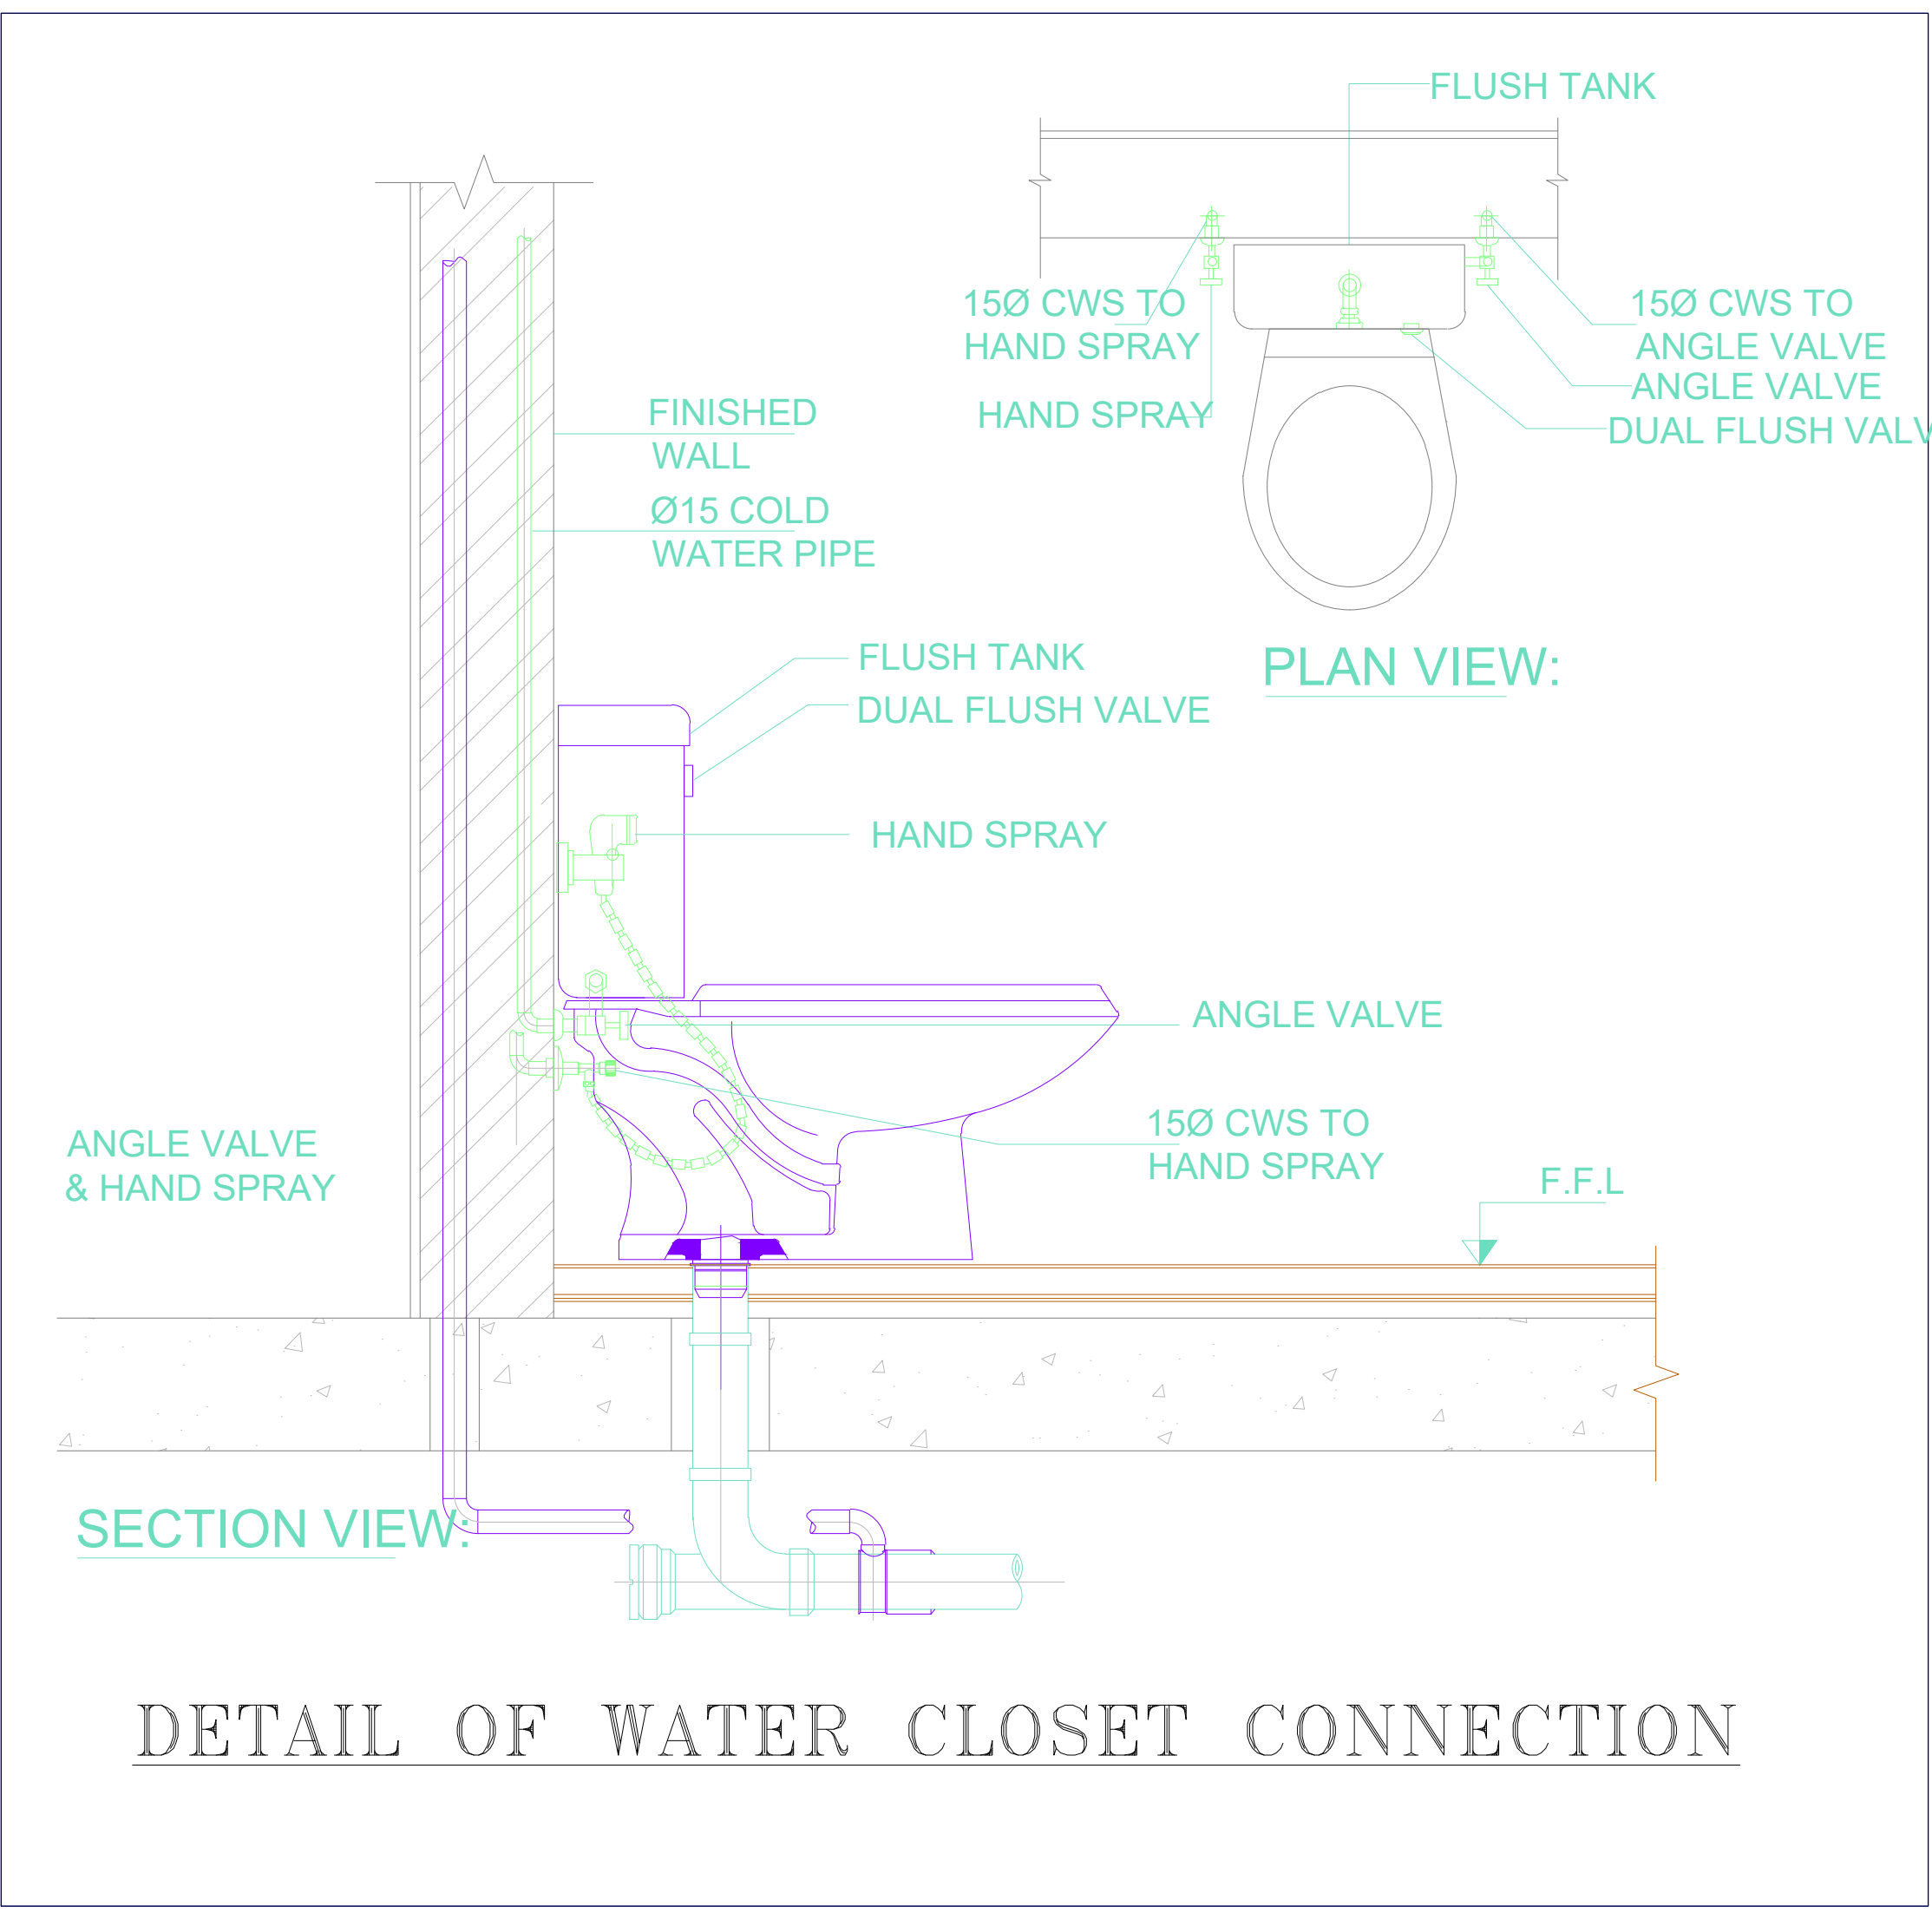

DETAIL OF WATER CLOSET CONNECTION

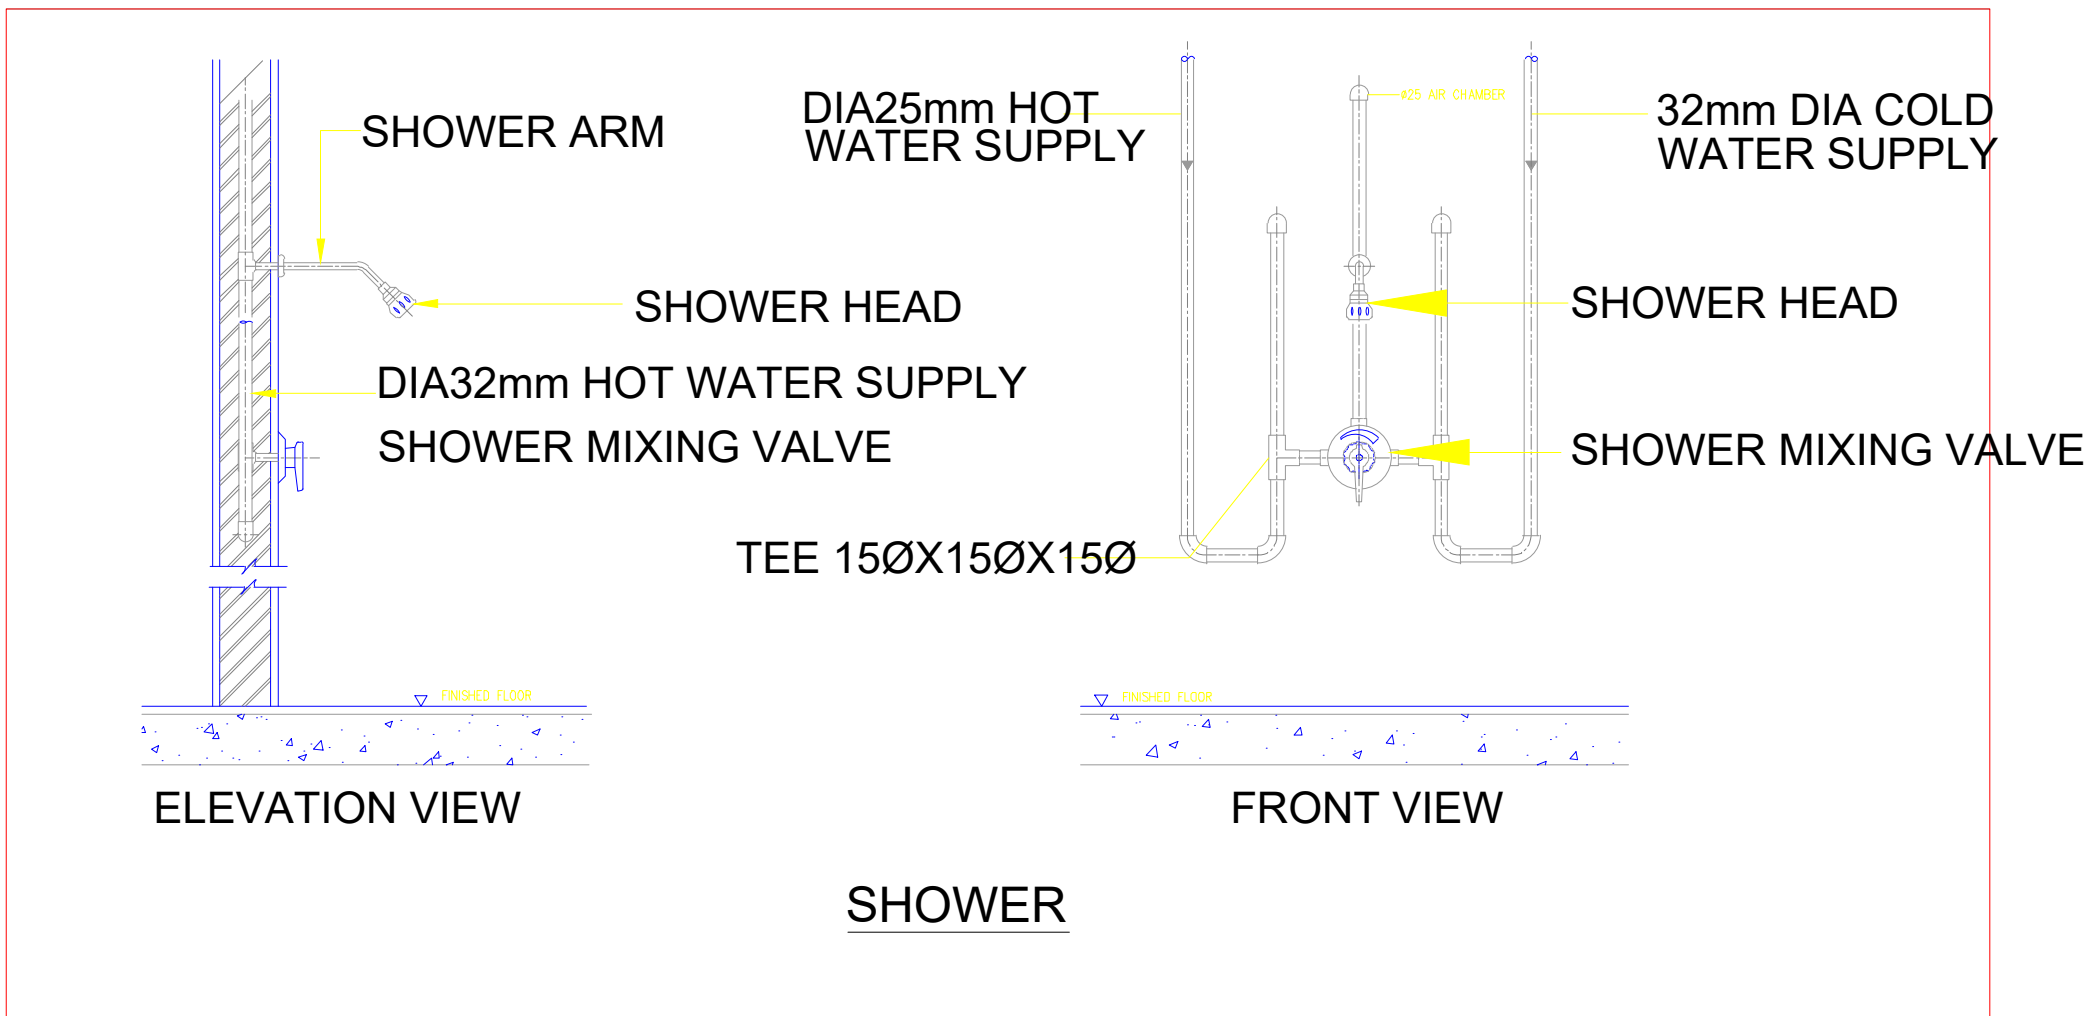

SHOWER



PROPOSAL DRAWINGS

WATER SUPPLY DETAIL
FOR STRUCTURE

PAGE NO.

11

DRAWING NO.

PL-10

DESIGN BY:

Aqib ali

CLIENT:

PROJECT :

MURREE COTTAGE HOUSE

DRAWN BY:

Eshan

DATE:

20.08.2024

MURREE COTTAGE HOUSE (01 BED)

INTERIOR LAYOUT DRAWINGS



LIST OF INTERIOR LAYOUT WORKING DRAWINGS


PAGE NO	DRAWING NO	DRAWING TITLE
01	INT-00	COVER SHEET
02	INT-01	FURNITURE LAYOUT PLAN (BED -01)
03	INT-02	FIRST 3D VIEW (BED -01)
04	INT-03	SECOND 3D VIEW (BED -01)
05	INT-04	WALL A / C (BED -01)
06	INT-05	WALL B / D (BED -01)
07	INT-06	FUNITURE LAYOUT & FLOOR PLAN (BED -01)
08	INT-07	FURNITURE LAYOUT PLAN (TV LOUNGE & OPEN KITCHEN)
09	INT-08	FIRST 3D VIEW (TV LOUNGE & OPEN KITCHEN)
10	INT-09	SECOND 3D VIEW (TV LOUNGE & OPEN KITCHEN)
11	INT-10	THIRD 3D VIEW (TV LOUNGE & OPEN KITCHEN)
12	INT-11	FOURTH 3D VIEW (TV LOUNGE & OPEN KITCHEN)
13	INT-12	WALL A / C (TV LOUNGE & OPEN KITCHEN)
14	INT-13	WALL B / D (TV LOUNGE & OPEN KITCHEN)
15	INT-14	FUNITURE LAYOUT & FLOOR PLAN (TV LOUNGE & OPEN KITCHEN)



PROPOSAL DRAWINGS

LIST OF INTERIOR LAYOUT
WORKING DRAWING

PAGE NO.	02	DRAWING NO.	INT-00	DESIGN BY:	Aqib ali
CLIENT:	_____	PROJECT :	MURREE COTTAGE HOUSE	DRAWN BY:	Eshan
				DATE:	23.08.2024

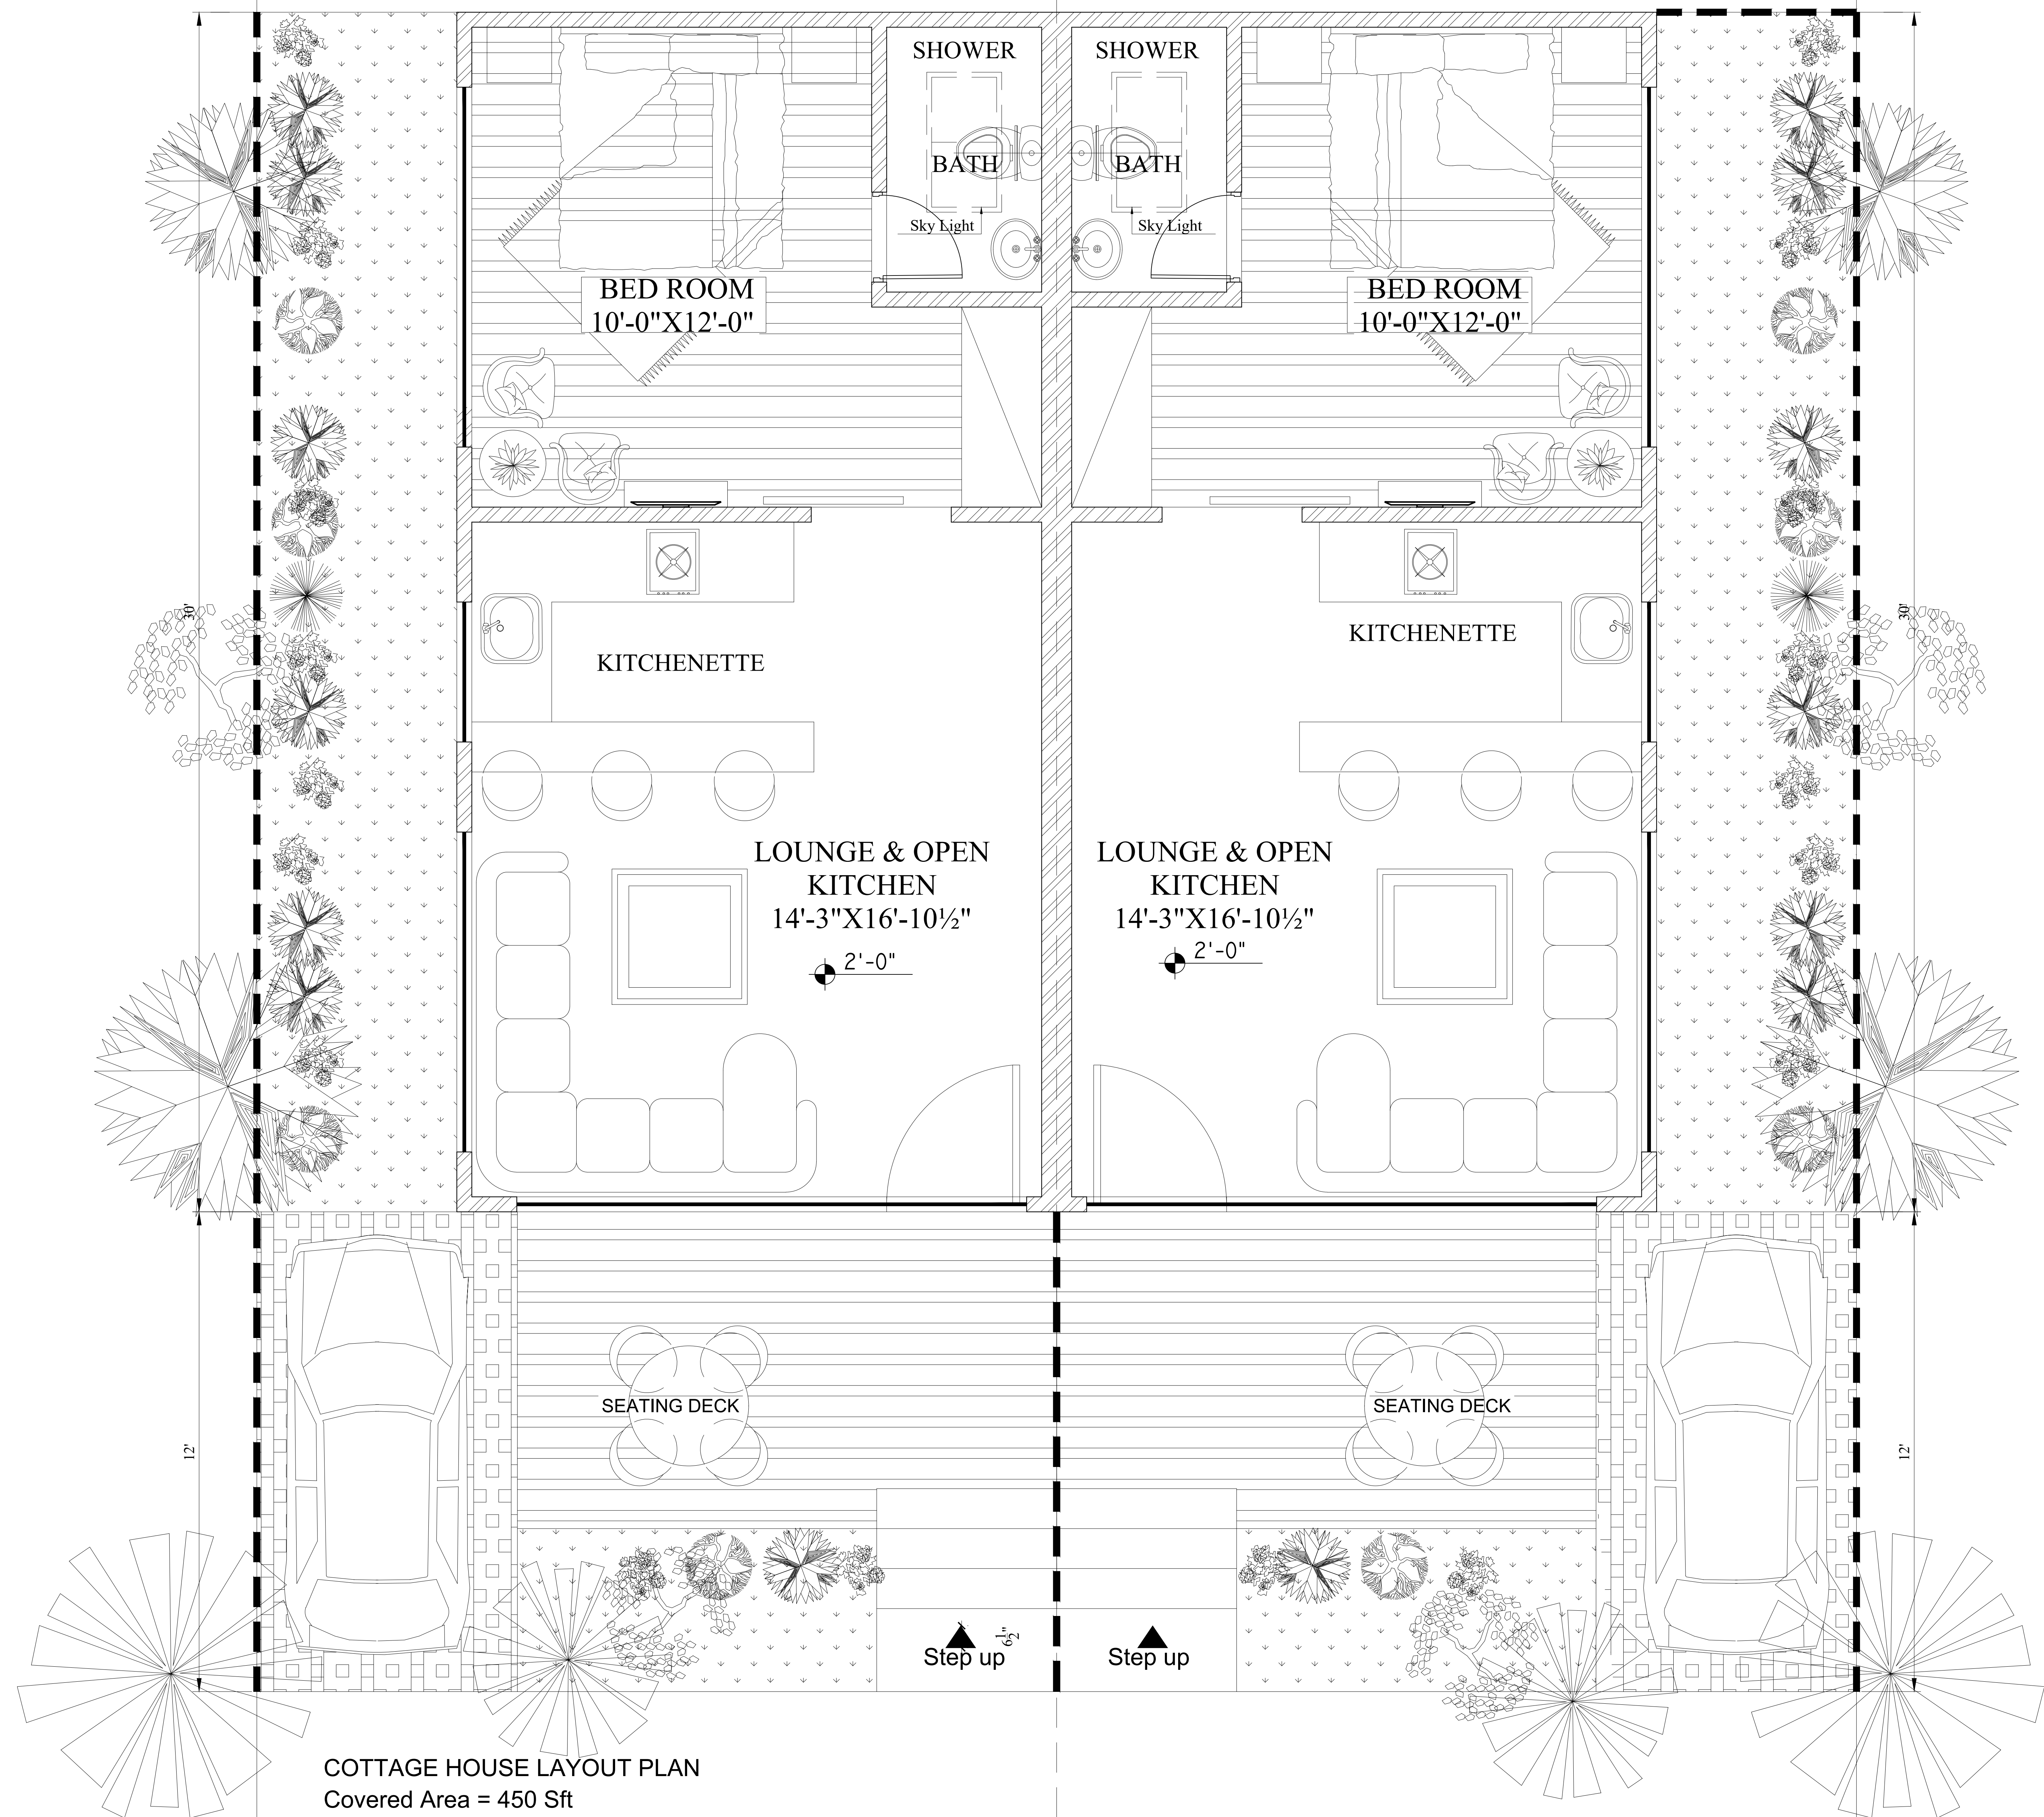

COTTAGE HOUSE LAYOUT PLAN
Covered Area = 450 Sft
Total plot Area = 840 Sft
Plot no # 26



PROPOSAL DRAWINGS

BED -01
FURNITURE LAYOUT PLAN

PAGE NO.	03	DRAWING NO.	INT-01	DESIGN BY:	Aqib ali
CLIENT:	-----	PROJECT :	MURREE COTTAGE HOUSE	DRAWN BY:	Eshan
				DATE:	23.08.2024



PROPOSAL DRAWINGS

BED -01
FIRST 3D VIEW

PAGE NO.

04

CLIENT:

.....

DRAWING NO.

INT-02

PROJECT :

MURREE COTTAGE HOUSE

DESIGN BY:

Aqib ali

DRAWN BY:

Eshan

DATE:

23.08.2024



PROPOSAL DRAWINGS

BED -01
FIRST 3D VIEW

PAGE NO. 05

CLIENT:


DRAWING NO. INT-03



PROJECT : MURREE COTTAGE HOUSE



DESIGN BY: Aqib ali

DRAWN BY: Eshan

DATE: 23.08.2024

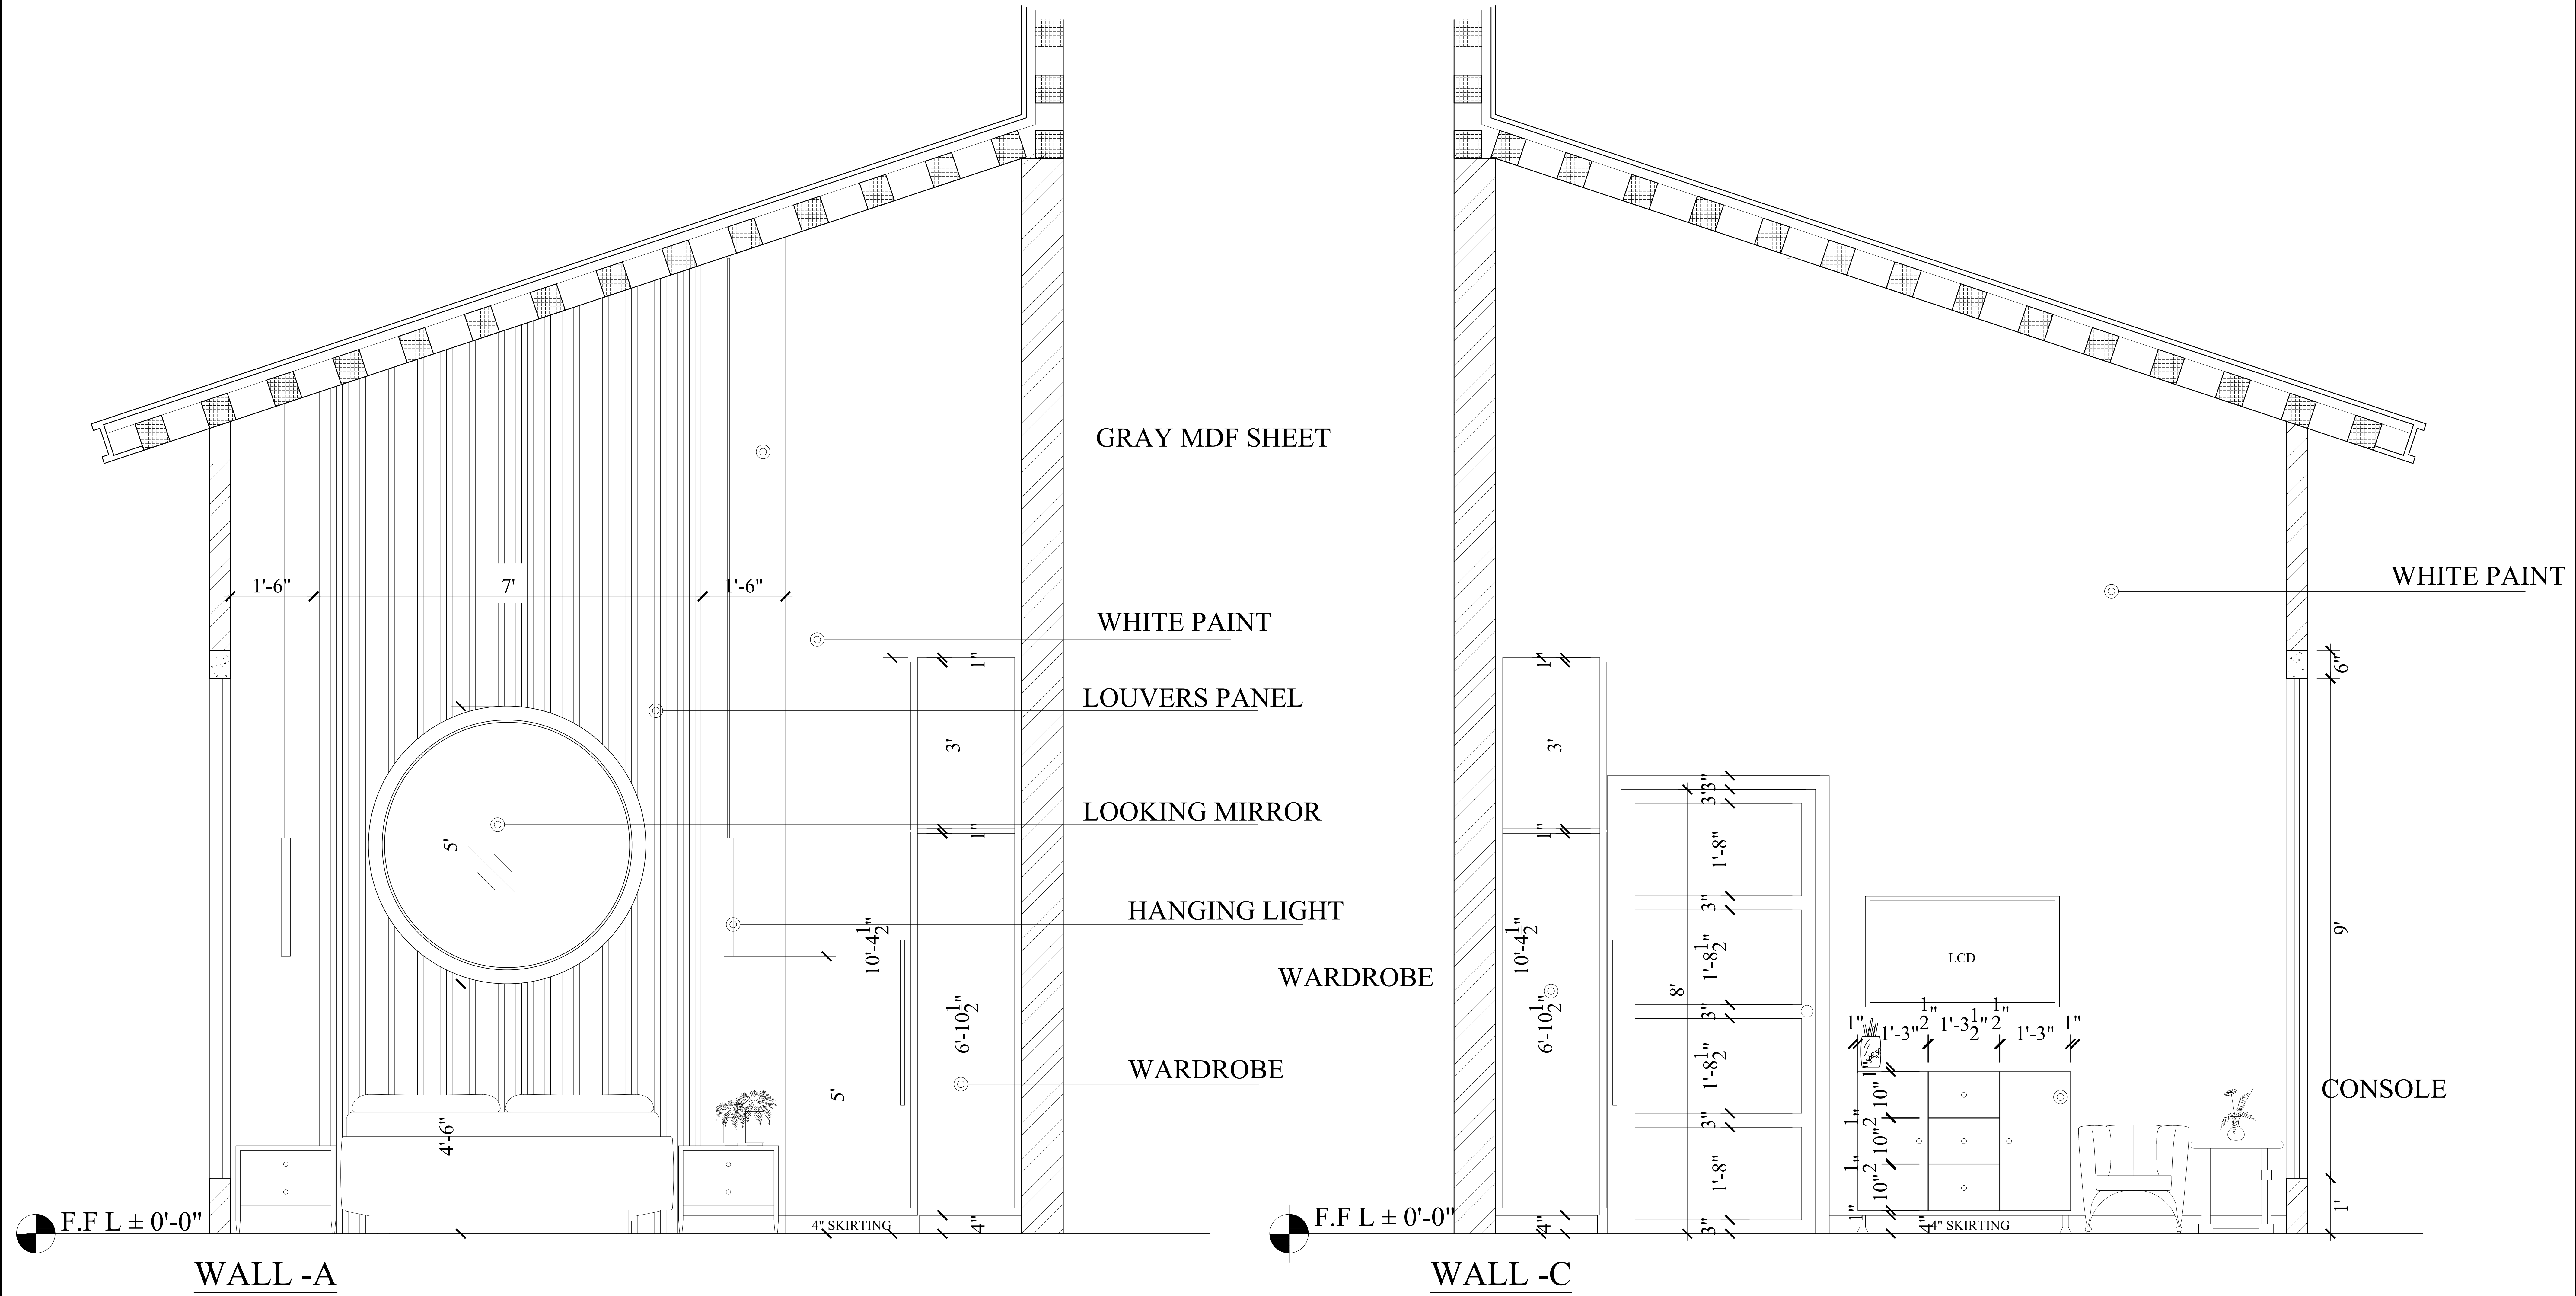

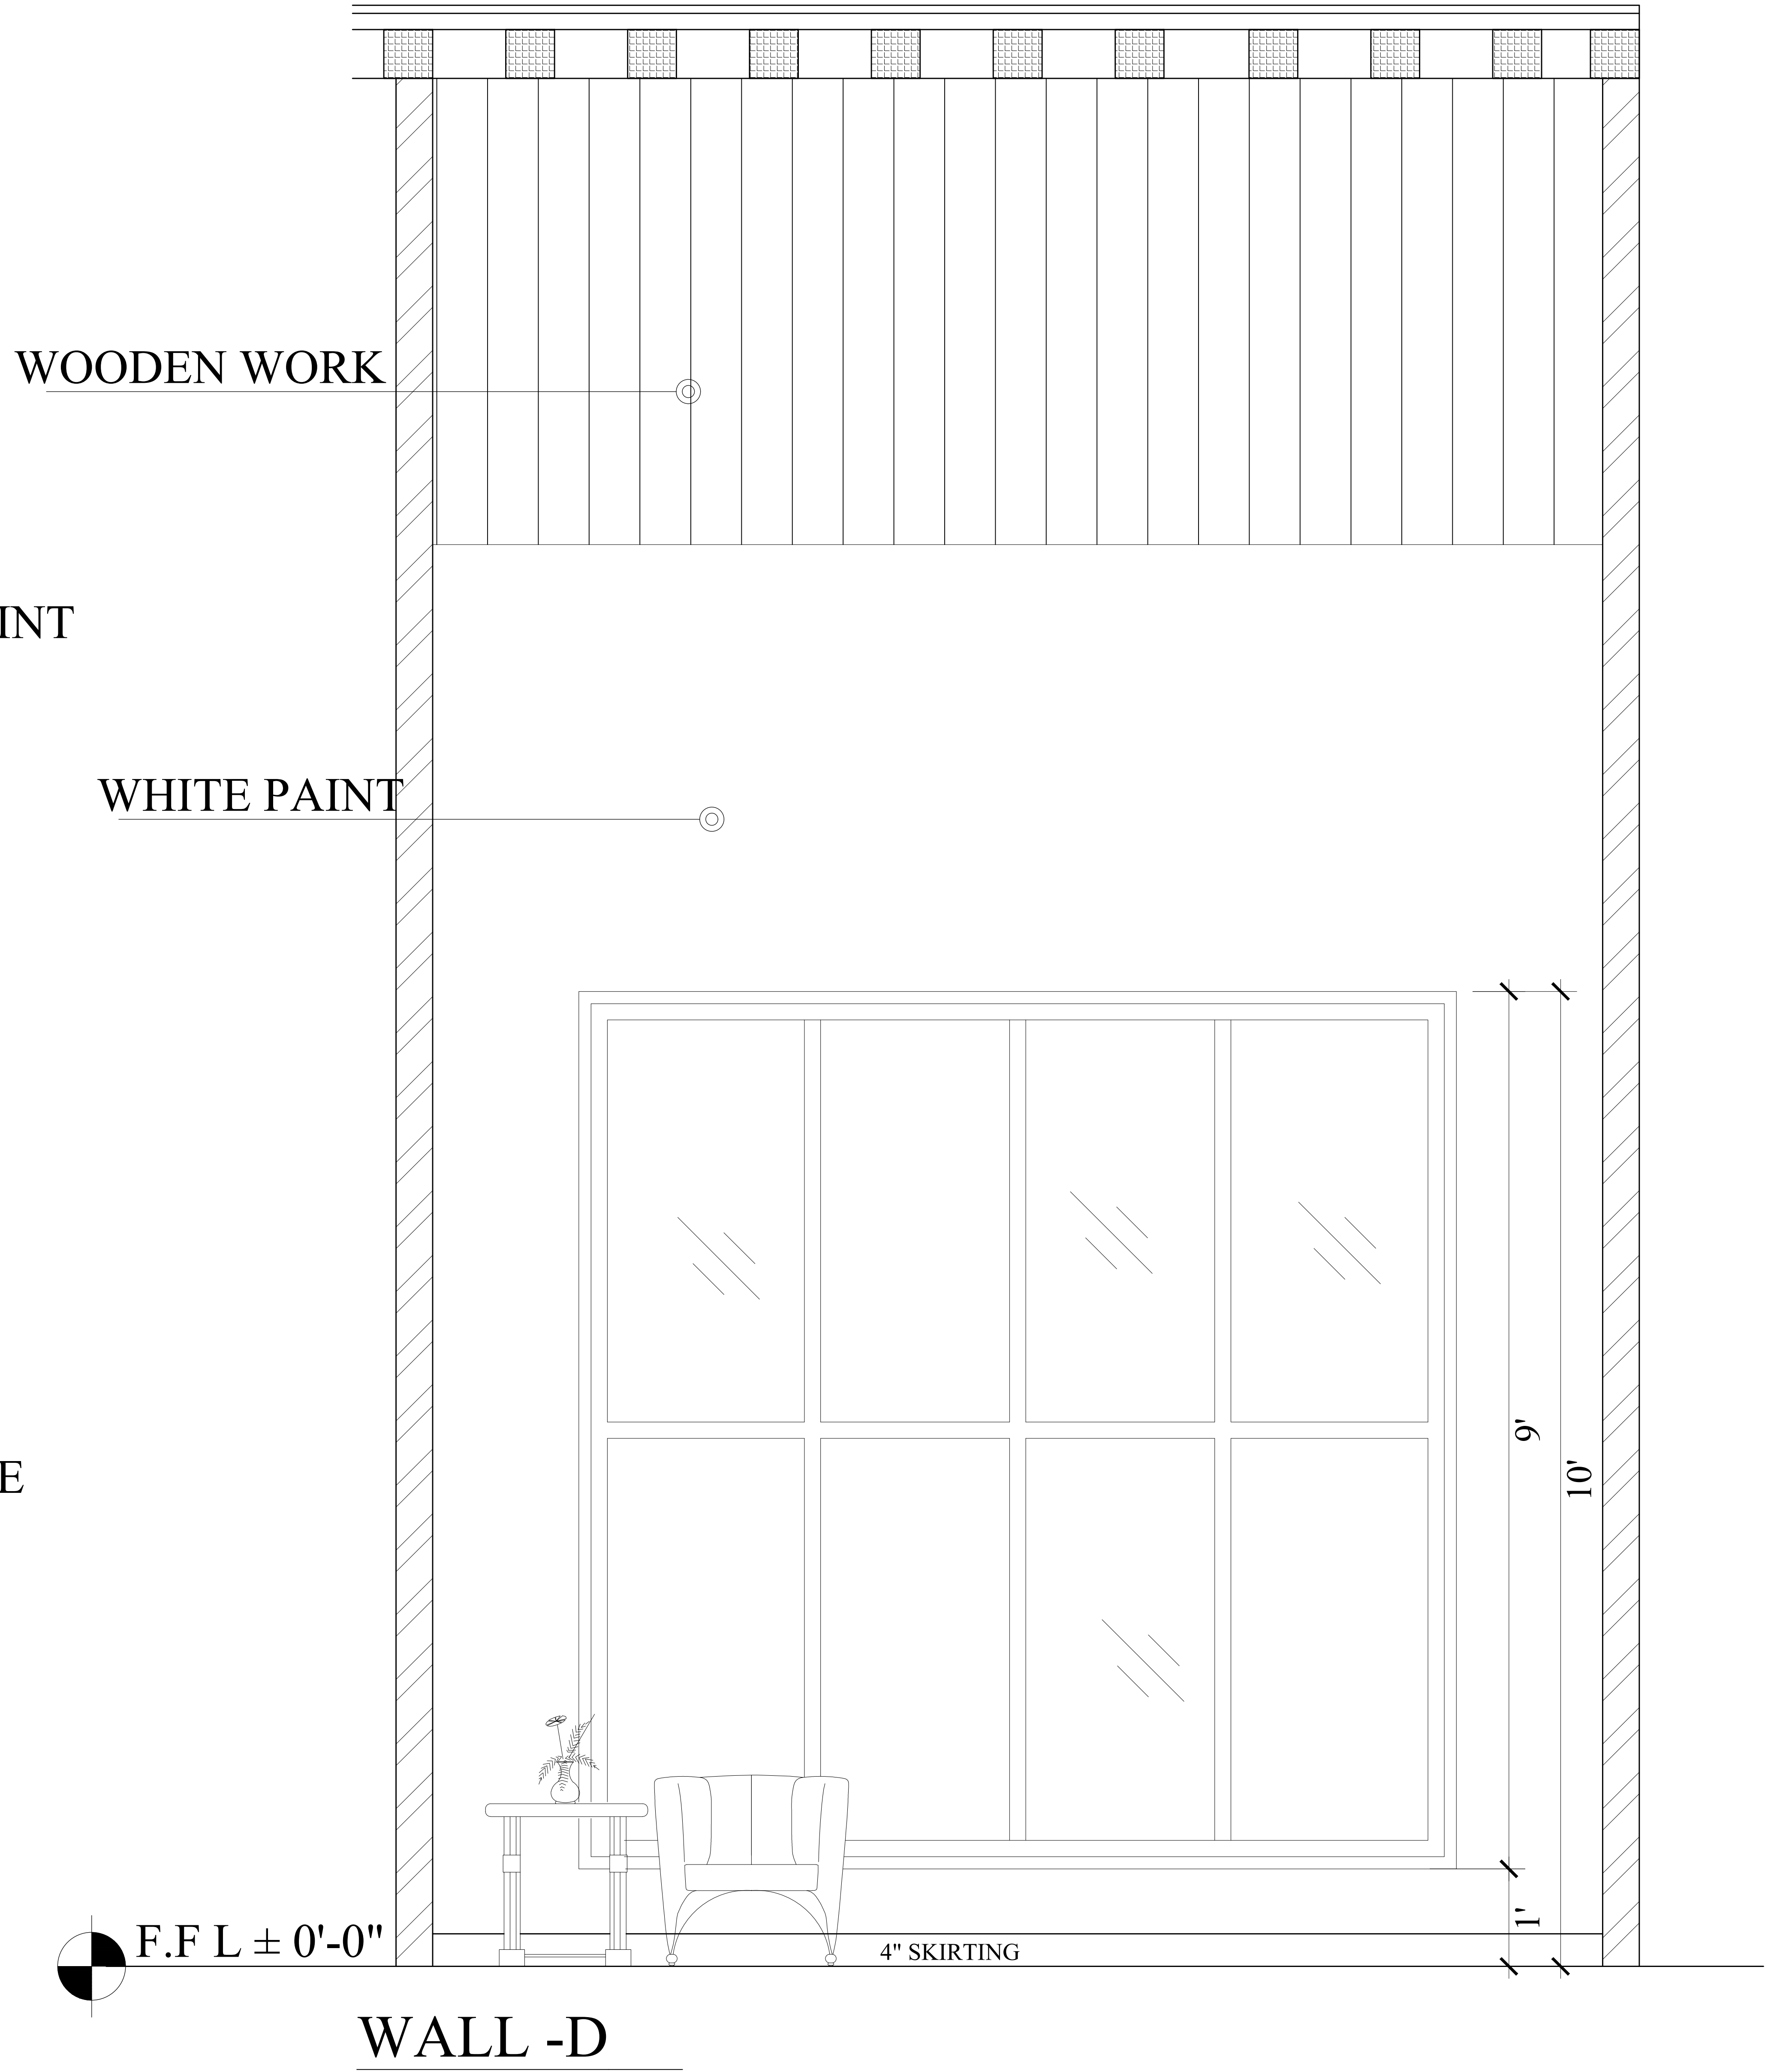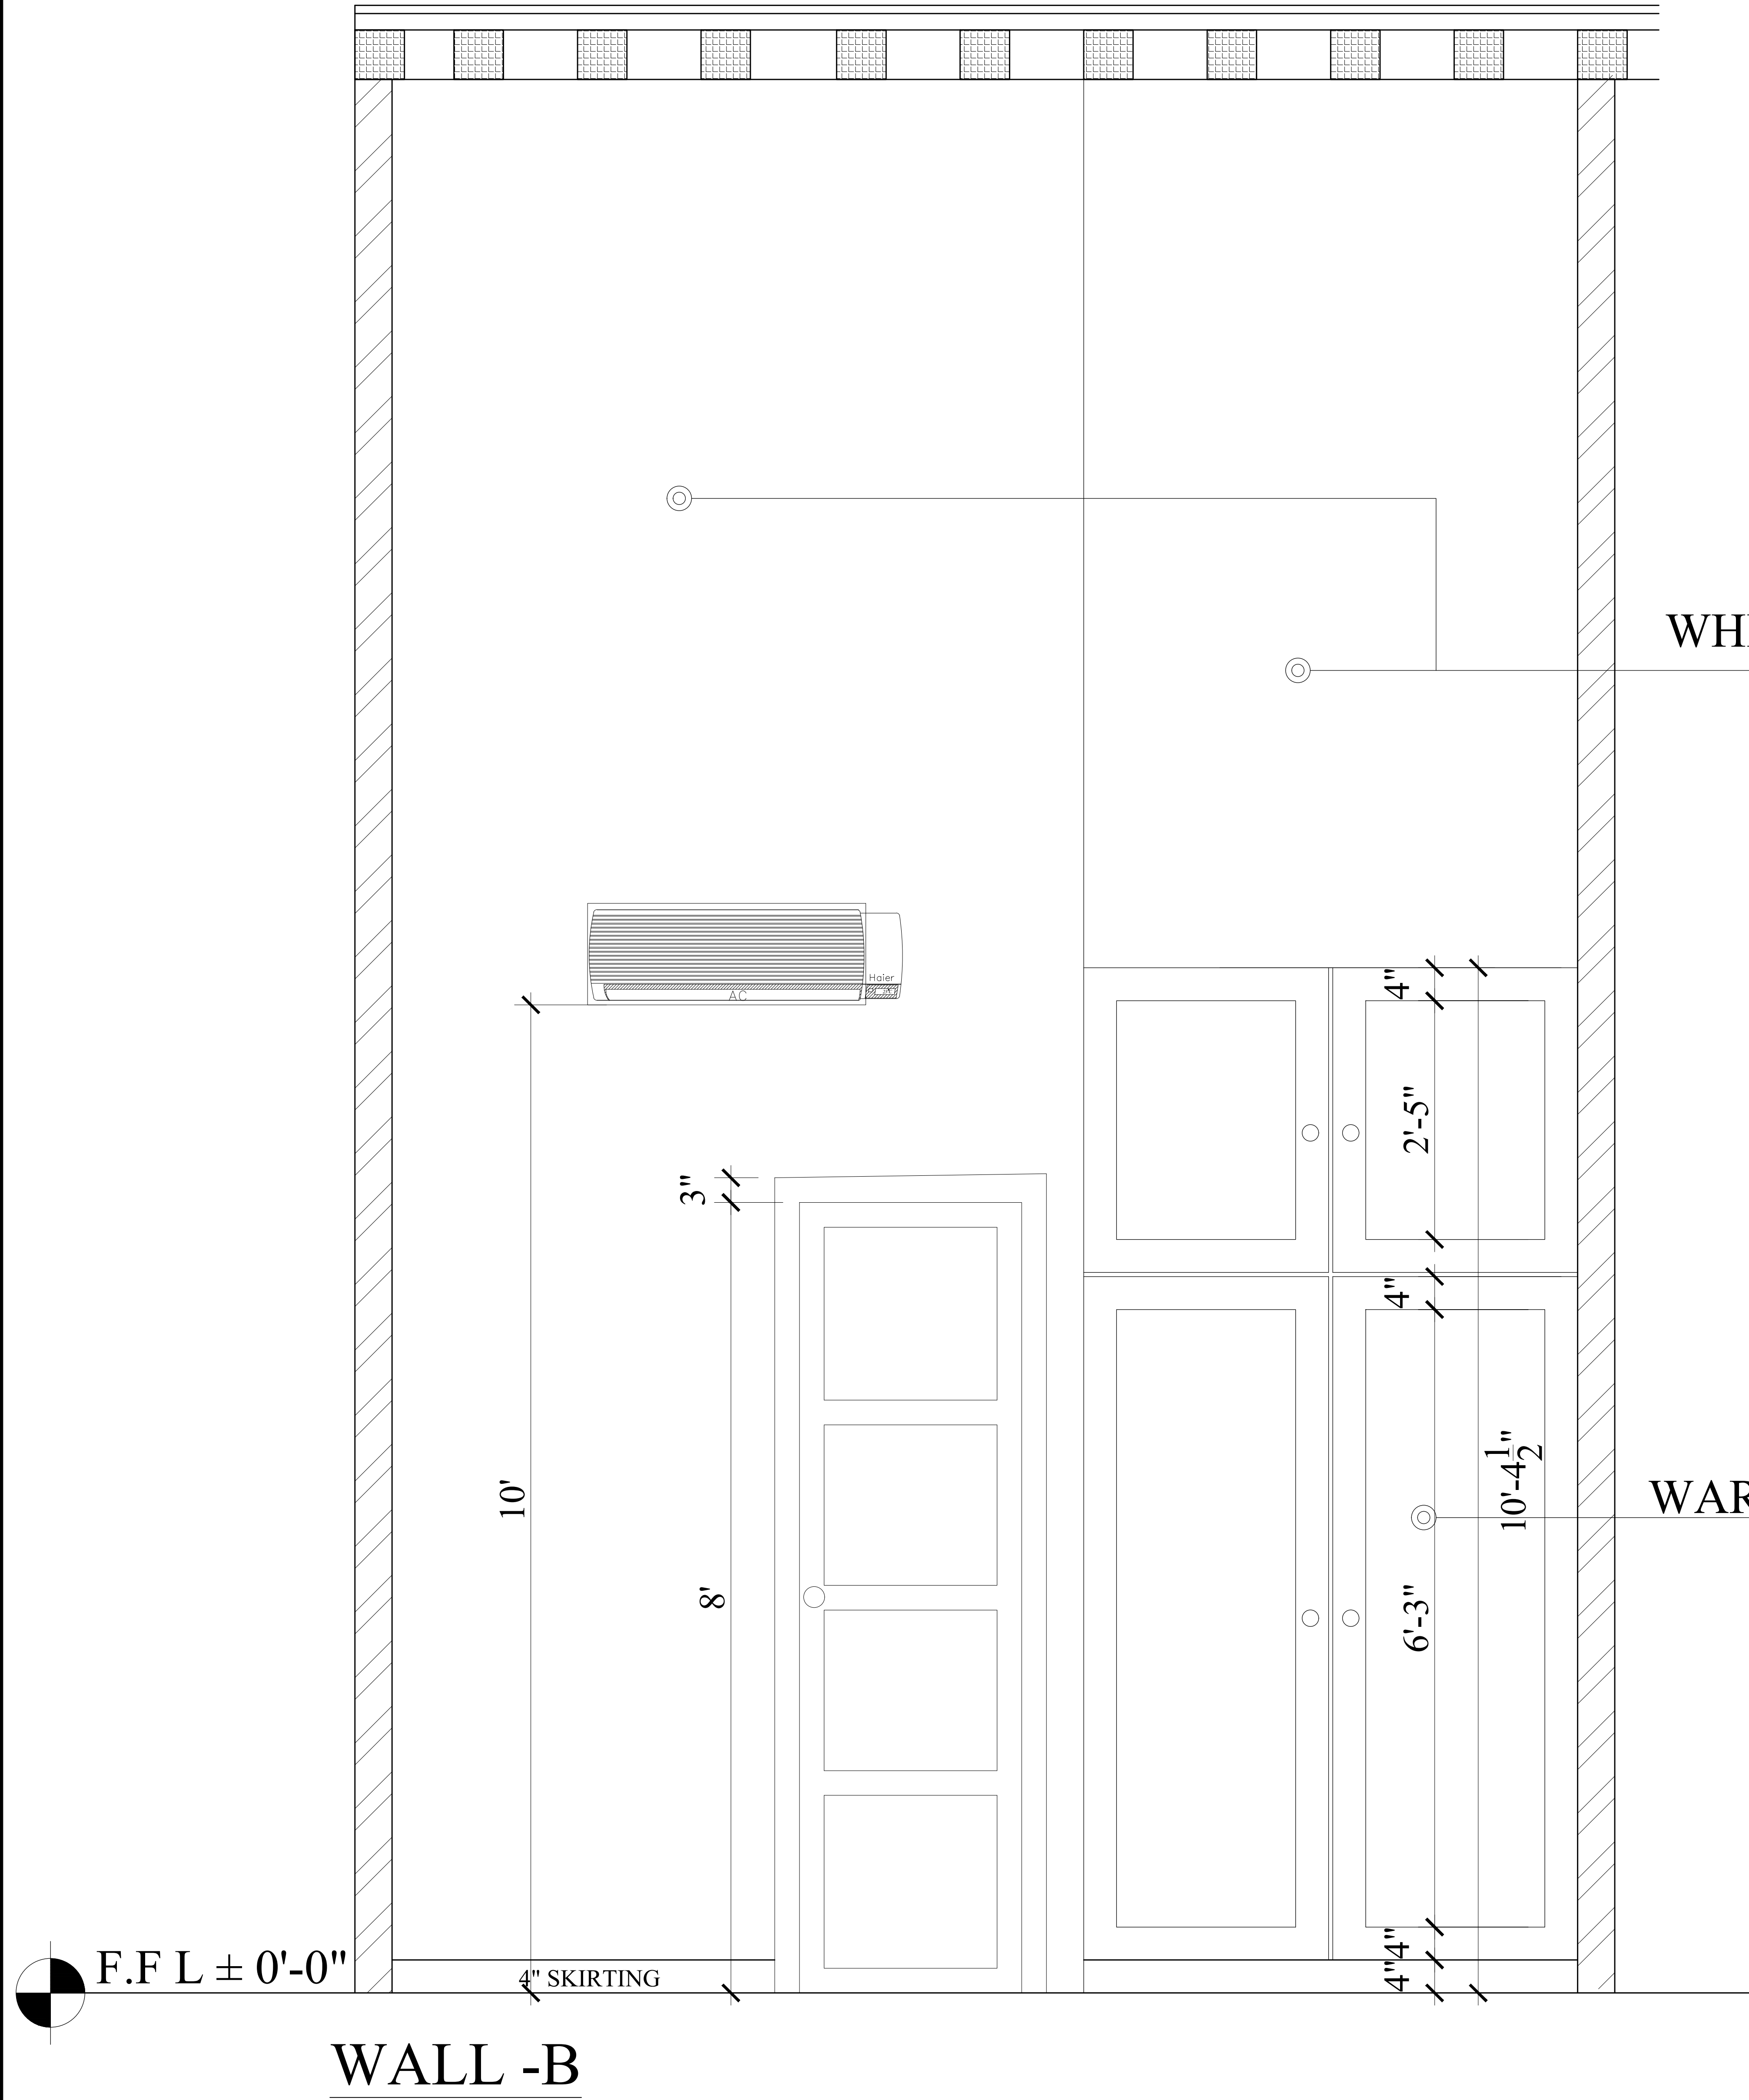

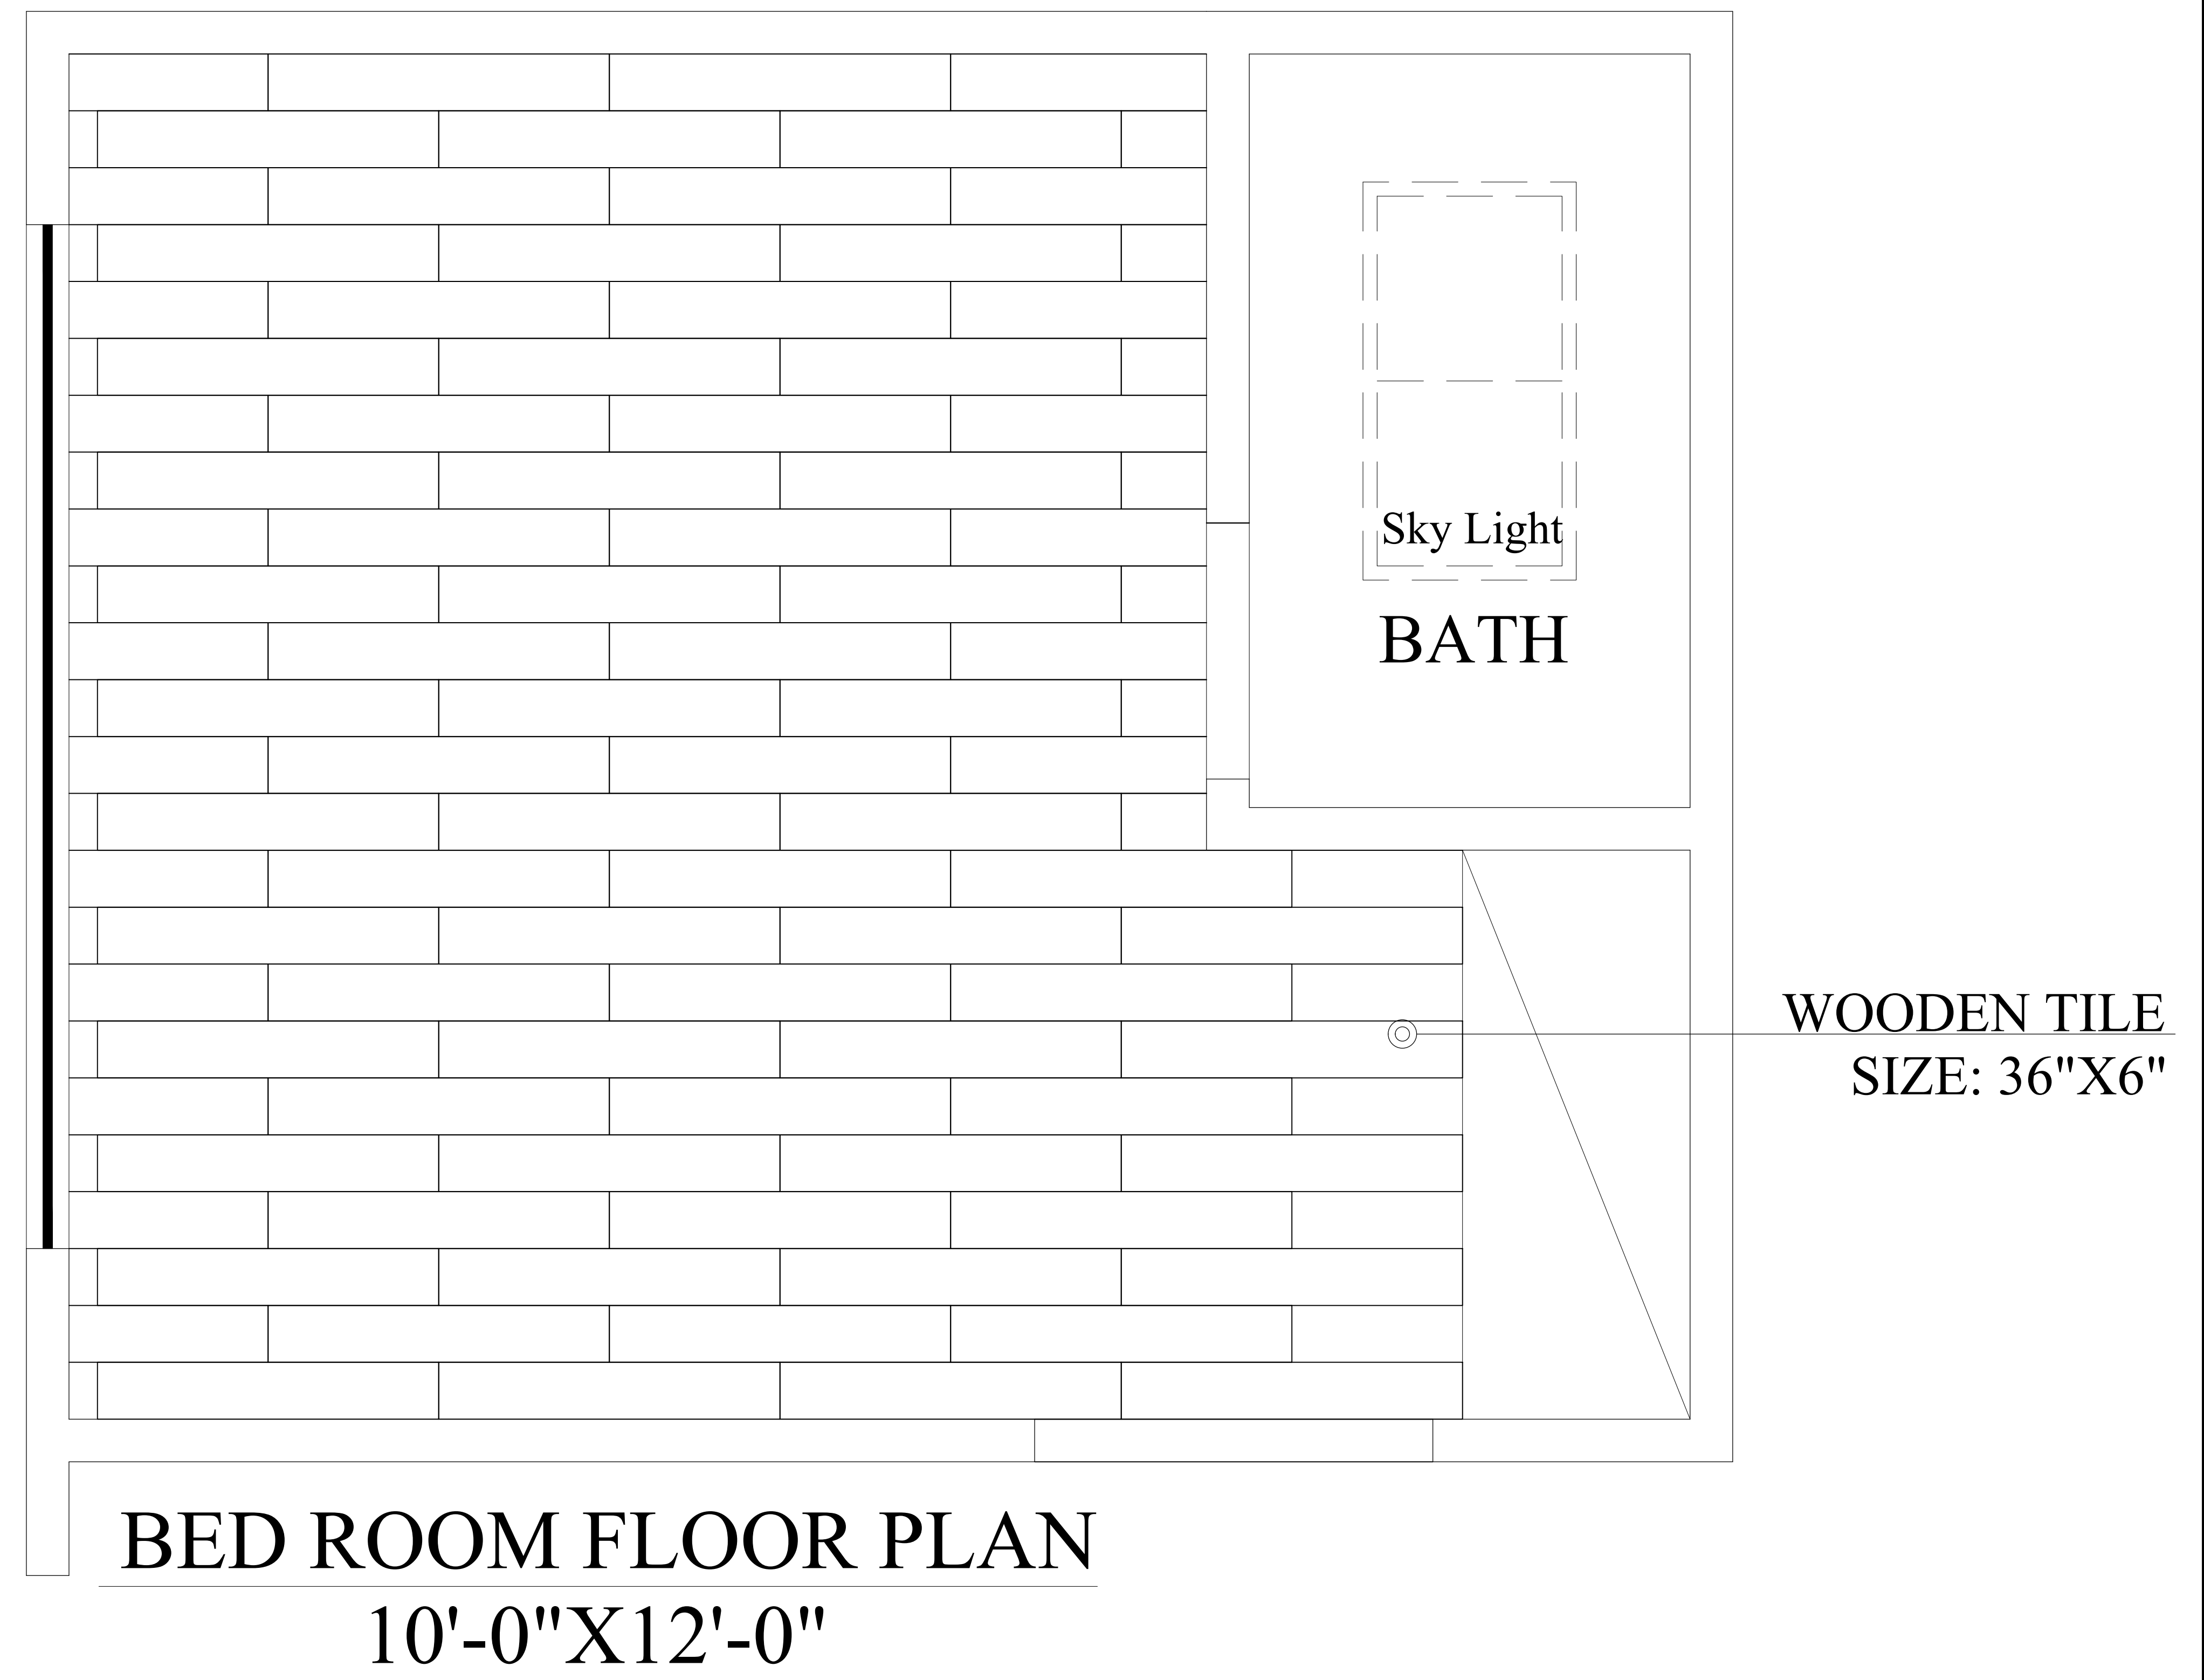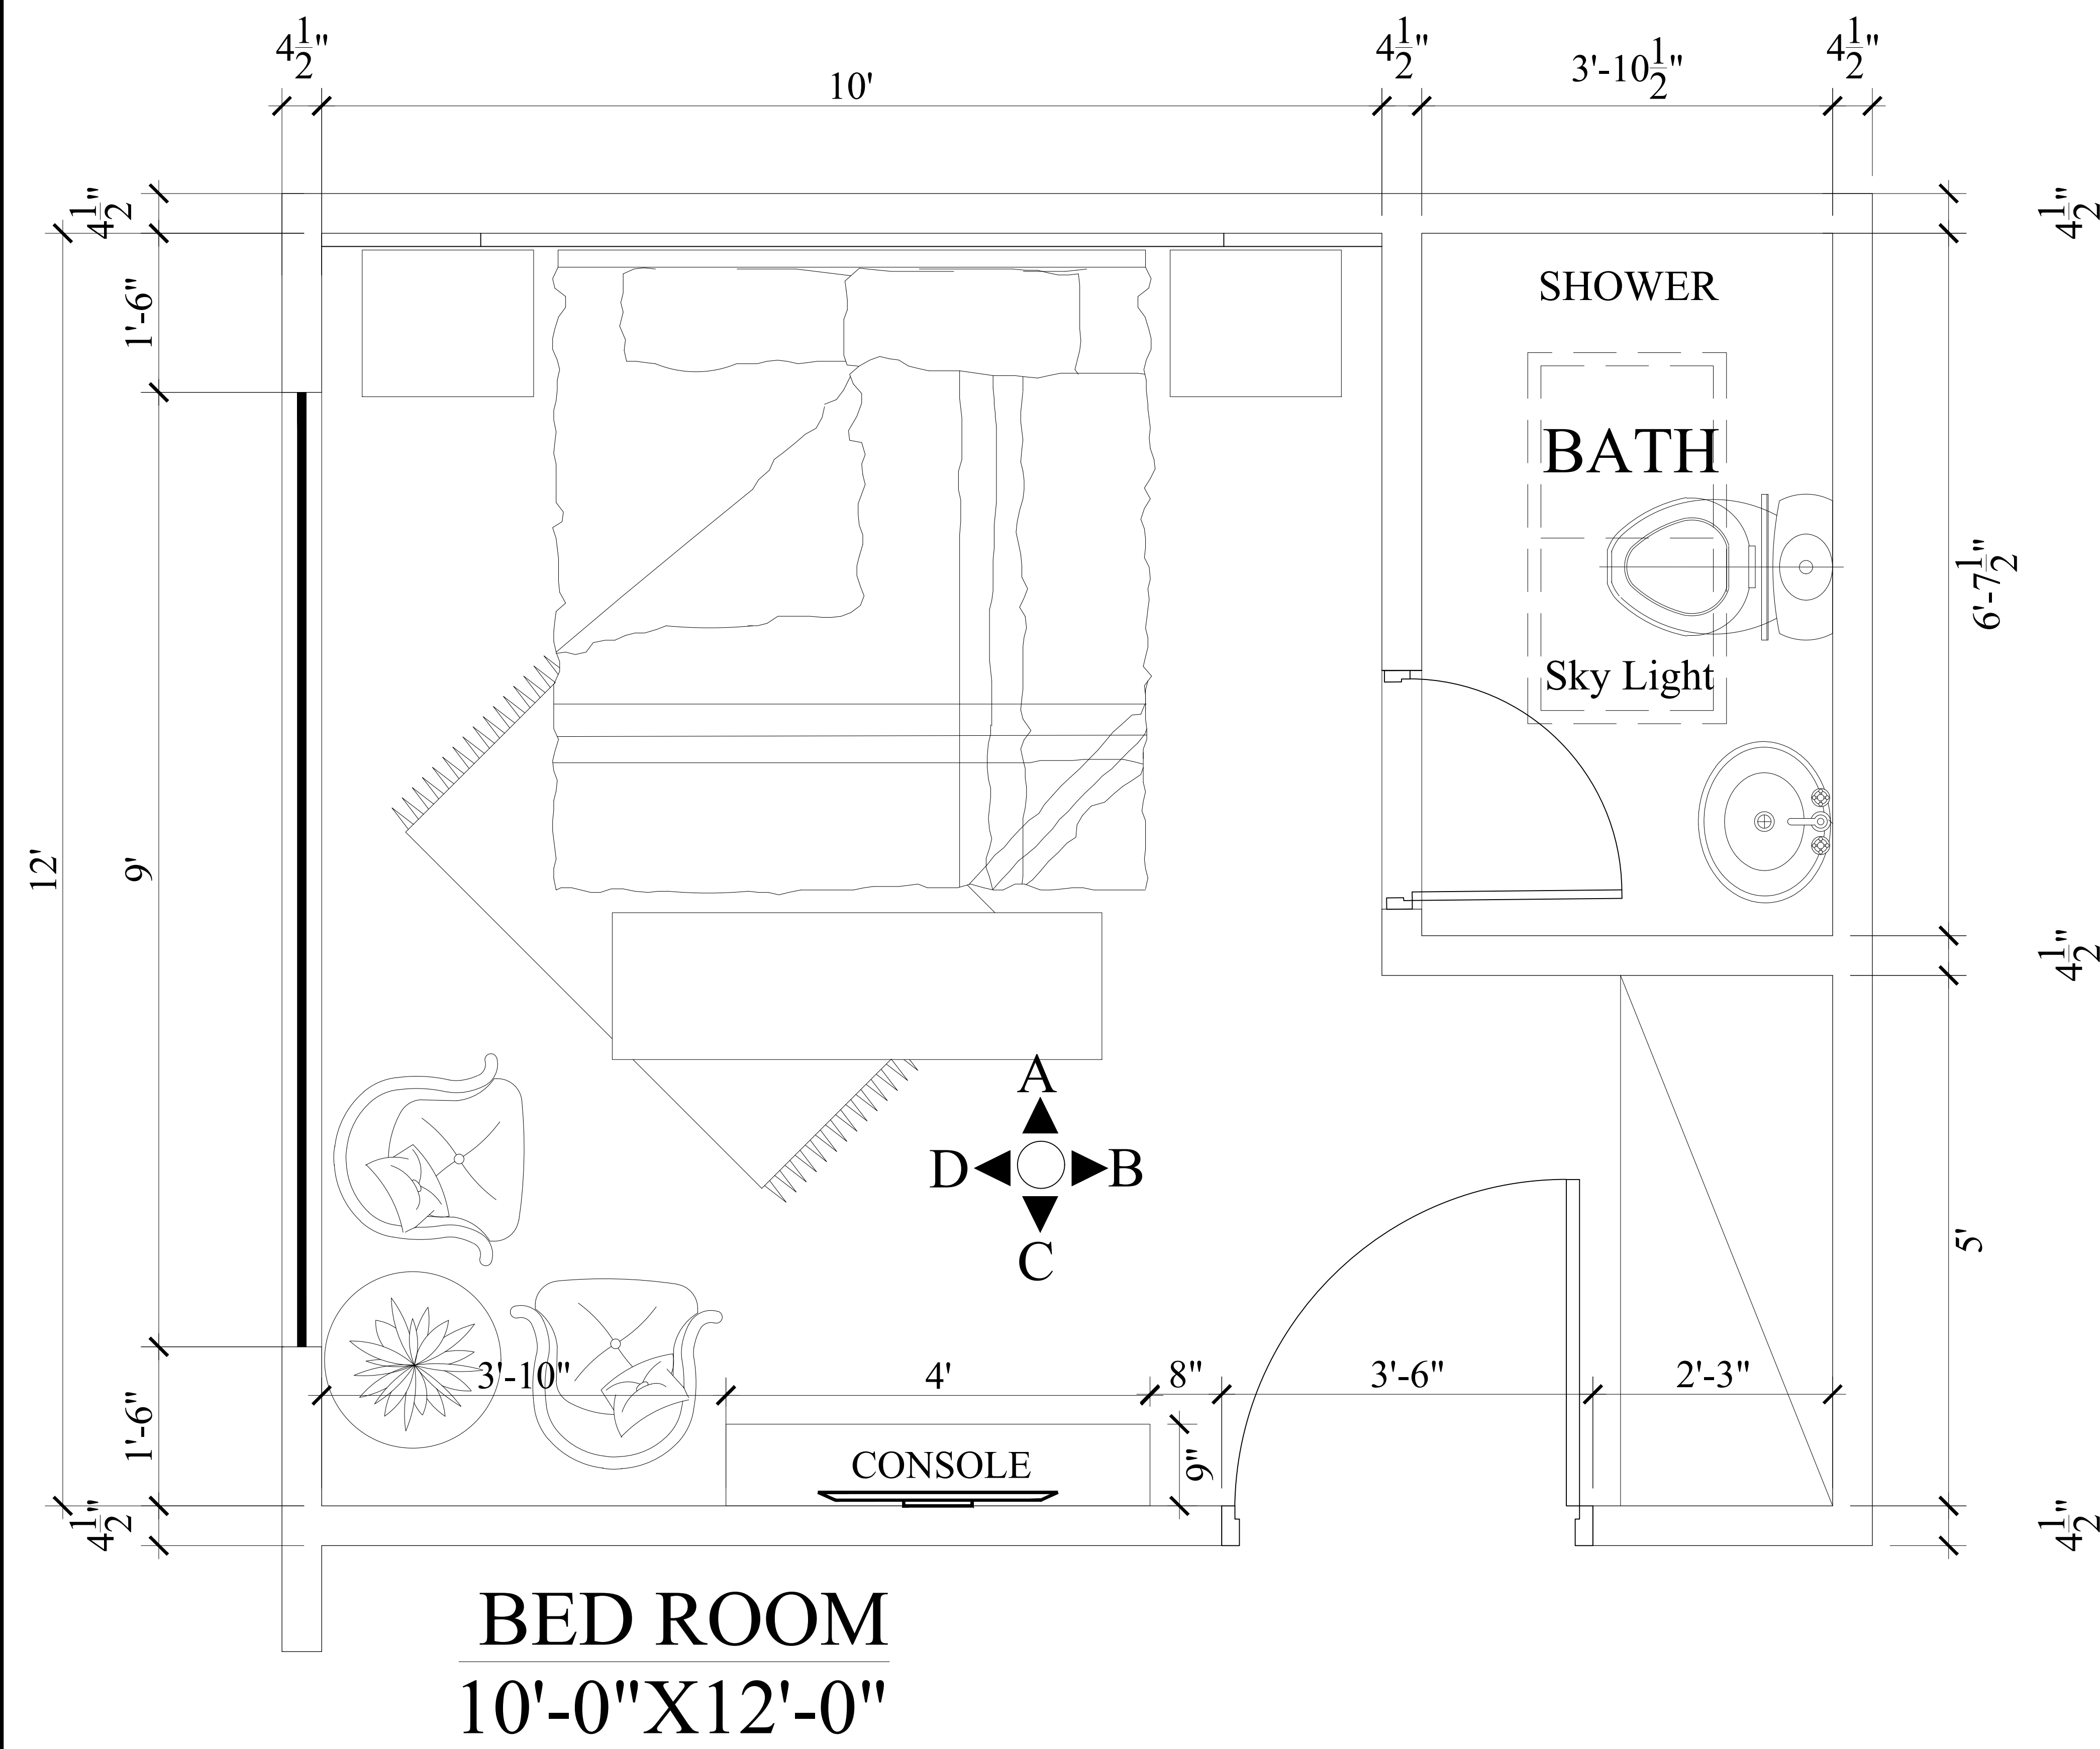



PROPOSAL DRAWINGS

TV LOUNGE & OPEN KITCHEN
FIRST 3D VIEW

PAGE NO.

09

DRAWING NO.

INT-07

DESIGN BY:

Aqib ali

CLIENT:

PROJECT :

MURREE COTTAGE HOUSE

DRAWN BY:

Eshan

DATE:

23.08.2024



PROPOSAL DRAWINGS

TV LOUNGE & OPEN KITCHEN
SECOND 3D VIEW

PAGE NO.

10

DRAWING NO.

INT-08

DESIGN BY:

Aqib ali

CLIENT:

PROJECT :

MURREE COTTAGE HOUSE

DRAWN BY:

Eshan

DATE:

23.08.2024



PROPOSAL DRAWINGS

TV LOUNGE & OPEN KITCHEN
SECOND 3D VIEW

PAGE NO.

11

CLIENT:

DRAWING NO.

INT-09

PROJECT :

MURREE COTTAGE HOUSE

DESIGN BY:

Aqib ali

DRAWN BY:

Eshan

DATE:

23.08.2024



PROPOSAL DRAWINGS

TV LOUNGE & OPEN KITCHEN
SECOND 3D VIEW

PAGE NO.

12

CLIENT:

DRAWING NO.

INT-10

PROJECT :

MURREE COTTAGE HOUSE

DESIGN BY:



Aqib ali

DRAWN BY:

Eshan

DATE:

23.08.2024

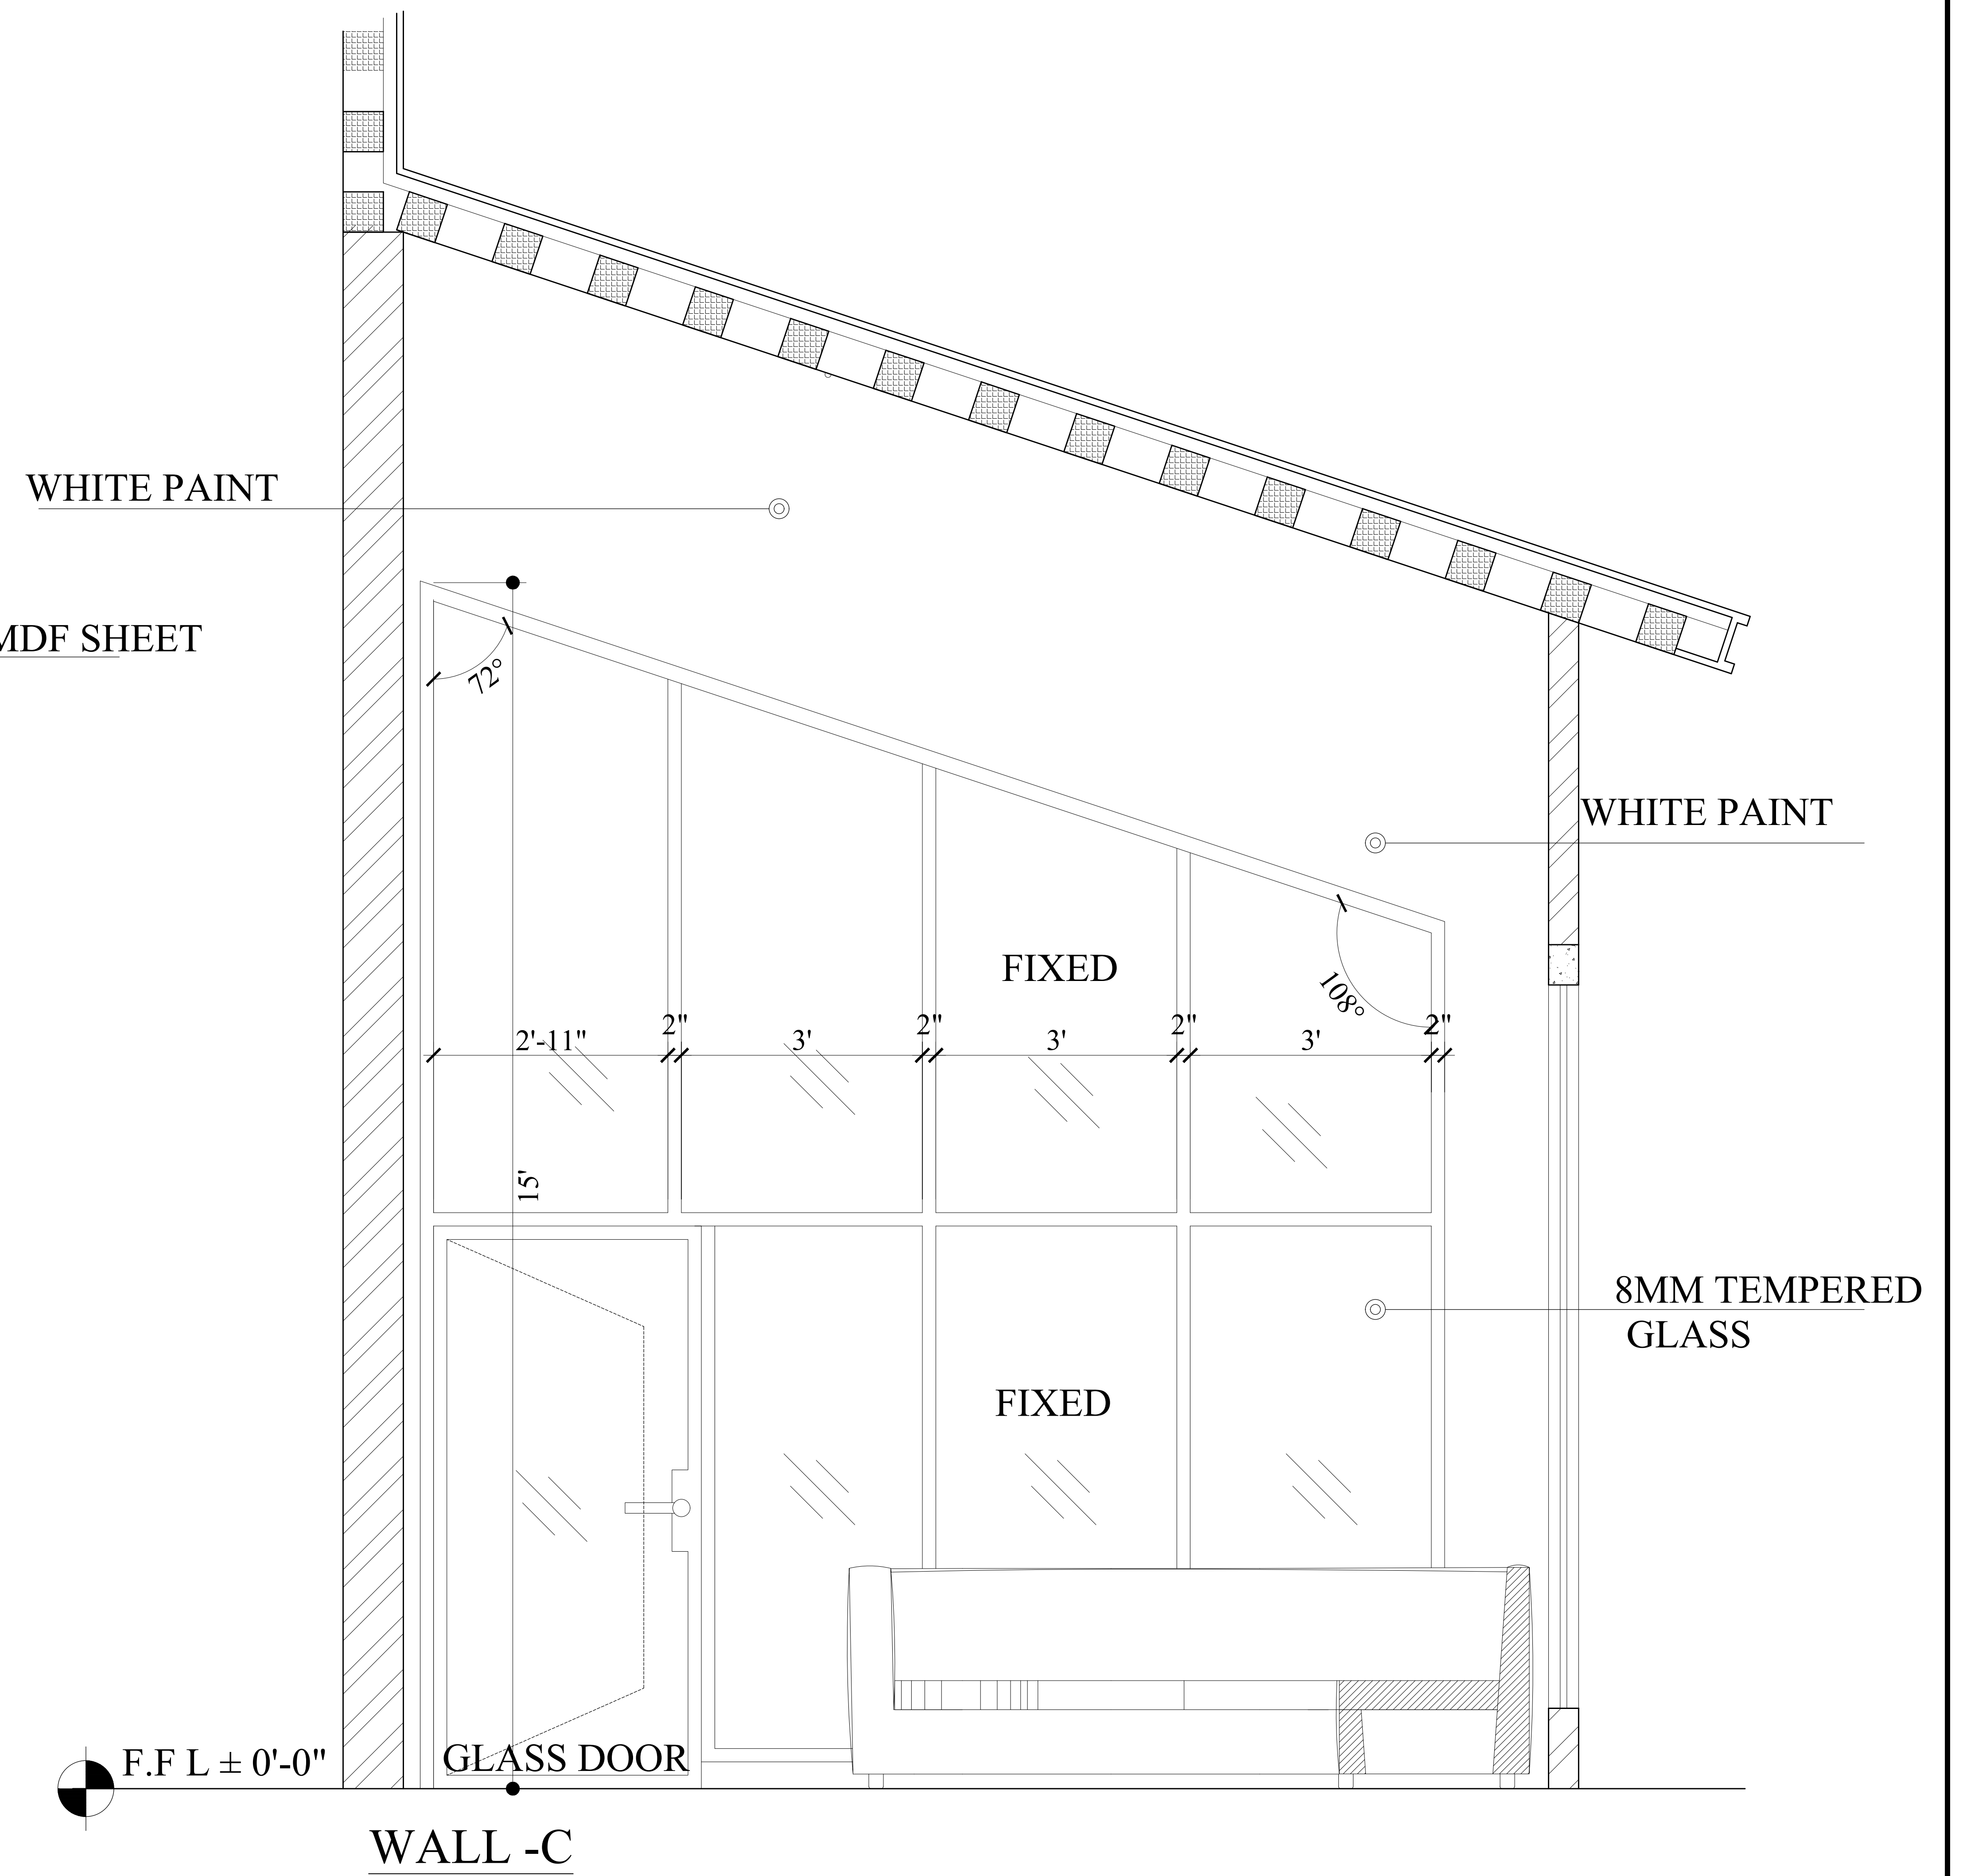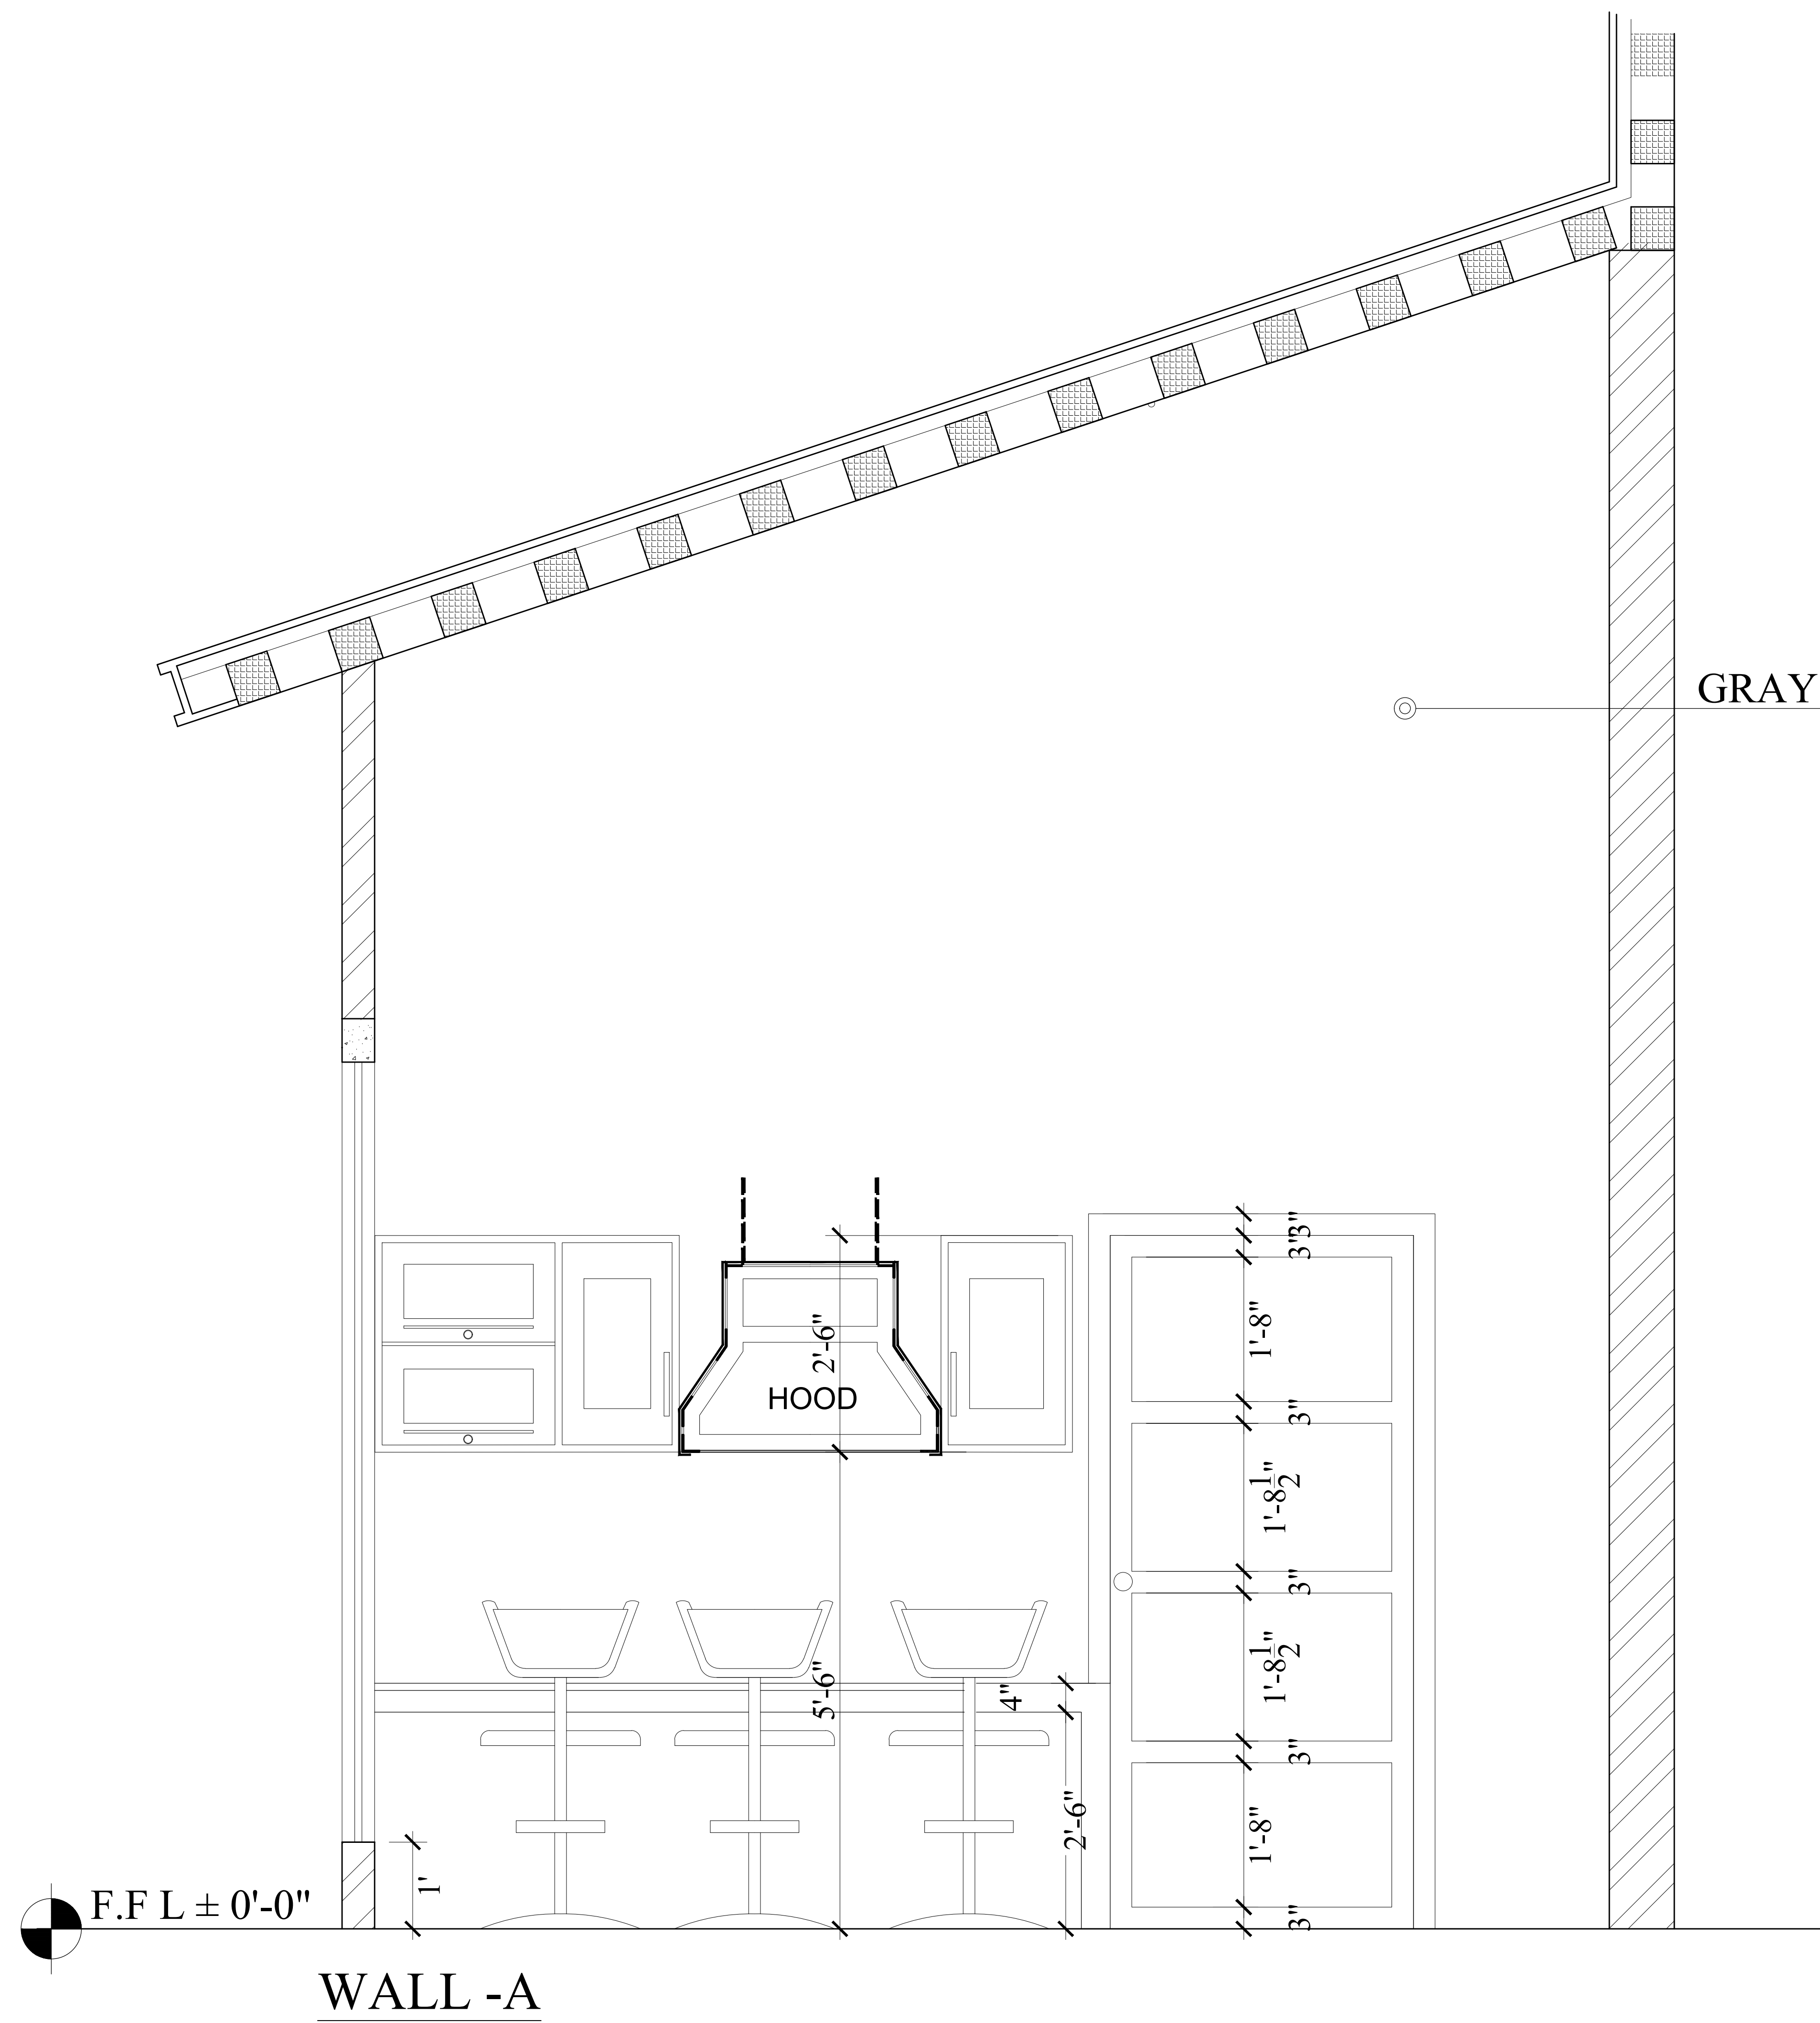

PROPOSAL DRAWINGS

TV LOUNGE & OPEN KITCHEN
WALL A / C

PAGE NO.

13

CLIENT:

.....

DRAWING NO.

INT-11

PROJECT :

MURREE COTTAGE HOUSE

DESIGN BY:



Aqib ali

DRAWN BY:



Eshan

DATE:

23.08.2024

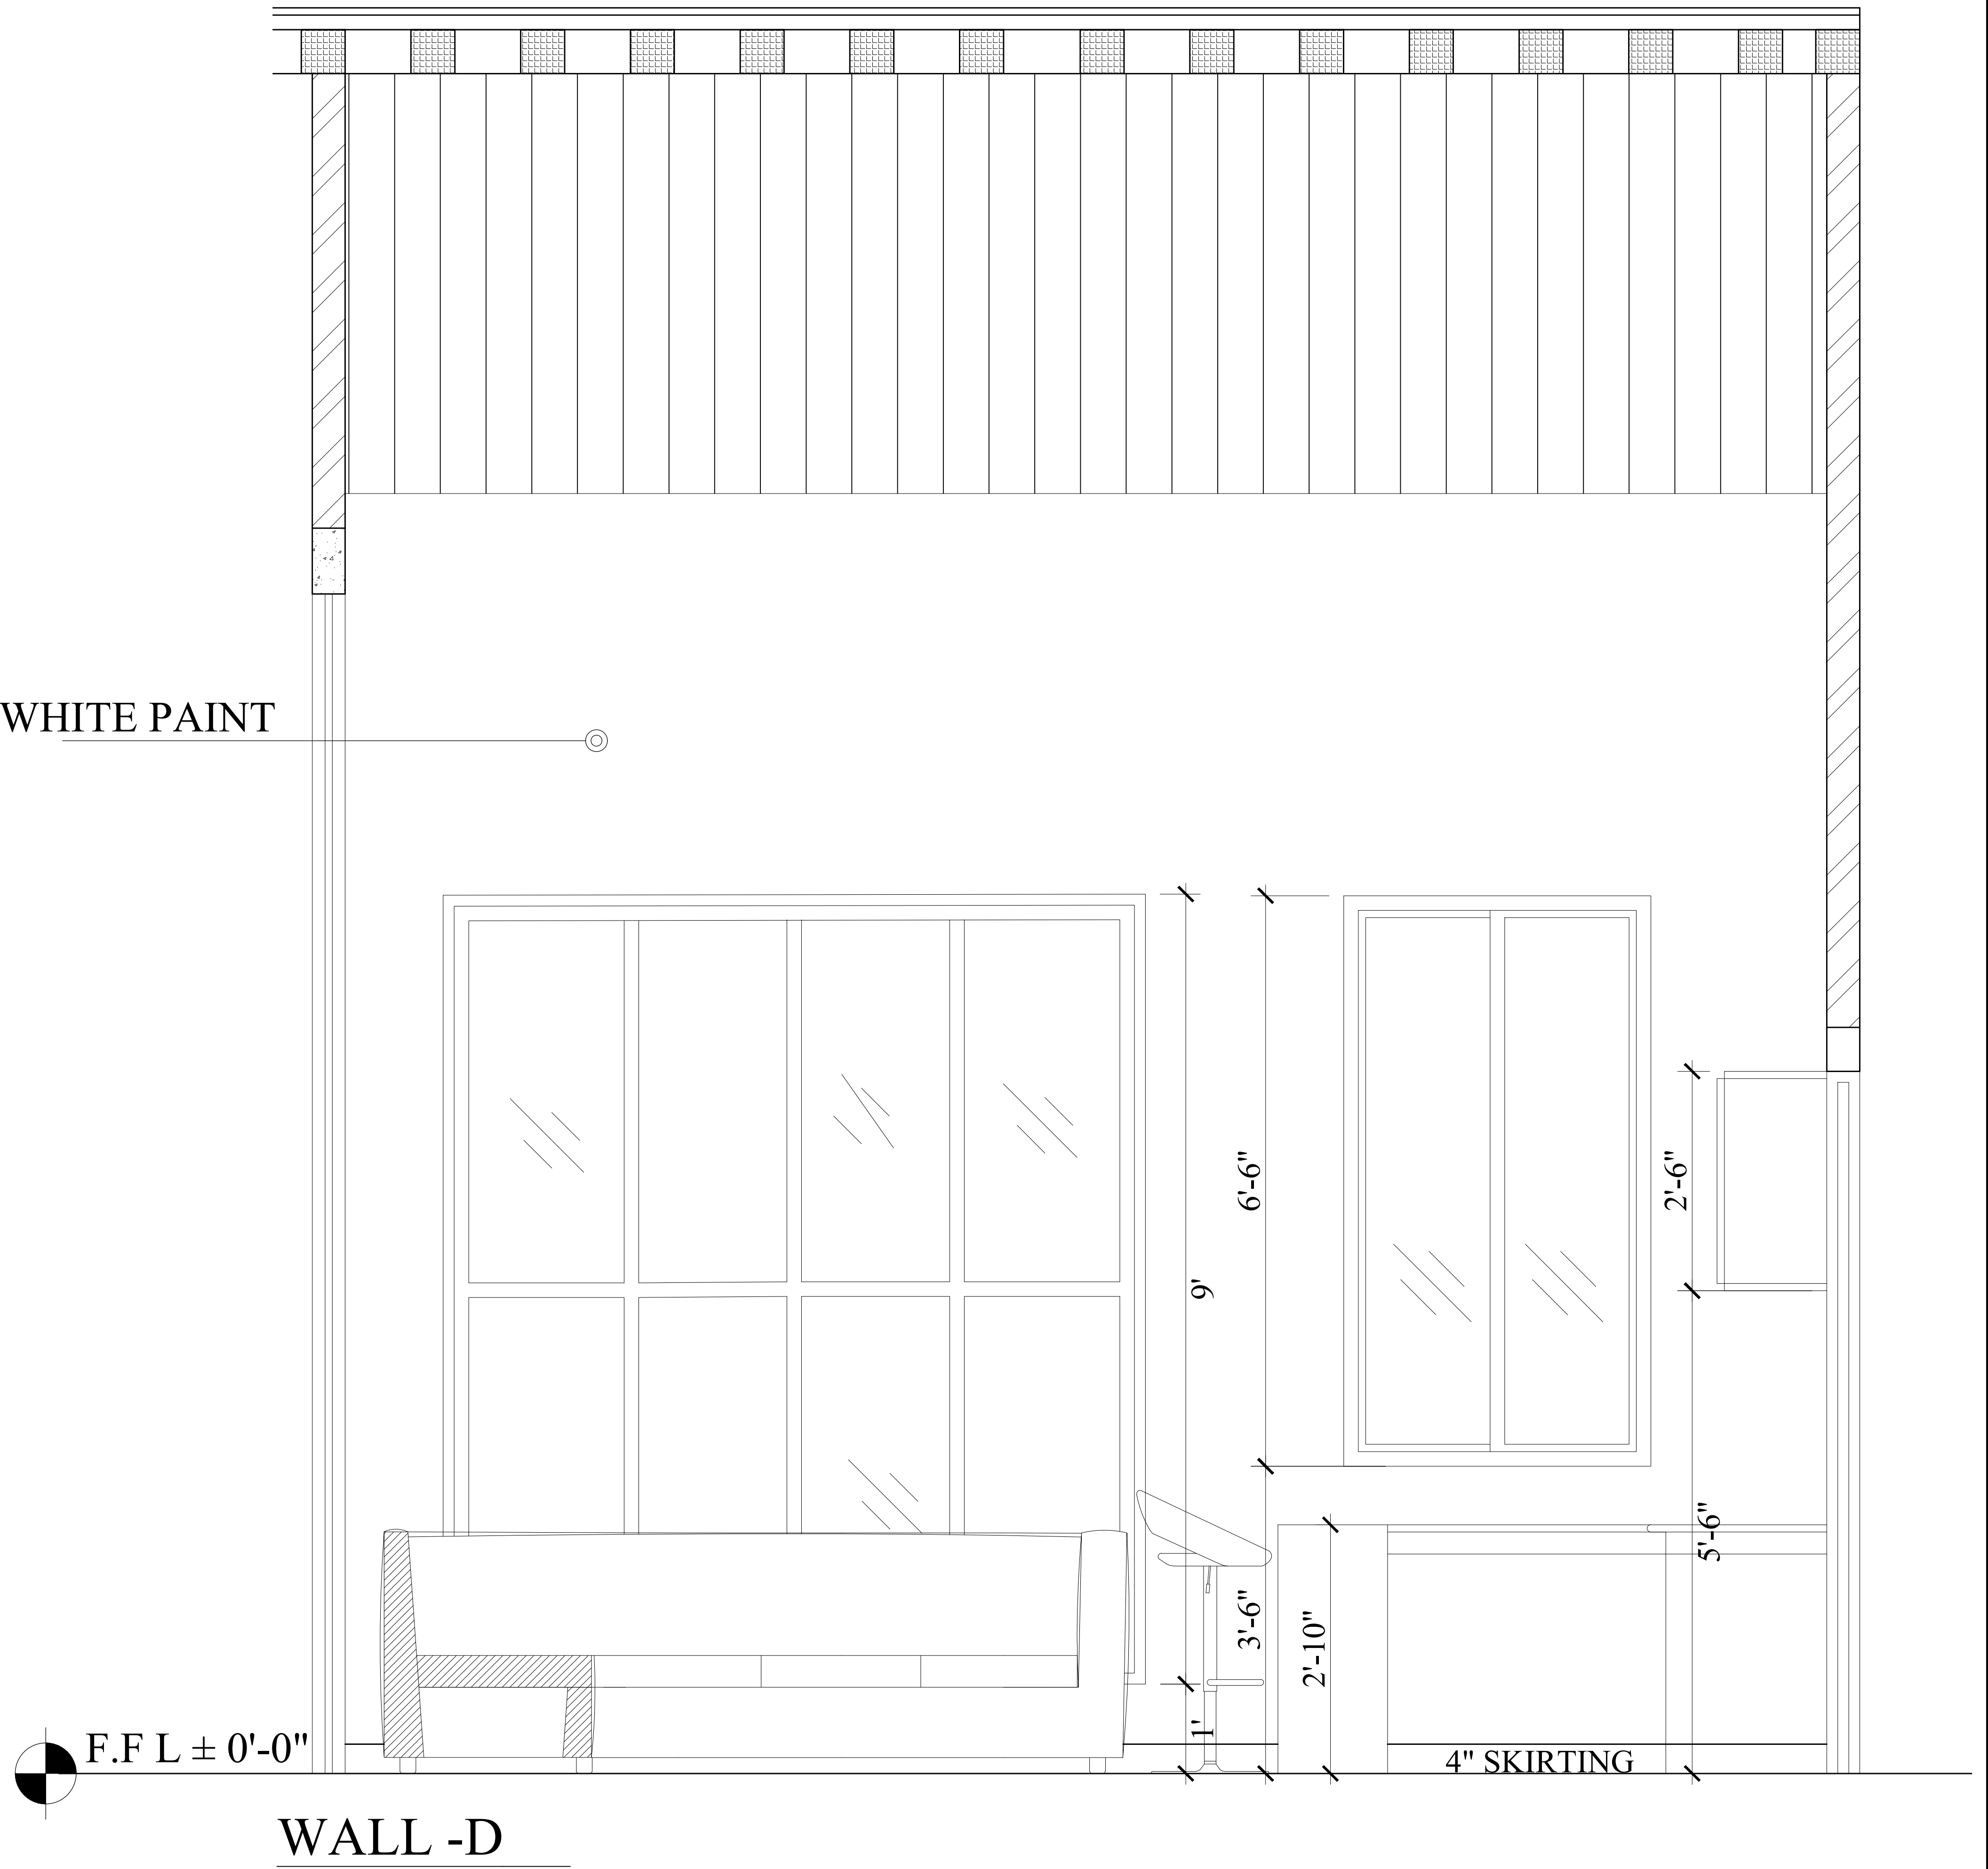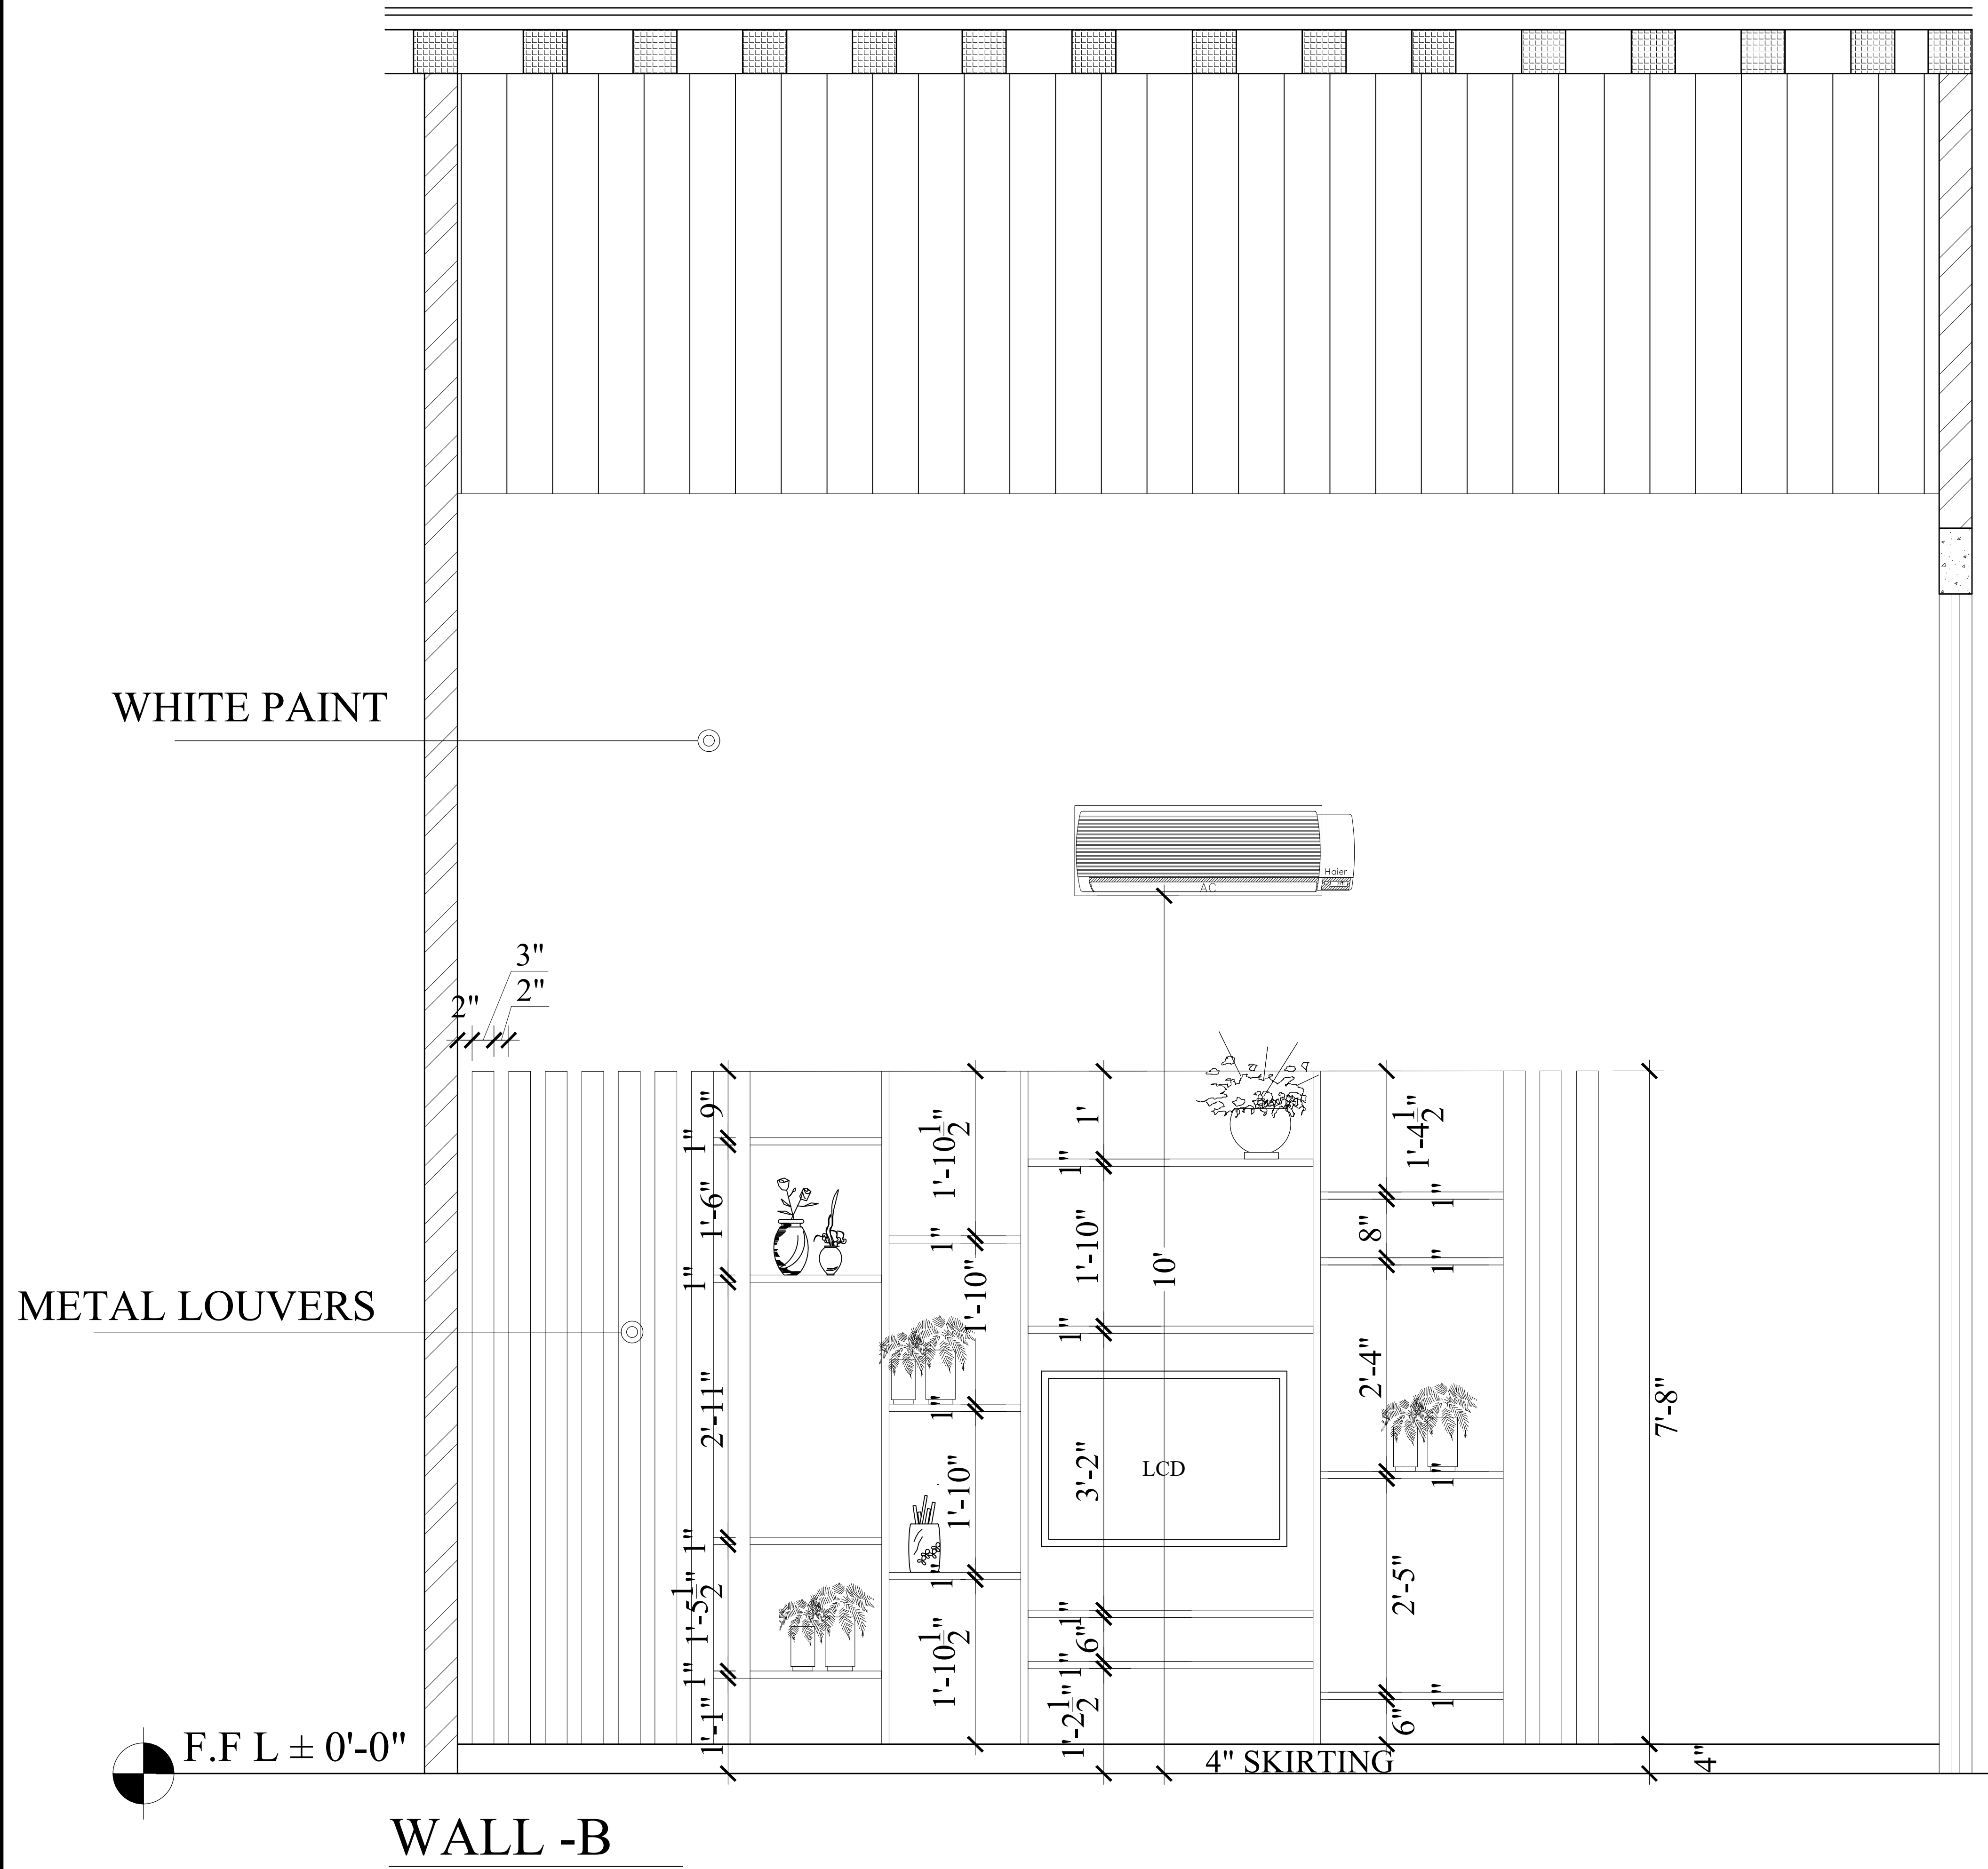

REVISE WINDOW

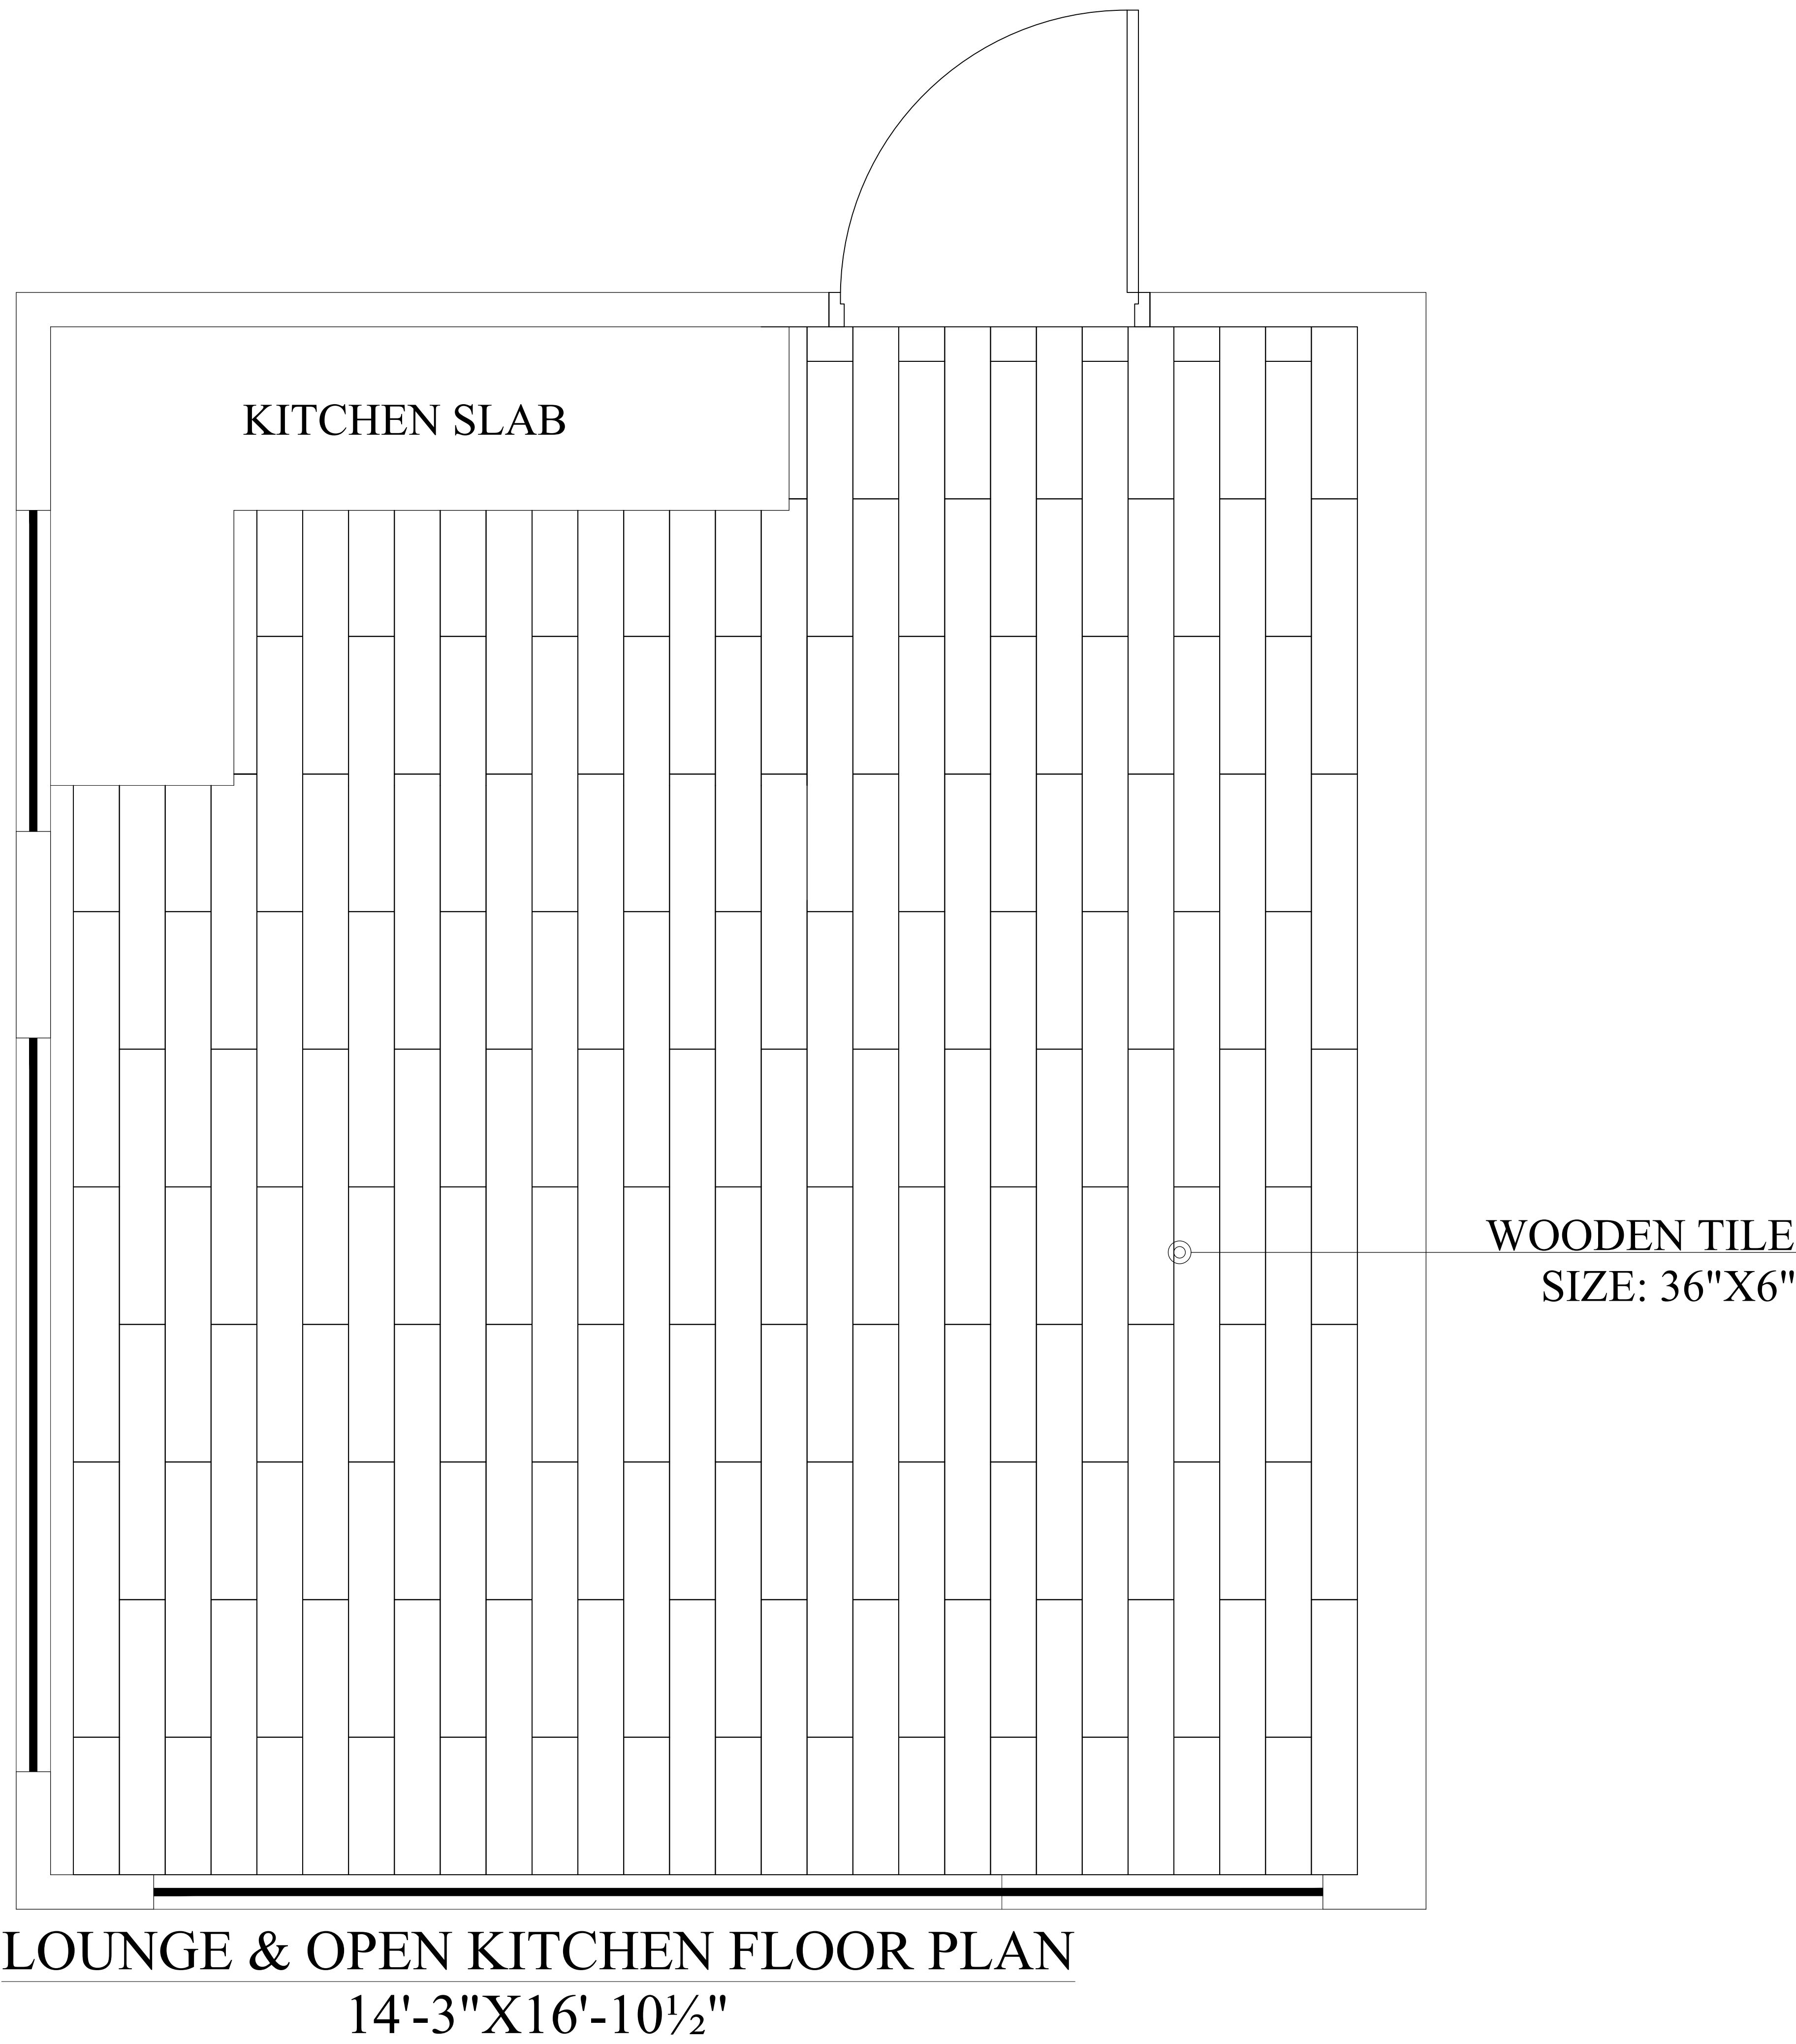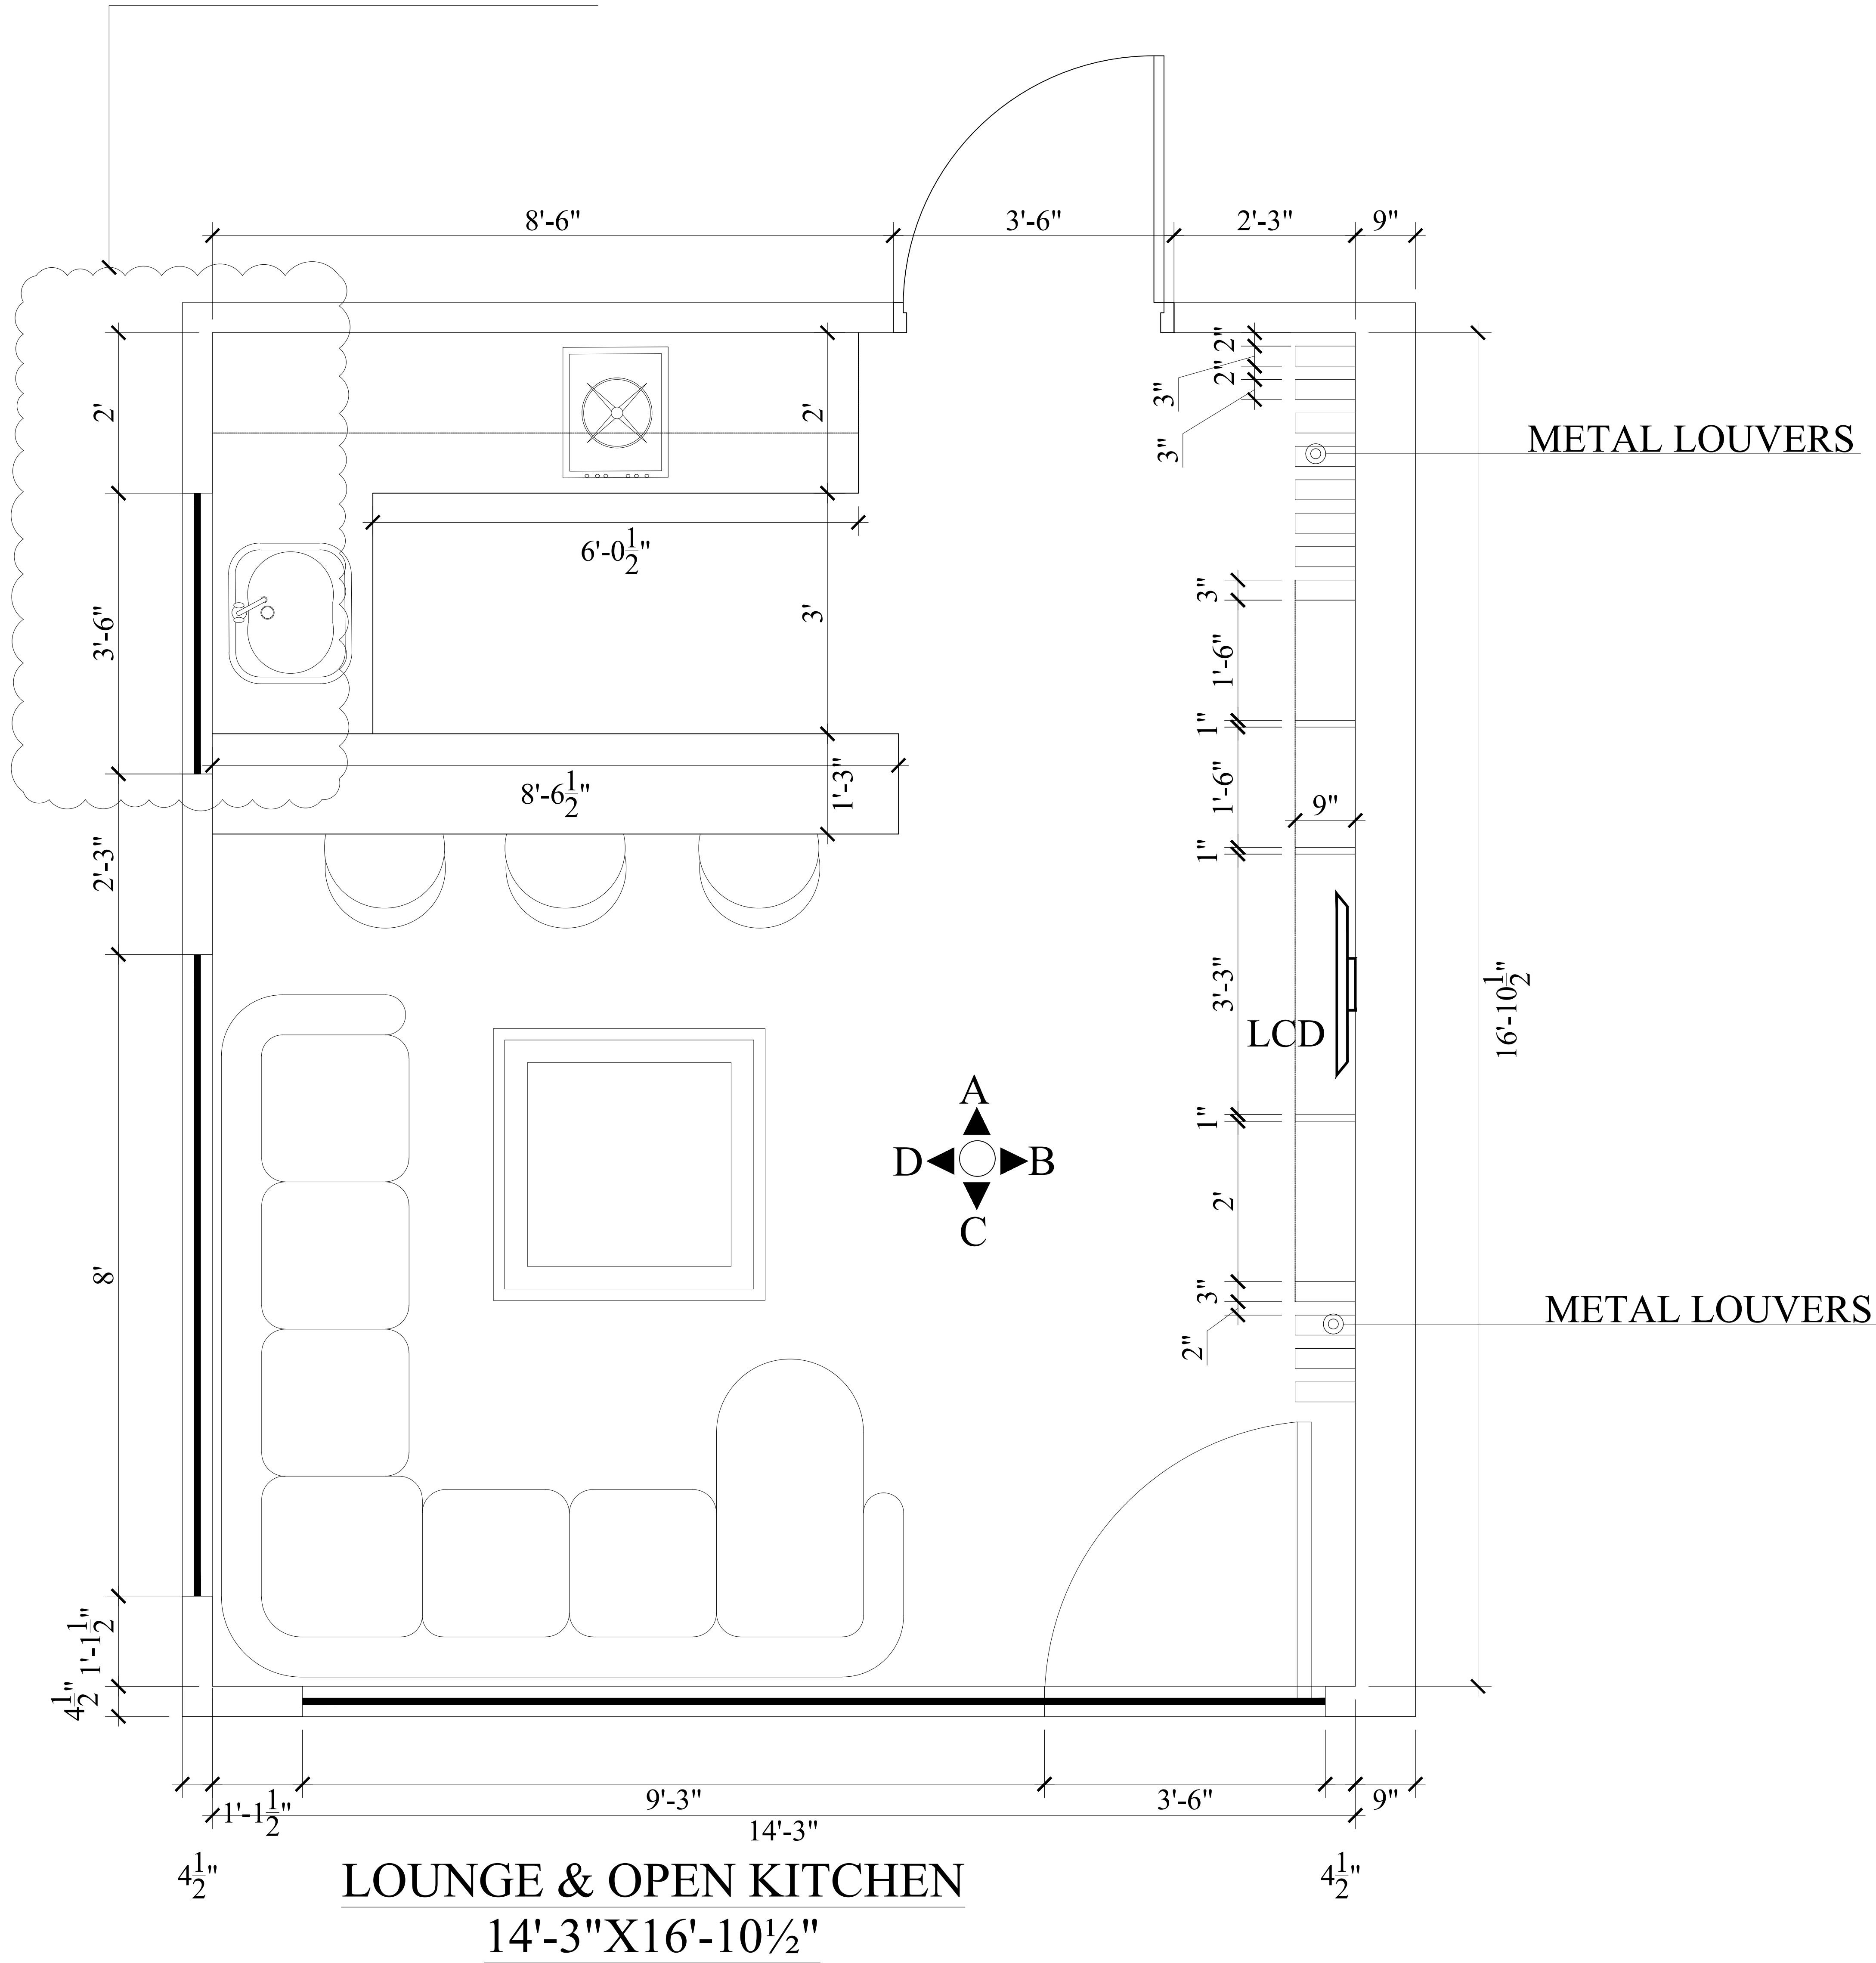

TV LOUNGE & OPEN KITCHEN
FURNITURE & FLOOR PLAN

PAGE NO.	15	DRAWING NO.	INT-13	DESIGN BY:	Aqib ali
CLIENT:		PROJECT :	MURREE COTTAGE HOUSE	DRAWN BY:	Eshan
				DATE:	23.08.2024